



SMITH DESIGN GROUP, INC.
 20 WEST HUNTERSON STREET
 LAGRANGE, GEORGIA 30240
 706-882-5511 www.SDGarch.net

LEGEND

- ⊕ HOSE BIBB
- COLD WATER
- - - - - HOT WATER
- GAS PIPING


REVISIONS

DATE	DESCRIPTION

PROJECT:
VERNON ROAD FIRE STATION
 VERNON ROAD
 LAGRANGE GEORGIA

TITLE:
**PLUMBING PLAN
 FIRST FLOOR**

MODIFIED DATE:	JOB NO: 1731
ISSUED DATE: FOR BID AND PERMIT 07 MAY 2018	SHEET: P-6

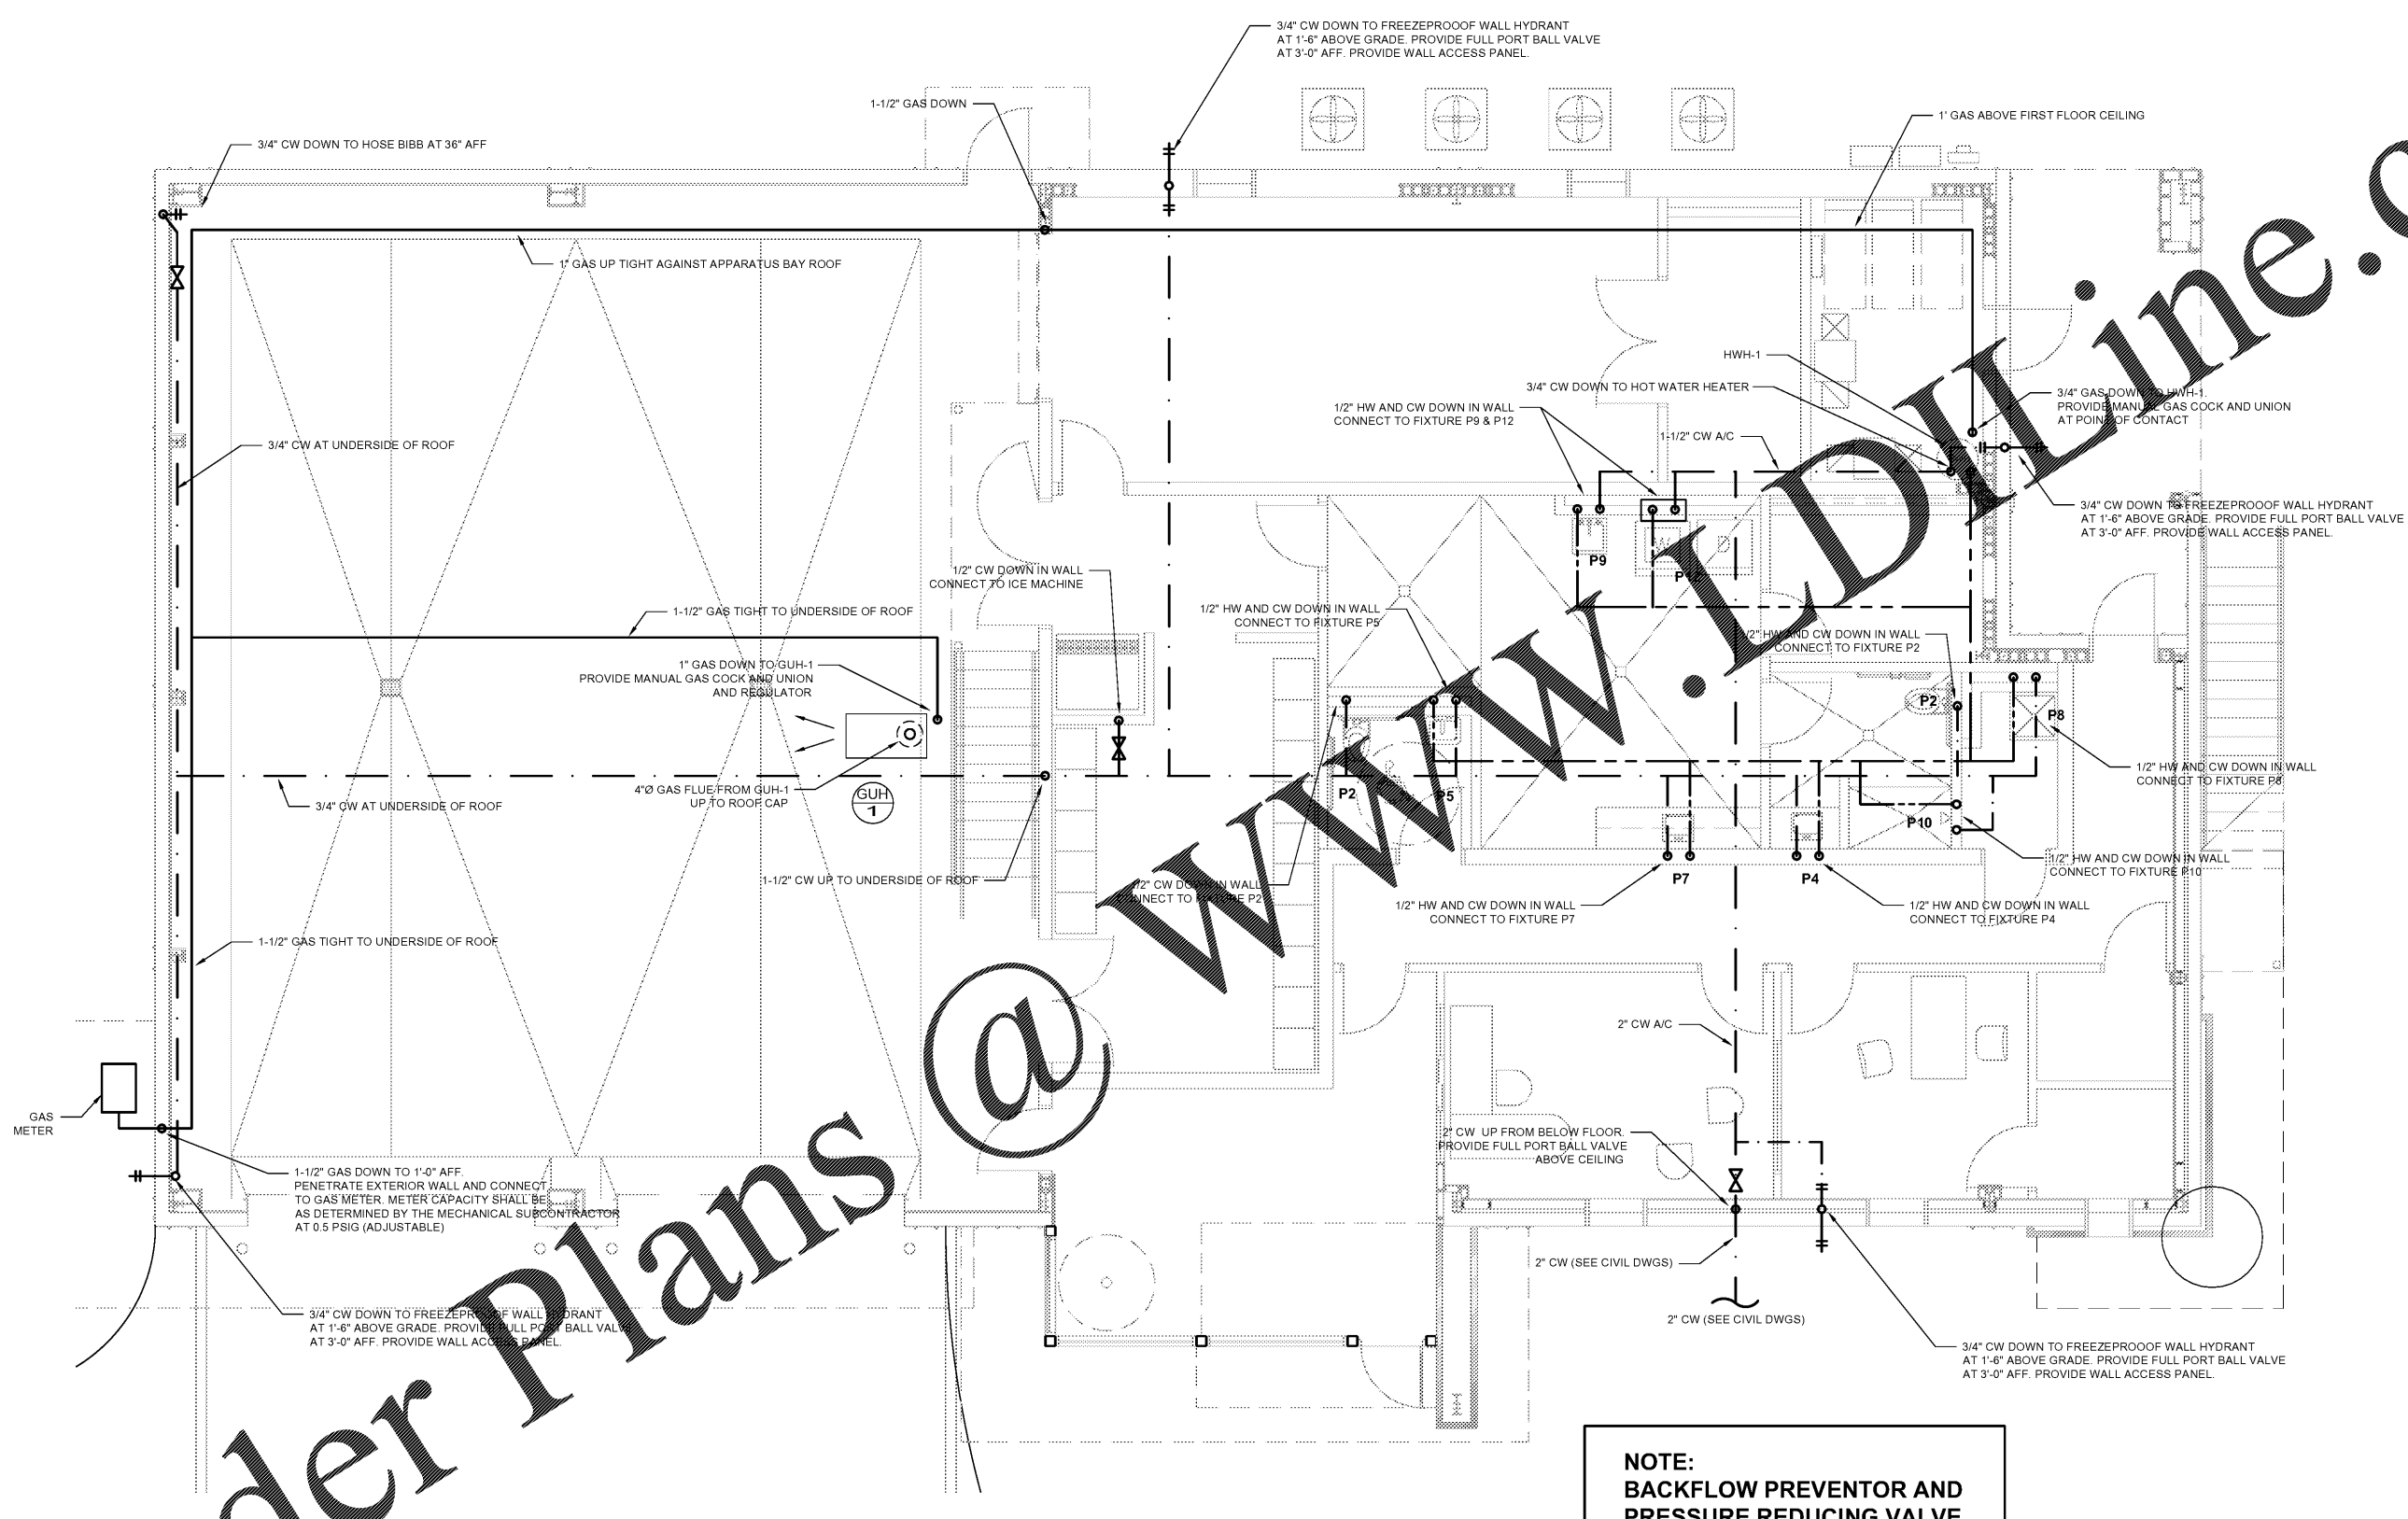

**NOTE:
 BACKFLOW PREVENTOR AND
 PRESSURE REDUCING VALVE
 LOCATED AT STREET IN VAULT**

1 PLUMBING PLAN - FIRST FLOOR
 P-6 SCALE: 1/4" = 1'-0"

Order Plans @ WWW.IDLine.com