



SIGNATURE REQUIRED

SMITH DESIGN GROUP, INC.

200 WEST HUNTERSON STREET
 LAGRANGE, GEORGIA 30240
 706-882-5511 www.SDGarch.net

LEGEND

- HOSE BIBB
- COLD WATER
- HOT WATER
- GAS PIPING


REVISIONS

DATE	DESCRIPTION

PROJECT:
VERNON ROAD FIRE STATION
 VERNON ROAD
 LAGRANGE GEORGIA

TITLE:
**PLUMBING PLAN
 SECOND FLOOR**

MODIFIED DATE:	JOB NO: 1731
ISSUED DATE: FOR BID AND PERMIT 07 MAY 2018	SHEET: P-7

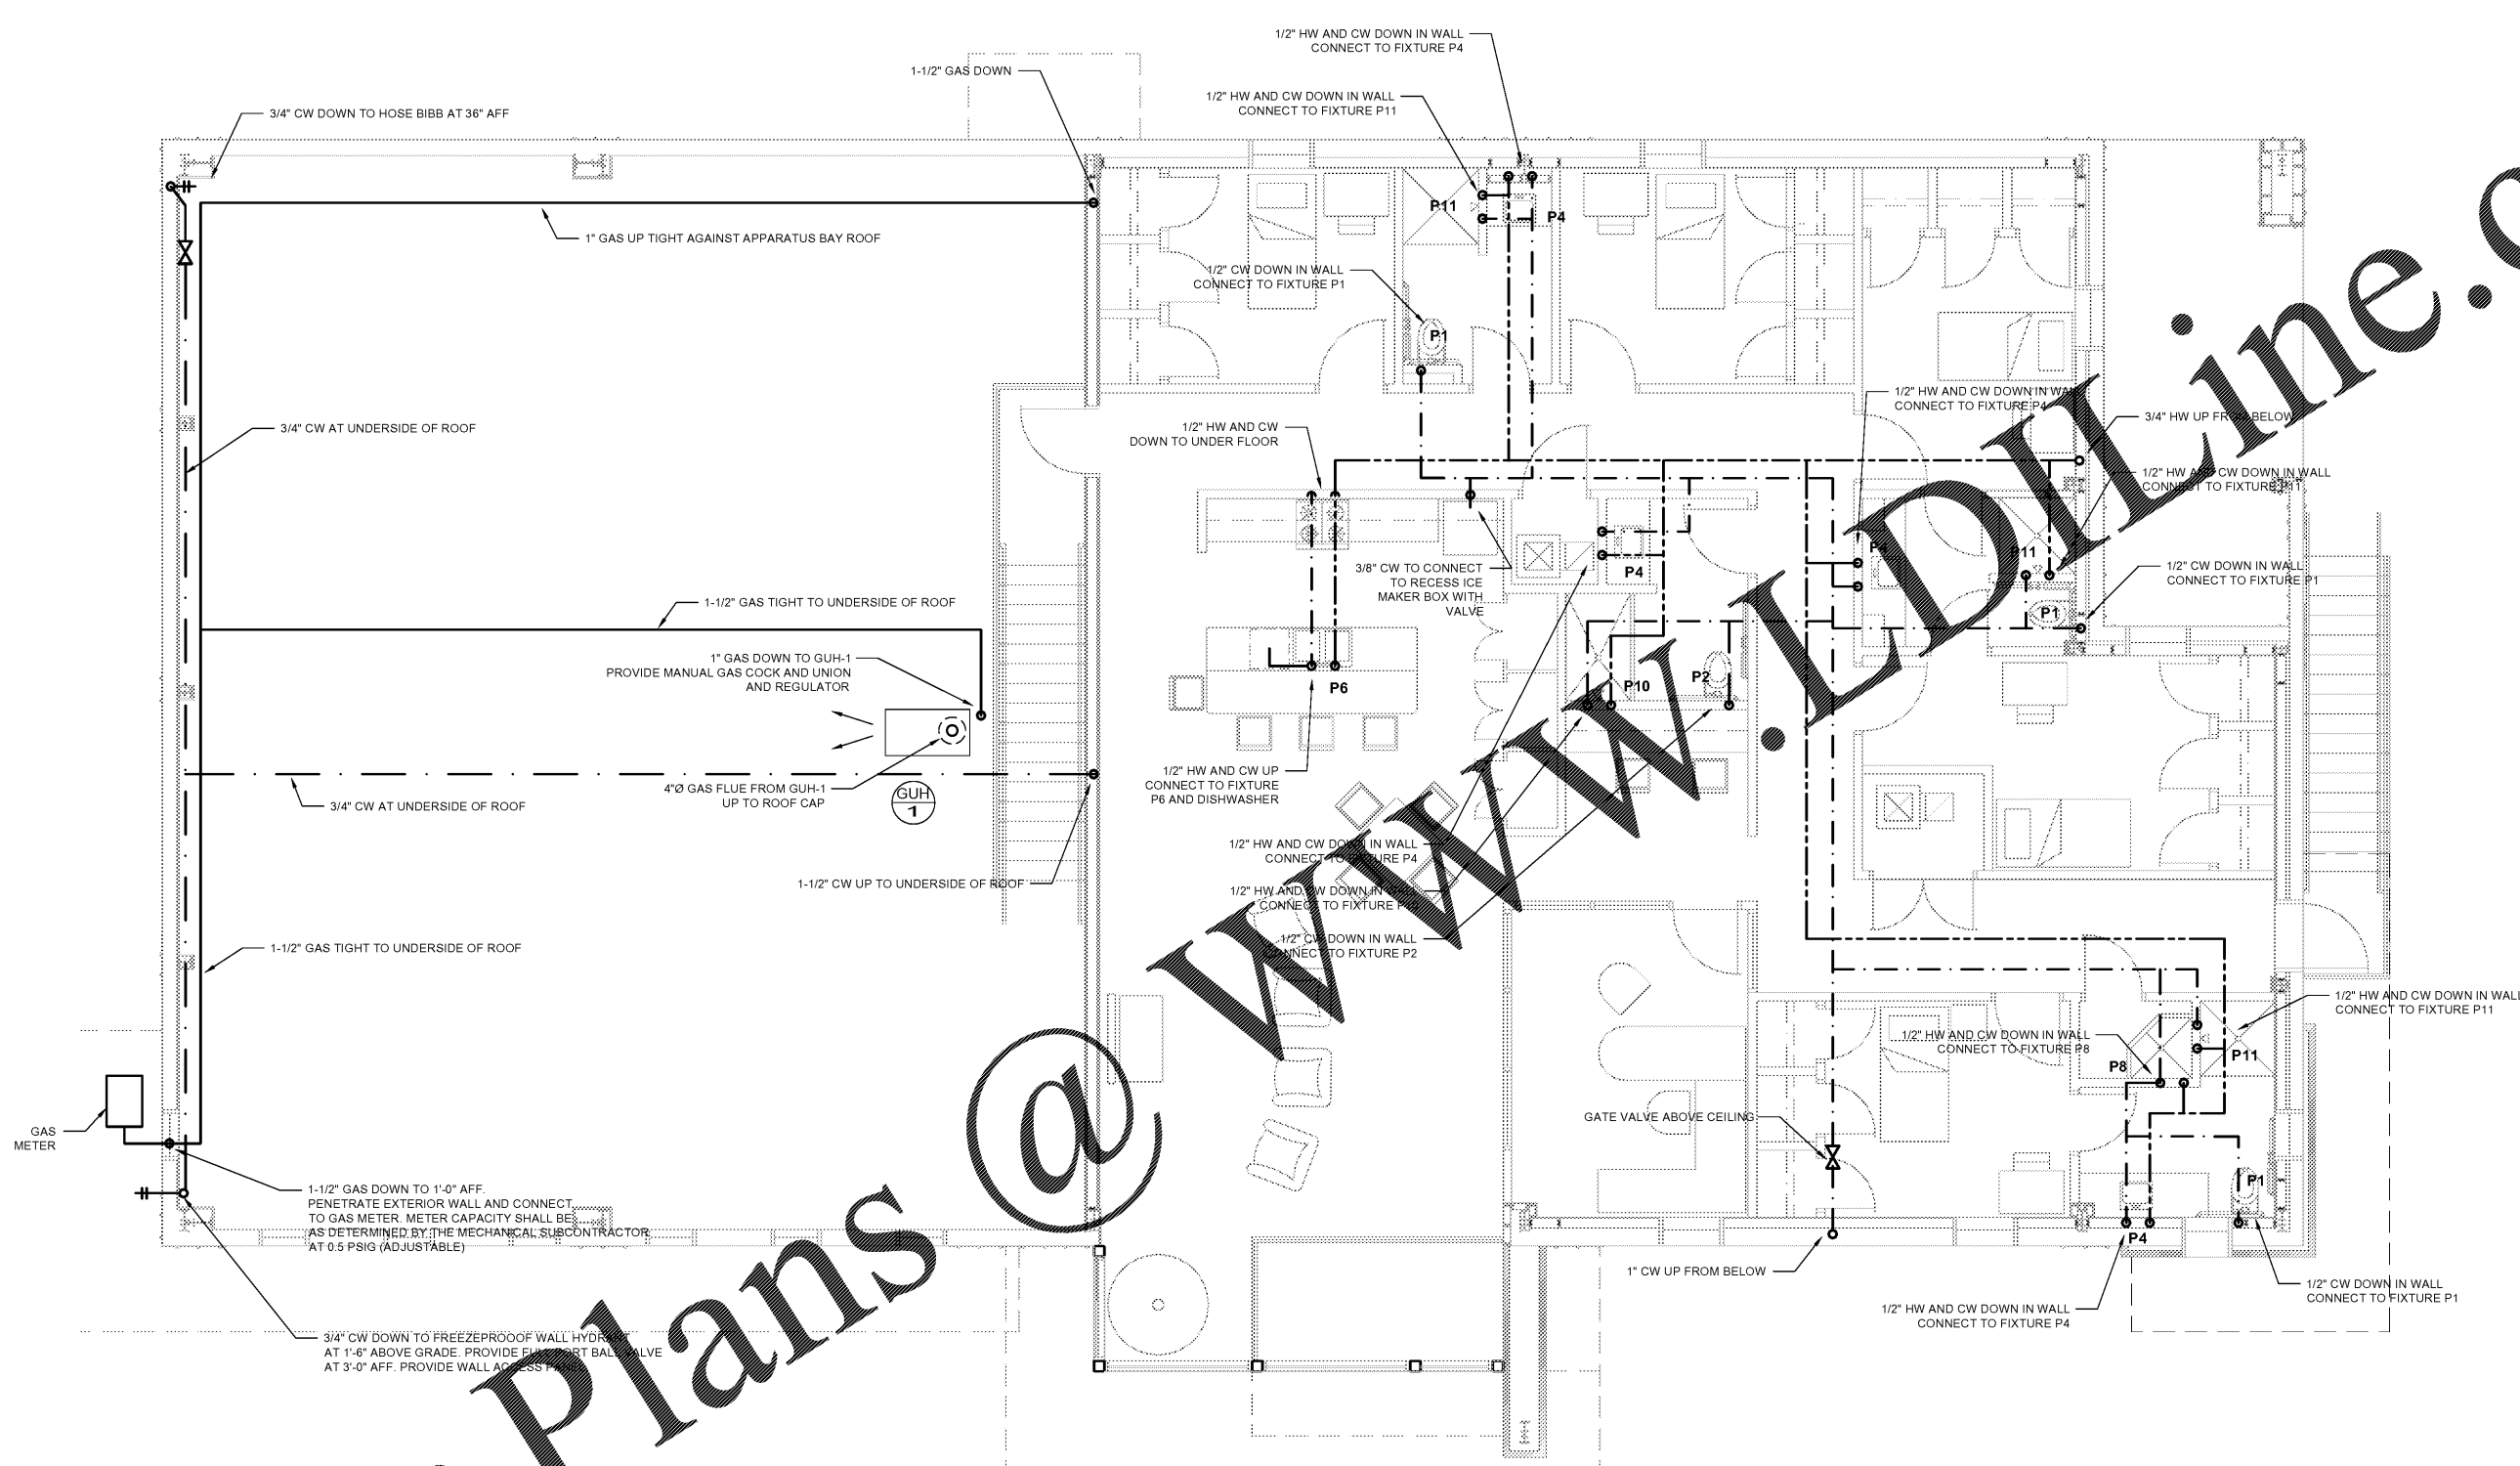

PLUMBING PLAN - SECOND FLOOR
 SCALE: 1/4" = 1'-0"

Order Plans

@

www.LDOnline.com