

TELCOM / DATA / BROADBAND (V/D/B) DEVICES & CABLING		
SYMBOL	MTG. HGT.	TELCOM (VOICE / DATA) SYMBOL DESCRIPTIONS
	18" AFF	SINGLE VOICE WALL JACK & 3 PORT COVERPLATE 4" SQ BOX W/ 1 GANG COVER & 1" C STUB-UP TO PLENUM & CABLE SUPPORT PROVIDE VOICE JACK AND CABLE FROM JACK TO EQUIPMENT TERMINATION POINT
	18" AFF	SINGLE DATA WALL JACK & 3 PORT COVERPLATE 4" SQ BOX W/ 1 GANG COVER & 1" C STUB-UP TO PLENUM & CABLE SUPPORT PROVIDE DATA JACK AND CABLE FROM JACK TO EQUIPMENT TERMINATION POINT
	18" AFF	DUPLEX 1-VOICE & 1-DATA JACKS & 4 PORT COVERPLATE 4" SQ BOX W/ 1 GANG COVER & 1" C STUB-UP TO PLENUM & CABLE SUPPORT PROVIDE JACKS AND CABLING FROM EACH JACK TO EQUIPMENT TERMINATION POINTS
	18" AFF	SINGLE WALL COAX TAP OUTLET WITH MATCHING COVER 4" SQ BOX W/ 1 GANG COVER & 1" C STUB-UP TO PLENUM & CABLE SUPPORT
	18" AFF	TYPE 'T' JACK SUB / VHF/UHF / GATV W/ COAX TO HEADEND / SPLITTER

NOTE - ELECTRICAL SUBCONTRACTOR IS TO COORDINATE ALL VOLTAGE AND BREAKER SIZES WITH MECHANICAL SUBCONTRACTOR FOR ALL MECHANICAL EQUIPMENT AND PROVIDE POWER AND DISCONNECTS AS NEEDED, EVEN IF NOT SHOWN ON THESE DRAWINGS.

COORDINATE EXACT LOCATION WITH CIVIL DRAWINGS

ARCHITECT'S STAMP

SIGNATURE REQUIRED

SMITH DESIGN GROUP, INC.
206 WEST HAMILTON STREET
LAGRANGE, GEORGIA 30240
770-882-5511 www.SDGarch.net

LEGEND

	EXTERIOR WEATHERPROOF OUTLET
	110V DUPLEX OUTLET
	110V QUAD OUTLET
	VOICE / DATA DROP
	JUNCTION BOX FOR POWER
	POWER IN FLOOR (VERIFY WITH OWNER)
	WEATHERPROOF DISCONNECT
	EXHAUST FAN TO OUTSIDE
	CABLE TV OUTLET
	RATED WALL - EXTEND TIGHT AGAINST FLOOR OR ROOF DECK ABOVE. SEAL ALL PENETRATIONS.


REVISIONS

DATE	DESCRIPTION

PROJECT:
VERNON ROAD FIRE STATION
VERNON ROAD
LAGRANGE GEORGIA

TITLE:
**ARCHITECTURAL
ELECTRICAL
POWER PLAN
FIRST FLOOR PLAN**

MODIFIED DATE:	JOB NO: 1731
ISSUED DATE: FOR BID AND PERMIT 07 MAY 2018	SHEET: E-4

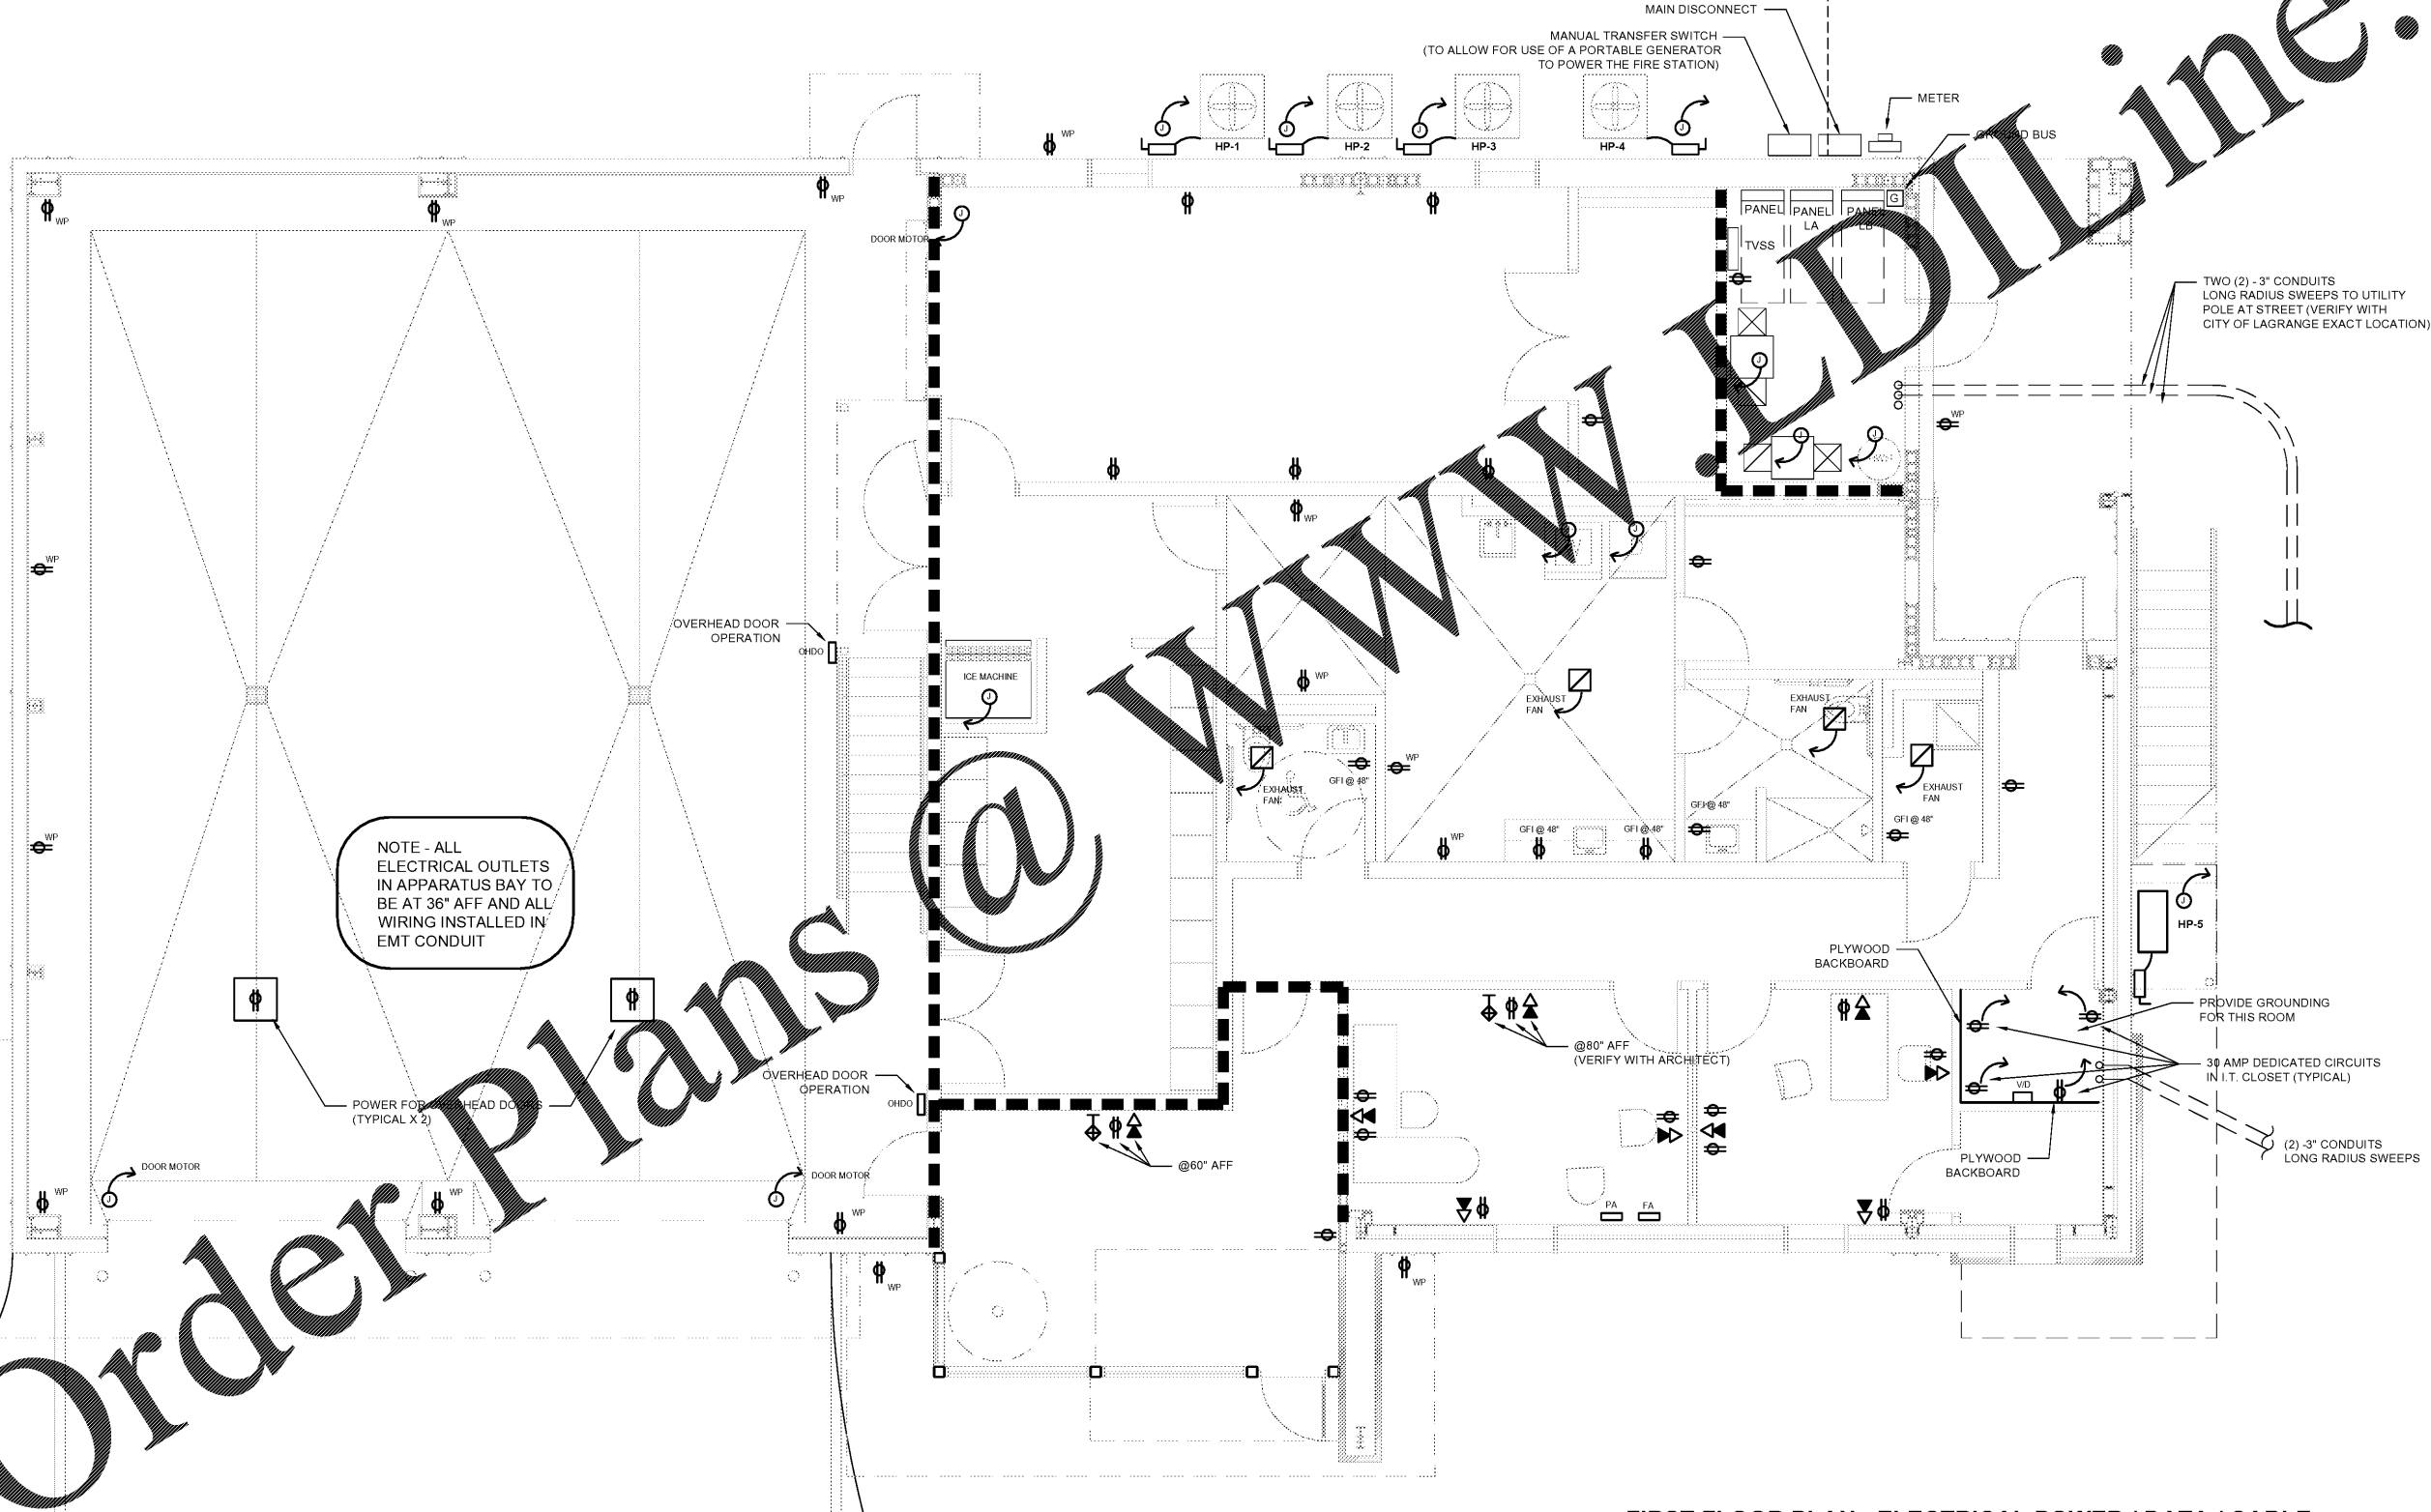

1 FIRST FLOOR PLAN - ELECTRICAL POWER / DATA / CABLE
SCALE: 1/4" = 1'-0"

Order Plans @ www.edline.com