

TELCOM / DATA / BROADBAND (V/D/B) DEVICES & CABLING		
SYMBOL	MTG. HGT.	TELCOM (VOICE / DATA) SYMBOL DESCRIPTIONS
	18" AFF	SINGLE VOICE WALL JACK & 3 PORT COVERPLATE 4" SQ BOX W/ 1 GANG COVER & 1" C STUB-UP TO PLENUM & CABLE SUPPORT PROVIDE VOICE JACK AND CABLE FROM JACK TO EQUIPMENT TERMINATION POINT
	18" AFF	SINGLE DATA WALL JACK & 3 PORT COVERPLATE 4" SQ BOX W/ 1 GANG COVER & 1" C STUB-UP TO PLENUM & CABLE SUPPORT PROVIDE DATA JACK AND CABLE FROM JACK TO EQUIPMENT TERMINATION POINT
	18" AFF	DUPLEX 1-VOICE & 1-DATA JACKS & 4 PORT COVERPLATE 4" SQ BOX W/ 1 GANG COVER & 1" C STUB-UP TO PLENUM & CABLE SUPPORT PROVIDE JACKS AND CABLING FROM EACH JACK TO EQUIPMENT TERMINATION POINTS
	18" AFF	SINGLE WALL COAX TAP OUTLET WITH MATCHING COVER 4" SQ BOX W/ 1 GANG COVER & 1" C STUB-UP TO PLENUM & CABLE SUPPORT
	18" AFF	TYPE 'T' JACK SUB / VHF/UHF / GATV W/ COAX TO HEADEND / SPLITTER

NOTE - ELECTRICAL SUBCONTRACTOR IS TO COORDINATE ALL VOLTAGE AND BREAKER SIZES WITH MECHANICAL SUBCONTRACTOR FOR ALL MECHANICAL EQUIPMENT AND PROVIDE POWER AND DISCONNECTS AS NEEDED, EVEN IF NOT SHOWN ON THESE DRAWINGS.

COORDINATE EXACT LOCATION WITH CIVIL DRAWINGS


ARCHITECT'S STAMP

SIGNATURE REQUIRED

**SMITH DESIGN GROUP, INC.**  
206 WEST HAMILTON STREET  
LAGRANGE, GEORGIA 30240  
770-882-5511 www.SDGarch.net

**LEGEND**

- EXTERIOR WEATHERPROOF OUTLET
- 110V DUPLEX OUTLET
- 110V QUAD OUTLET
- VOICE / DATA DROP
- JUNCTION BOX FOR POWER
- POWER IN FLOOR (VERIFY WITH OWNER)
- WEATHERPROOF DISCONNECT
- EXHAUST FAN TO OUTSIDE
- CABLE TV OUTLET
- RATED WALL - EXTEND TIGHT AGAINST FLOOR OR ROOF DECK ABOVE. SEAL ALL PENETRATIONS.

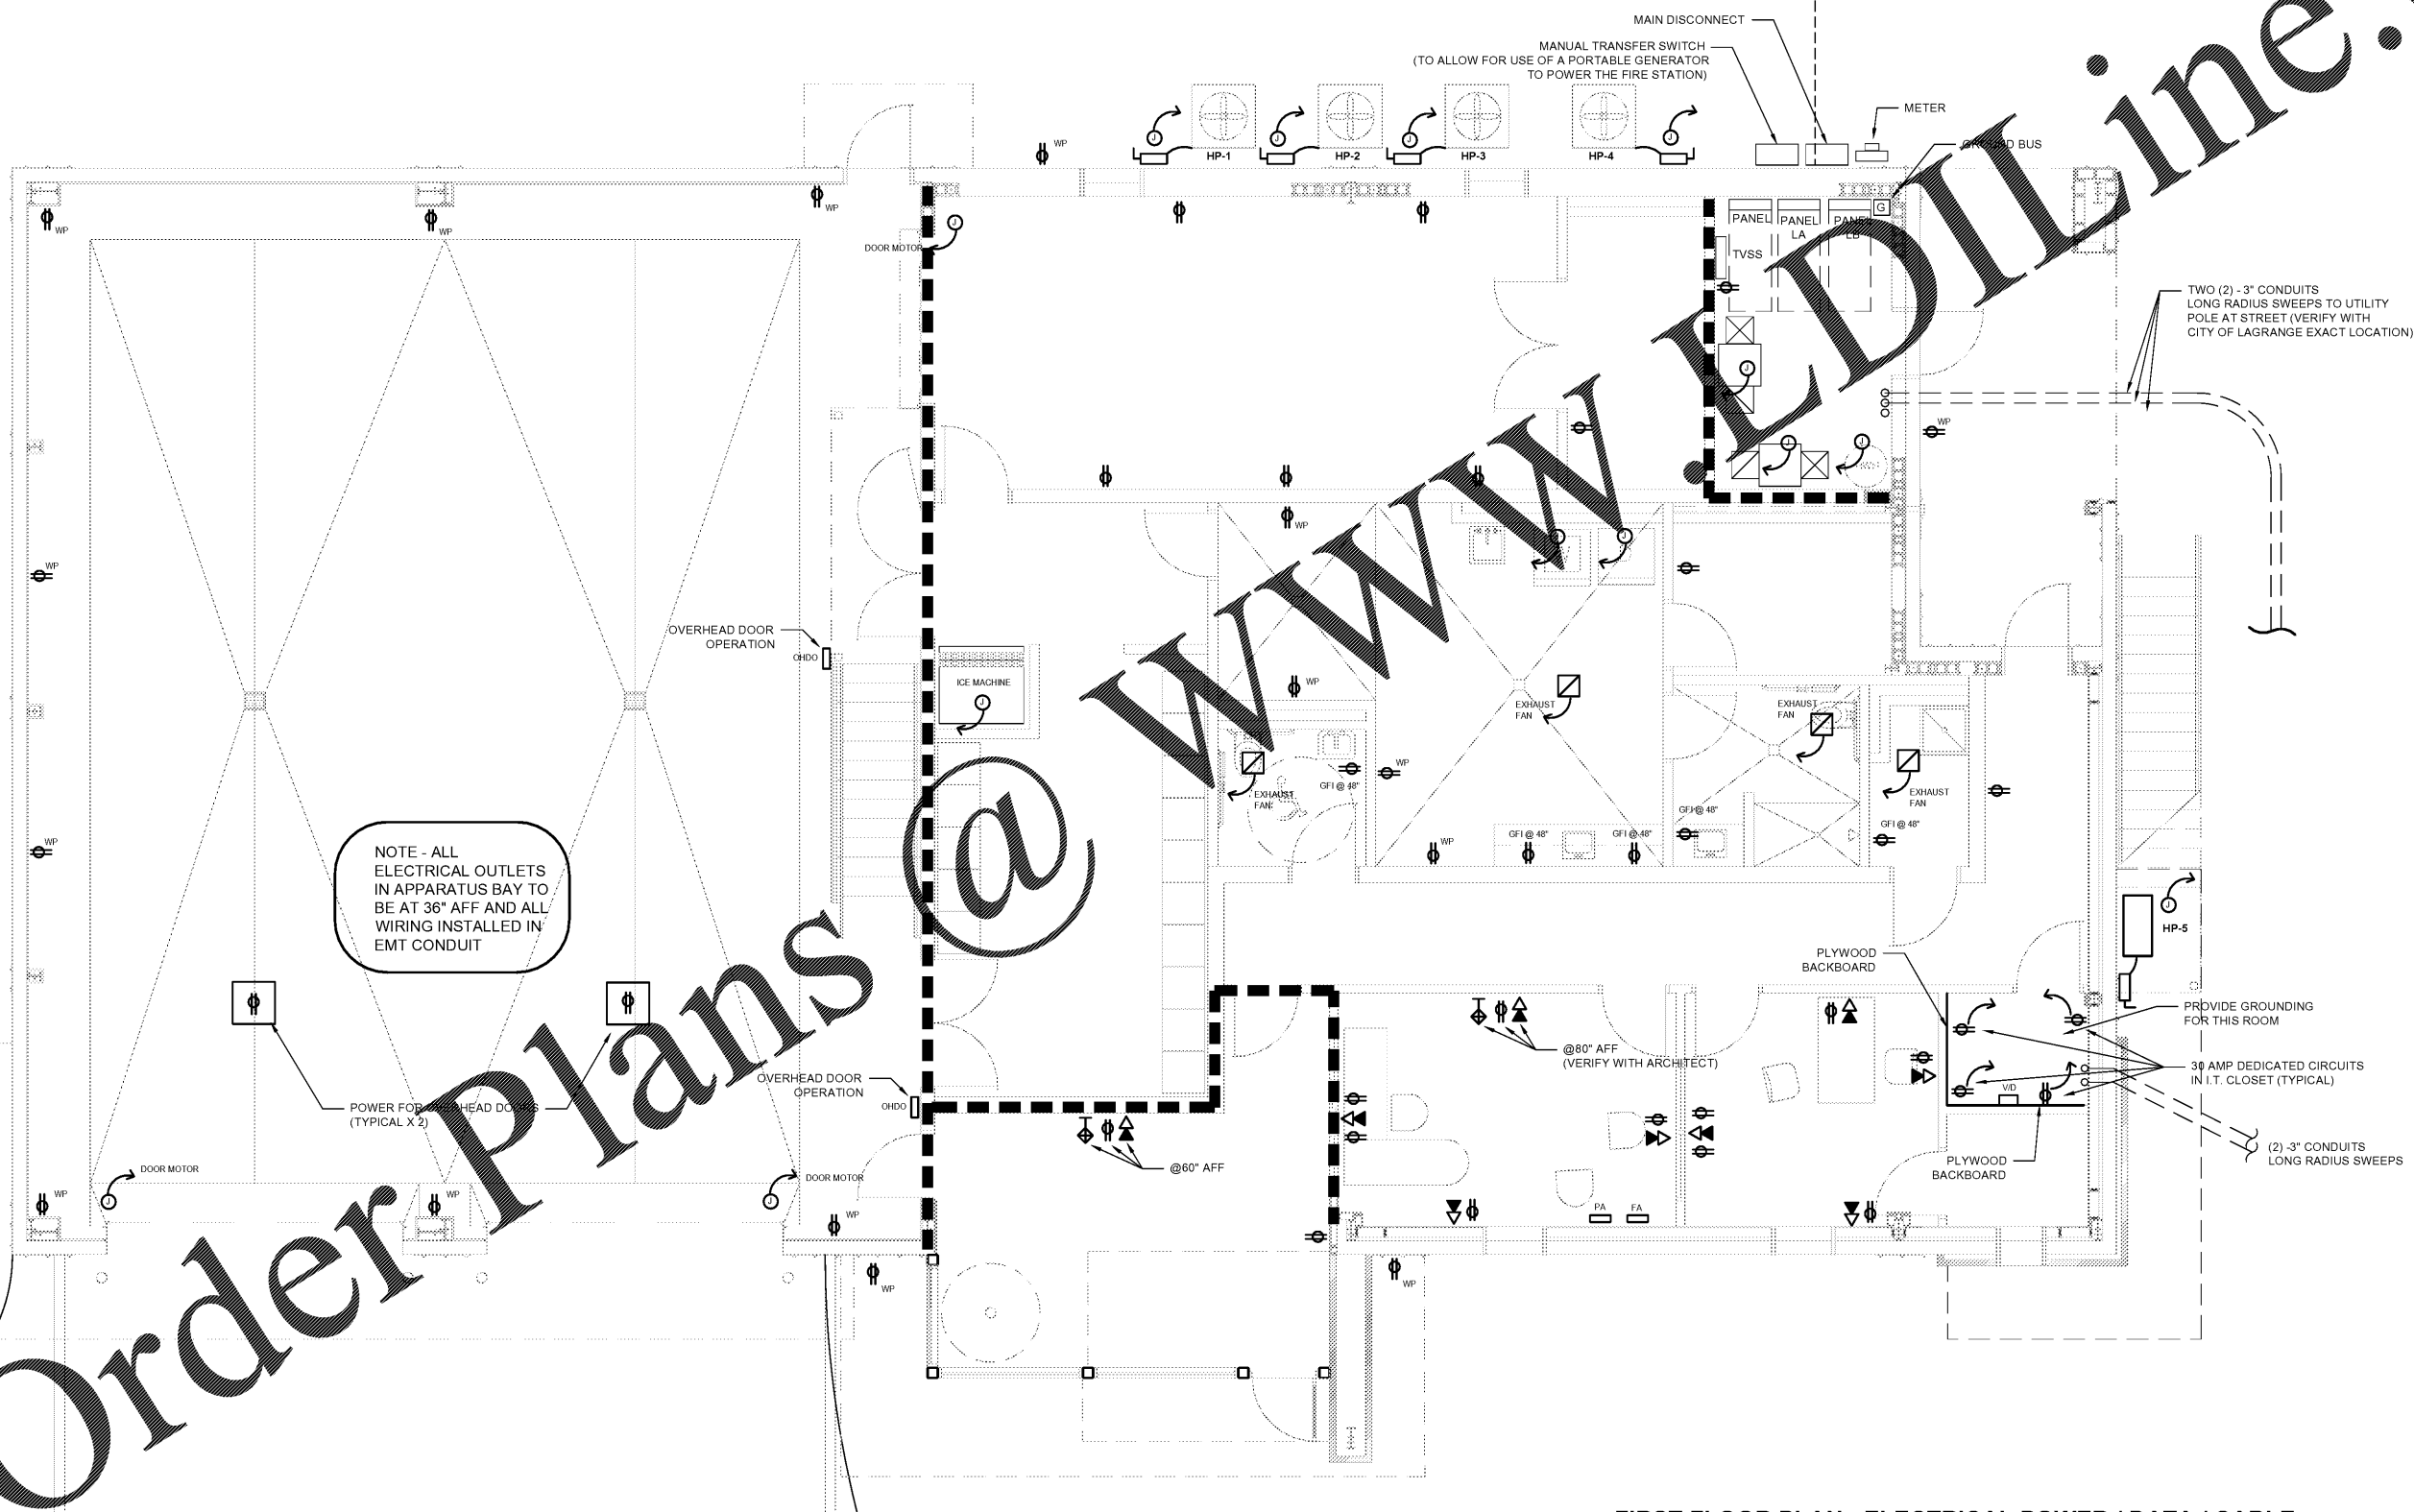

**REVISIONS**

DATE	DESCRIPTION

PROJECT:  
**VERNON ROAD FIRE STATION**  
VERNON ROAD  
LAGRANGE GEORGIA

TITLE:  
**ARCHITECTURAL ELECTRICAL POWER PLAN FIRST FLOOR PLAN**

MODIFIED DATE:	JOB NO. <b>1731</b>
ISSUED DATE: FOR BID AND PERMIT 07 MAY 2018	SHEET: <b>E-4</b>

**1** FIRST FLOOR PLAN - ELECTRICAL POWER / DATA / CABLE  
SCALE: 1/4" = 1'-0"