

TELCOM / DATA / BROADBAND (V/D/B) DEVICES & CABLING		
SYMBOL	MTG. HGT.	TELCOM (VOICE / DATA) SYMBOL DESCRIPTIONS
	18" AFF	SINGLE VOICE WALL JACK & 3 PORT COVERPLATE 4" SQ BOX W/ 1 GANG COVER & 1" C STUB-UP TO PLENUM & CABLE SUPPORT PROVIDE VOICE JACK AND CABLE FROM JACK TO EQUIPMENT TERMINATION POINT
	18" AFF	SINGLE DATA WALL JACK & 3 PORT COVERPLATE 4" SQ BOX W/ 1 GANG COVER & 1" C STUB-UP TO PLENUM & CABLE SUPPORT PROVIDE DATA JACK AND CABLE FROM JACK TO EQUIPMENT TERMINATION POINT
	18" AFF	DUPLEX 1 VOICE & 1 DATA JACKS & 4 PORT COVERPLATE 4" SQ BOX W/ 1 GANG COVER & 1" C STUB-UP TO PLENUM & CABLE SUPPORT PROVIDE JACKS AND CABLING FROM EACH JACK TO EQUIPMENT TERMINATION POINTS
	18" AFF	SINGLE WALL COAX TAP OUTLET WITH MATCHING COVER 4" SQ BOX W/ 1 GANG COVER & 1" C STUB-UP TO PLENUM & CABLE SUPPORT TYPE 'T' JACK SUB / VHF / UHF / CATV W/ COAX TO HEADEND / SPLITTER

NOTE - ELECTRICAL SUBCONTRACTOR IS TO COORDINATE ALL VOLTAGE AND BREAKER SIZES WITH MECHANICAL SUBCONTRACTOR FOR ALL MECHANICAL EQUIPMENT AND PROVIDE POWER AND DISCONNECTS AS NEEDED, EVEN IF NOT SHOWN ON THESE DRAWINGS.

ARCHITECT'S STAMP

 SIGNATURE REQUIRED
SMITH DESIGN GROUP, INC.
 200 WEST WILKINSON STREET
 LAGRANGE, GEORGIA 30240
 706-882-5511 www.SDGarch.net


LEGEND	
	EXTERIOR WEATHERPROOF OUTLET
	110V DUPLEX OUTLET
	110V QUAD OUTLET
	VOICE / DATA DROP
	JUNCTION BOX FOR POWER
	POWER IN FLOOR (VERIFY WITH OWNER)
	WEATHERPROOF DISCONNECT
	EXHAUST FAN TO OUTSIDE
	CABLE TV OUTLET
	RATED WALL - EXTEND TIGHT AGAINST FLOOR OR ROOF DECK ABOVE. SEAL ALL PENETRATIONS.

REVISIONS	
DATE	DESCRIPTION

PROJECT:
VERNON ROAD FIRE STATION
 VERNON ROAD
 LAGRANGE GEORGIA

TITLE:
**ARCHITECTURAL
 ELECTRICAL
 SECOND FLOOR
 POWER PLAN**

MODIFIED DATE:	JOB NO: 1731
ISSUED DATE: FOR BID AND PERMIT 07 MAY 2018	SHEET: E-5

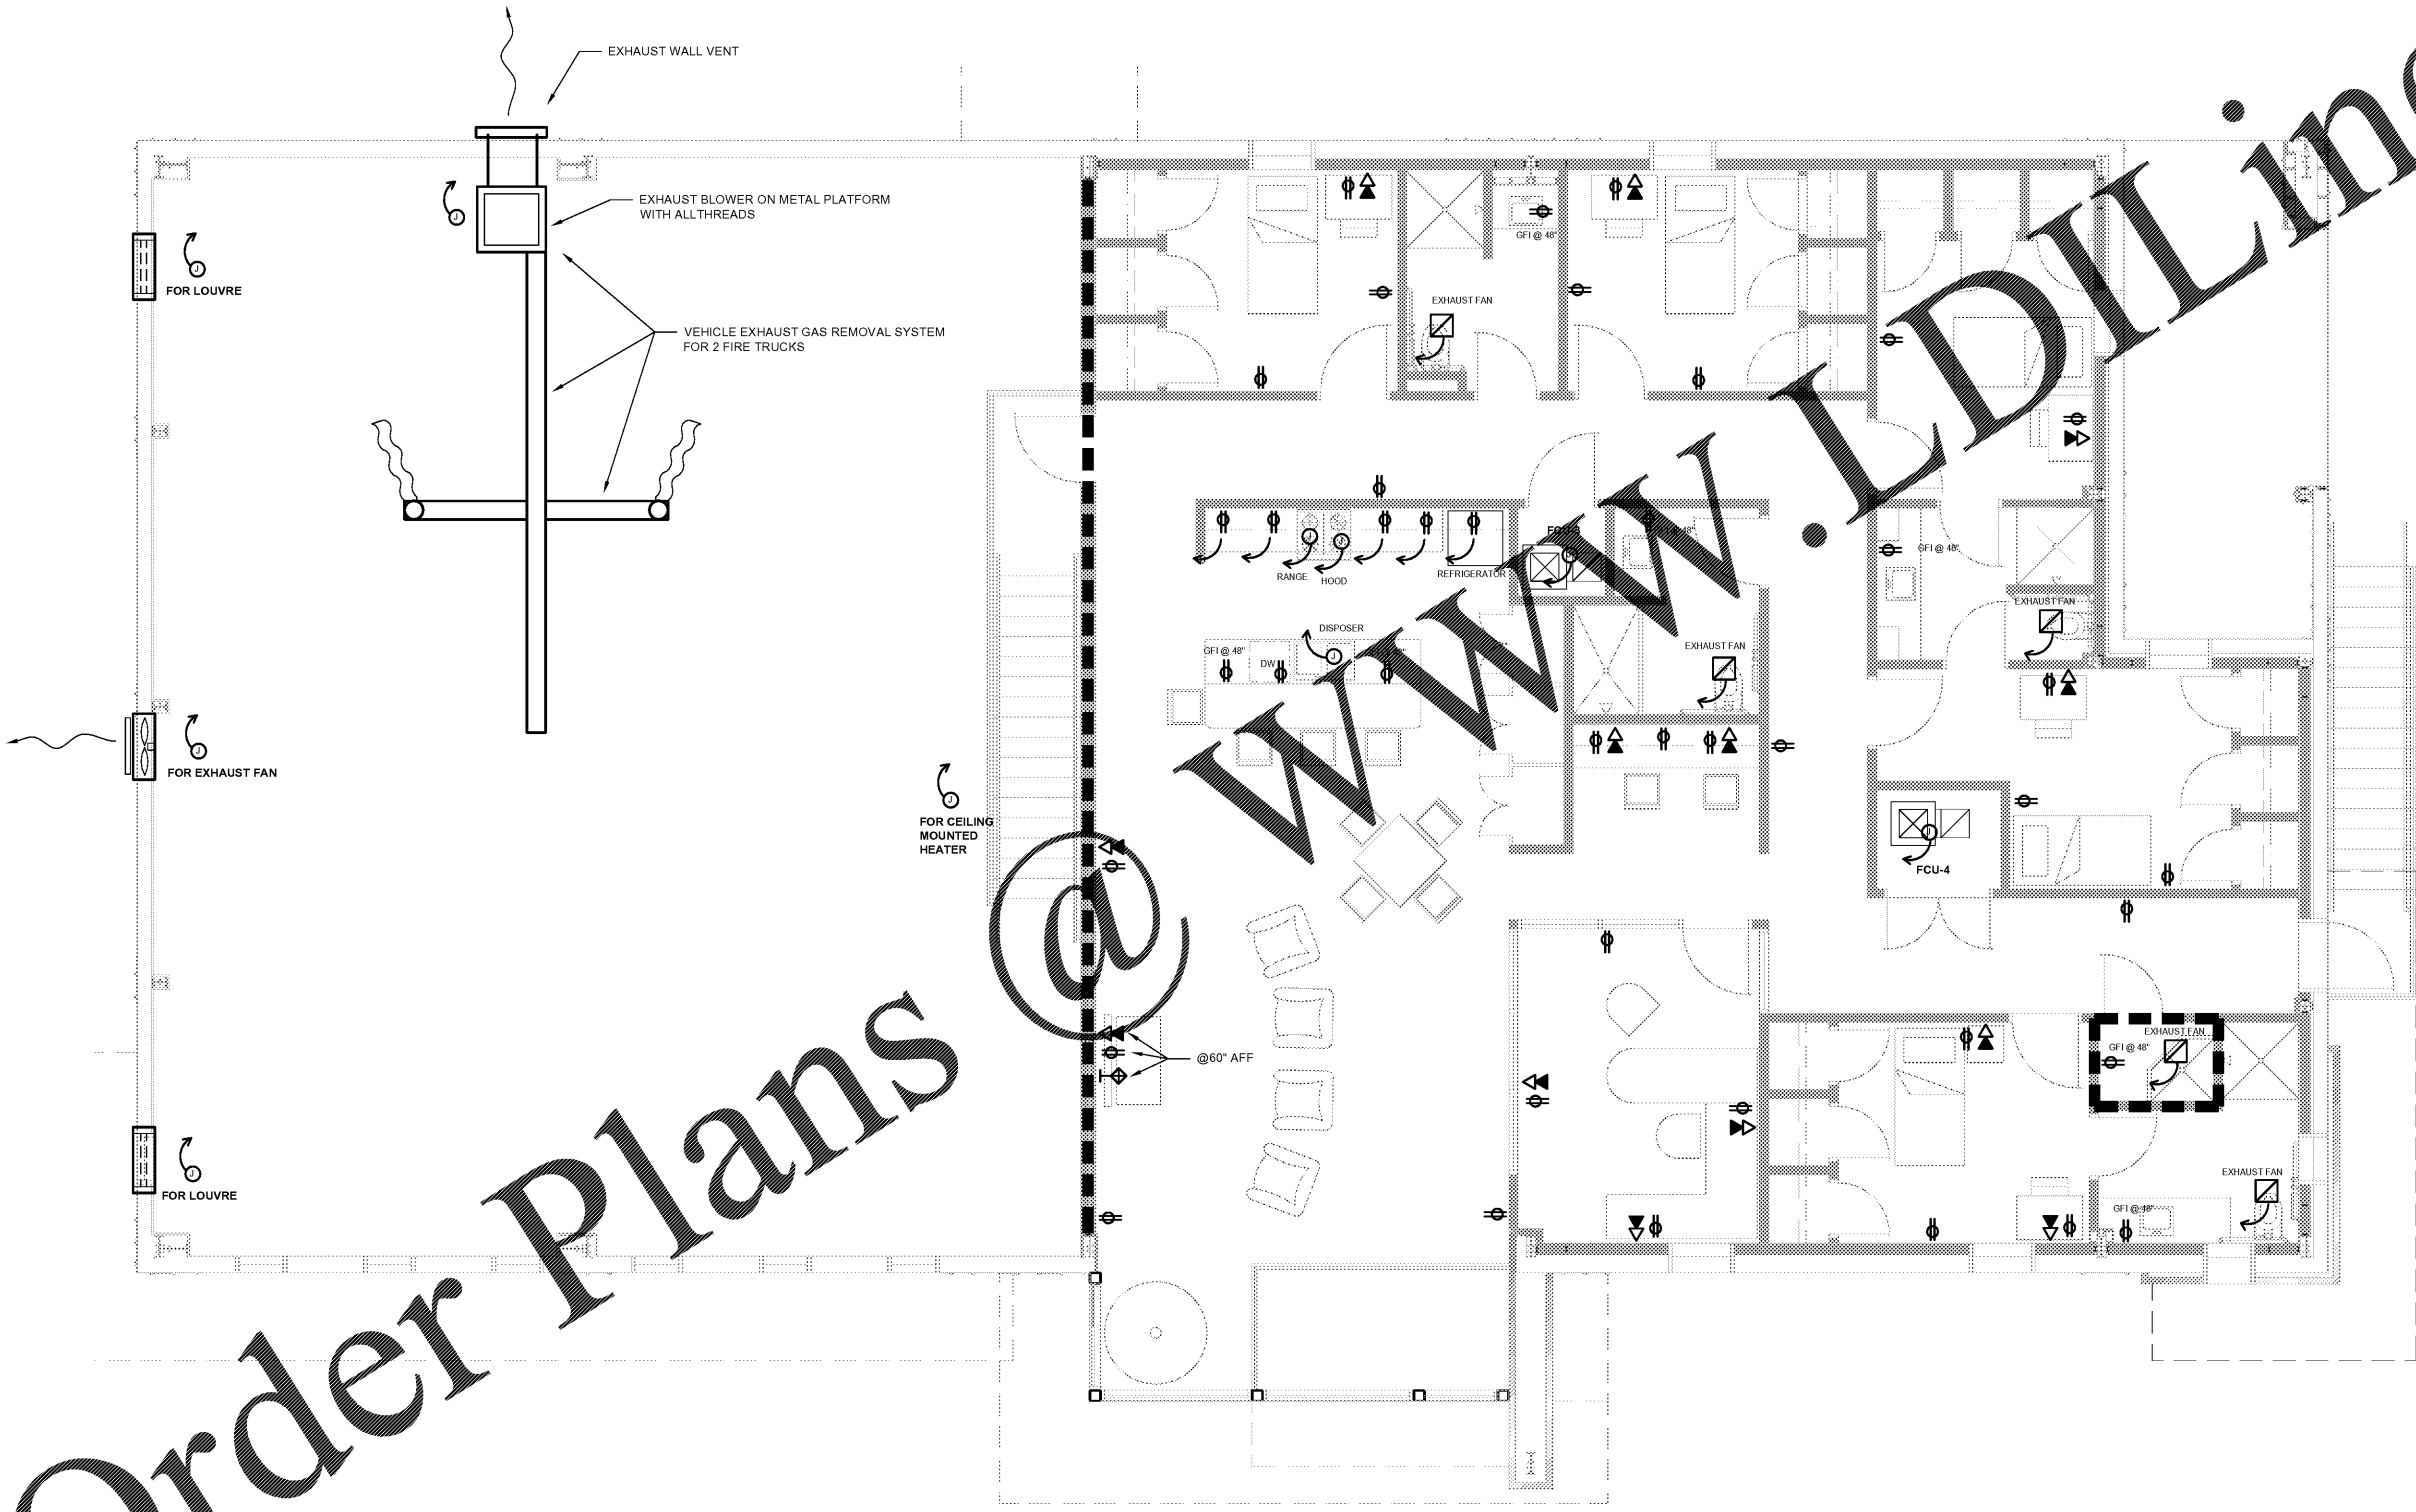

Order Plans

1 SECOND FLOOR PLAN - ELECTRICAL POWER PLAN / DATA / CABLE
 E-5 SCALE: 1/4" = 1'-0"