



SIGNATURE REQUIRED

SMITH DESIGN GROUP, INC.

20 WEST JACKSON STREET
LAGRANGE, GEORGIA 30240
706-882-5511 www.SDGarch.net

LEGEND

- CEILING FAN LIGHT COMBO
- DECORATIVE PENDANT HUNG FIXTURE
- WALL MOUNTED DECORATIVE LIGHT
- 2X4 LED LAY-IN FIXTURE
- 2X2 LED LAY-IN FIXTURE
- 1X4 LED CEILING MOUNTED FIXTURE
-
- WALL SCONCE EACH SIDE OF MIRROR MOUNT AT 5'-6\"/>
-
-
-
-
-
- RATED WALL - EXTEND TIGHT AGAINST FLOOR OR ROOF DECK ABOVE. SEAL ALL PENETRATIONS.


REVISIONS

| DATE | DESCRIPTION |
|------|-------------|
| | |
| | |
PROJECT:
VERNON ROAD FIRE STATION
VERNON ROAD
LAGRANGE GEORGIA

TITLE:
**SECOND FLOOR PLAN
ELECTRICAL LIGHTING
PLAN**

| | |
|---|------------------------|
| MODIFIED DATE: | JOB NO: 1731 |
| ISSUED DATE: FOR BID AND PERMIT 07 MAY 2018 | SHEET: E-7 |

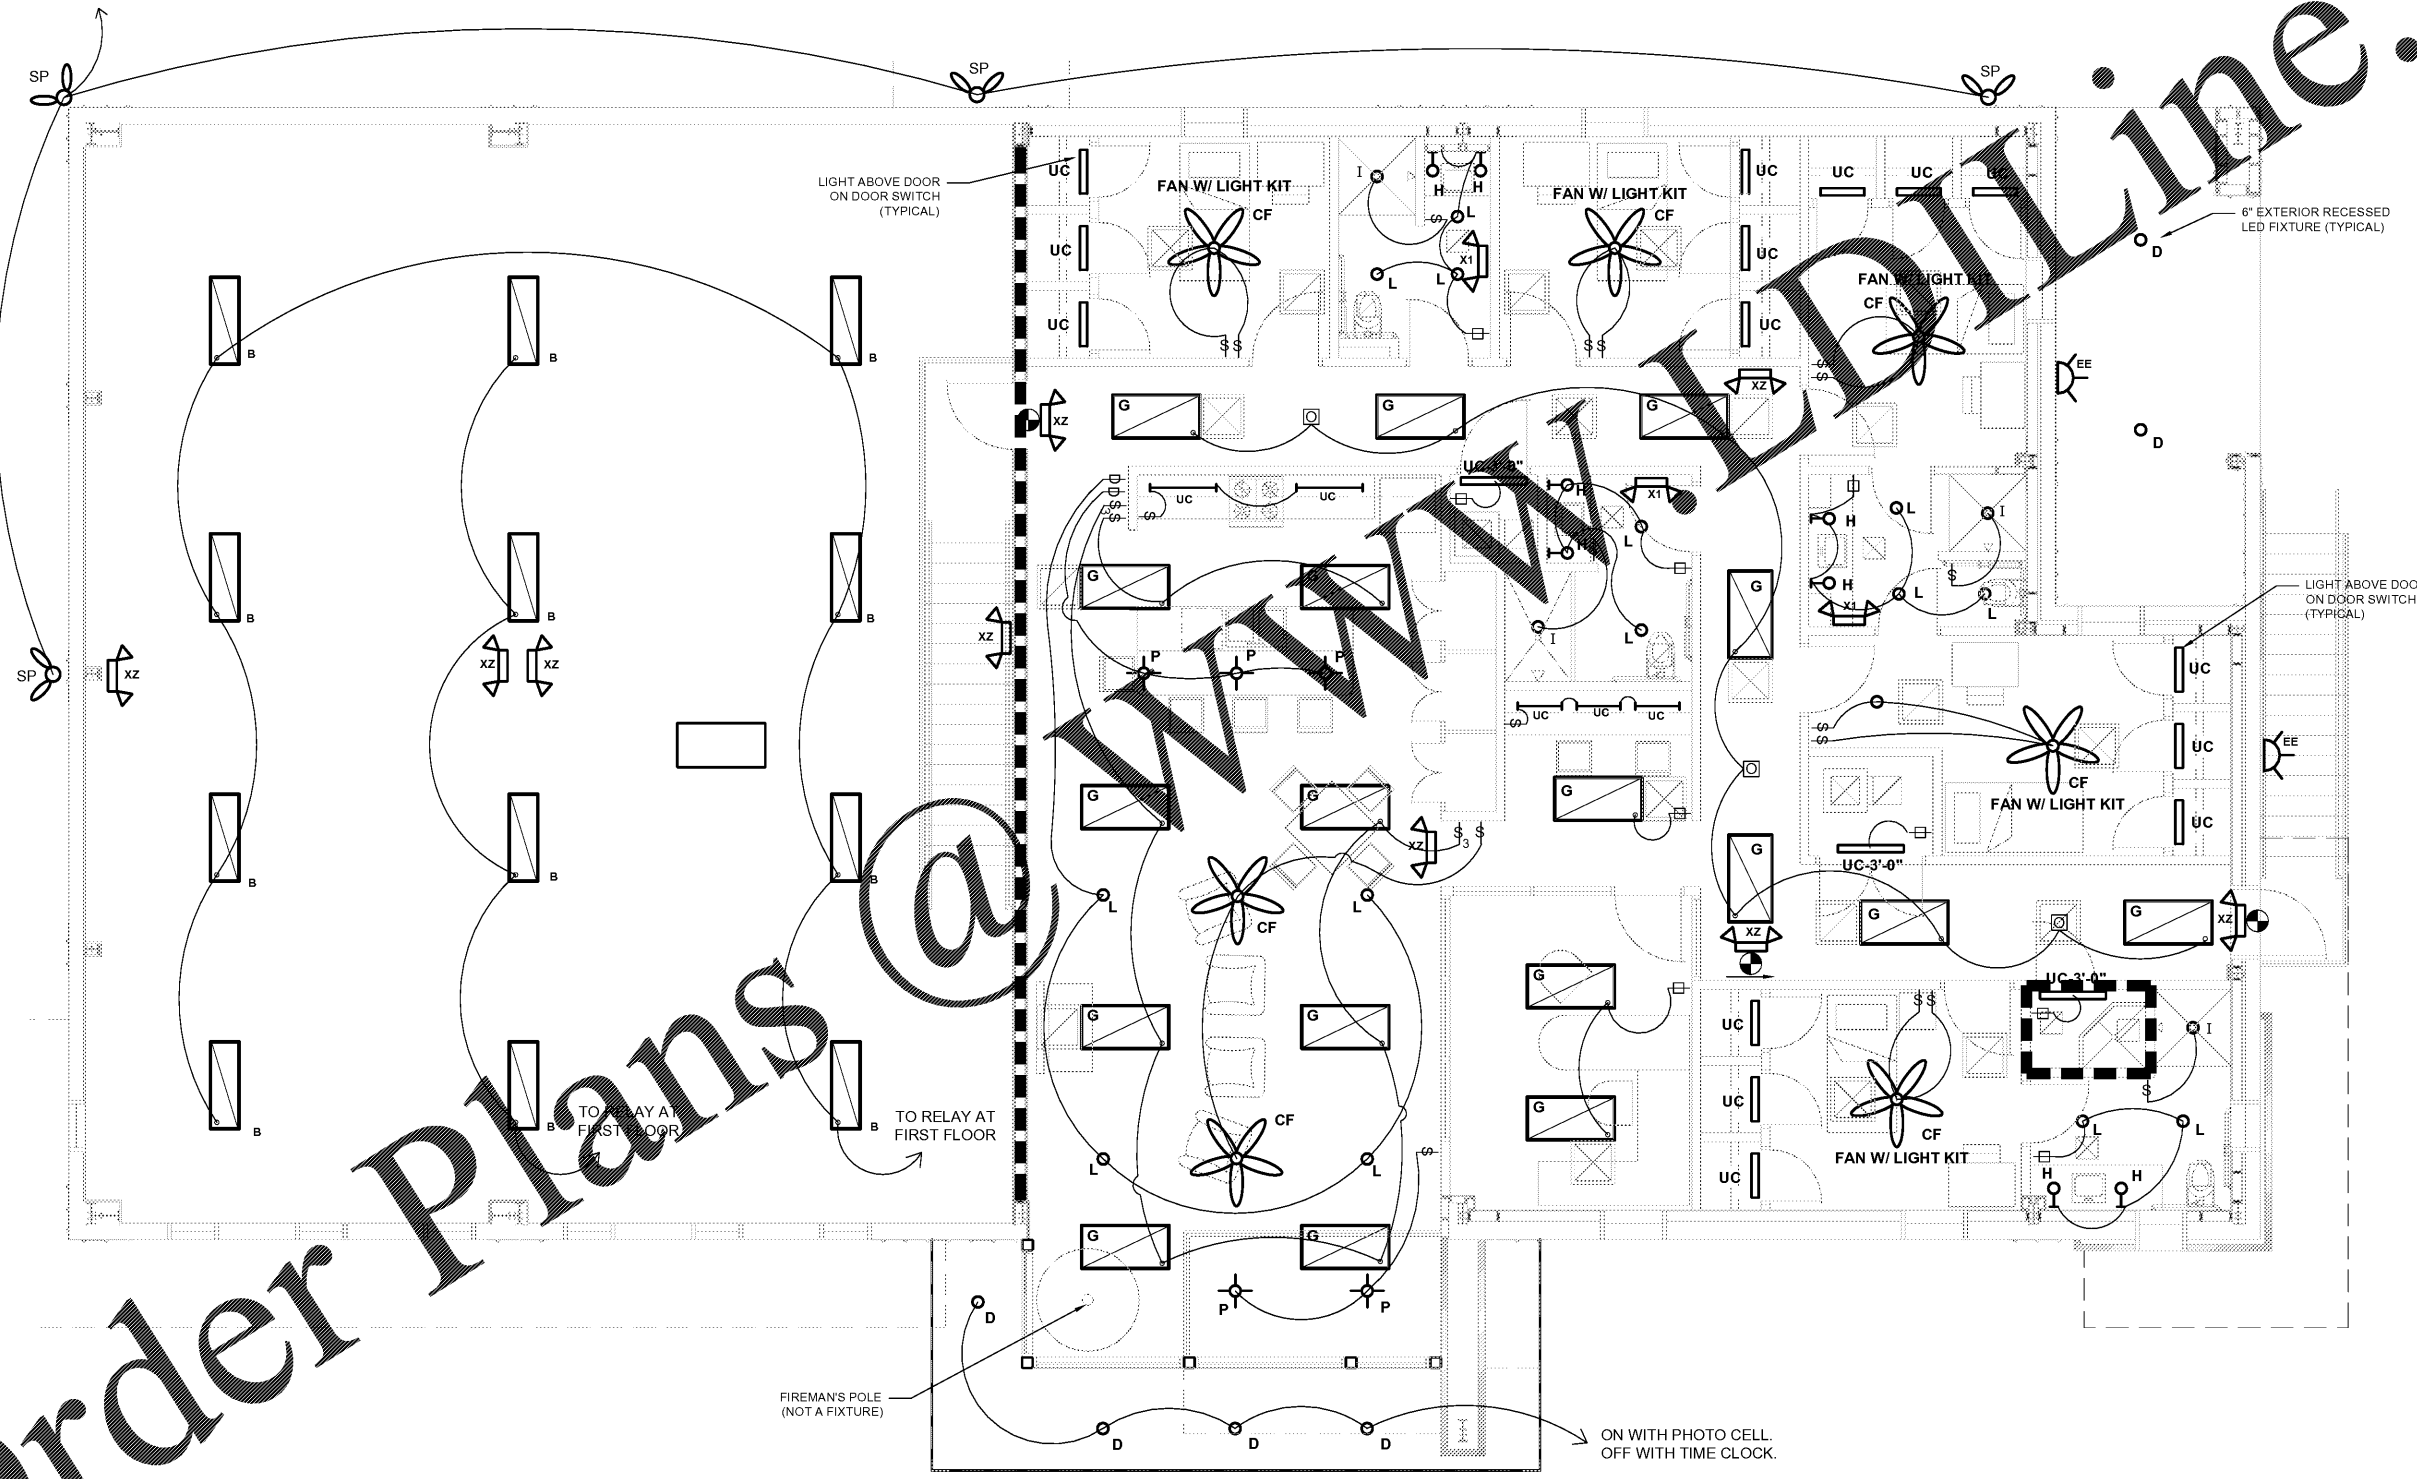

1 SECOND FLOOR ELECTRICAL LIGHTING PLAN
SCALE: 1/4" = 1'-0"



Order Plans @ www.orderplans.com