



SMITH DESIGN GROUP, INC.  
 20 WEST JACKSON STREET  
 LAGRANGE, GEORGIA 30240  
 706-882-5511 www.SDGarch.net

**LEGEND**

- CEILING FAN LIGHT COMBO
- DECORATIVE PENDANT HUNG FIXTURE
- WALL MOUNTED DECORATIVE LIGHT
- 2X4 LED LAY-IN FIXTURE
- 2X2 LED LAY-IN FIXTURE
- 1X4 LED CEILING MOUNTED FIXTURE
- 
- WALL SCONCE EACH SIDE OF MIRROR MOUNT AT 5'-6\"/>
- 
- 
- 
- 
- 
- RATED WALL - EXTEND TIGHT AGAINST FLOOR OR ROOF DECK ABOVE. SEAL ALL PENETRATIONS.


**REVISIONS**

DATE	DESCRIPTION


PROJECT:  
**VERNON ROAD FIRE STATION**  
 VERNON ROAD  
 LAGRANGE GEORGIA

TITLE:  
**SECOND FLOOR PLAN  
 ELECTRICAL LIGHTING  
 PLAN**

MODIFIED DATE:	JOB NO: <b>1731</b>
ISSUED DATE: FOR BID AND PERMIT <b>07 MAY 2018</b>	SHEET: <b>E-7</b>

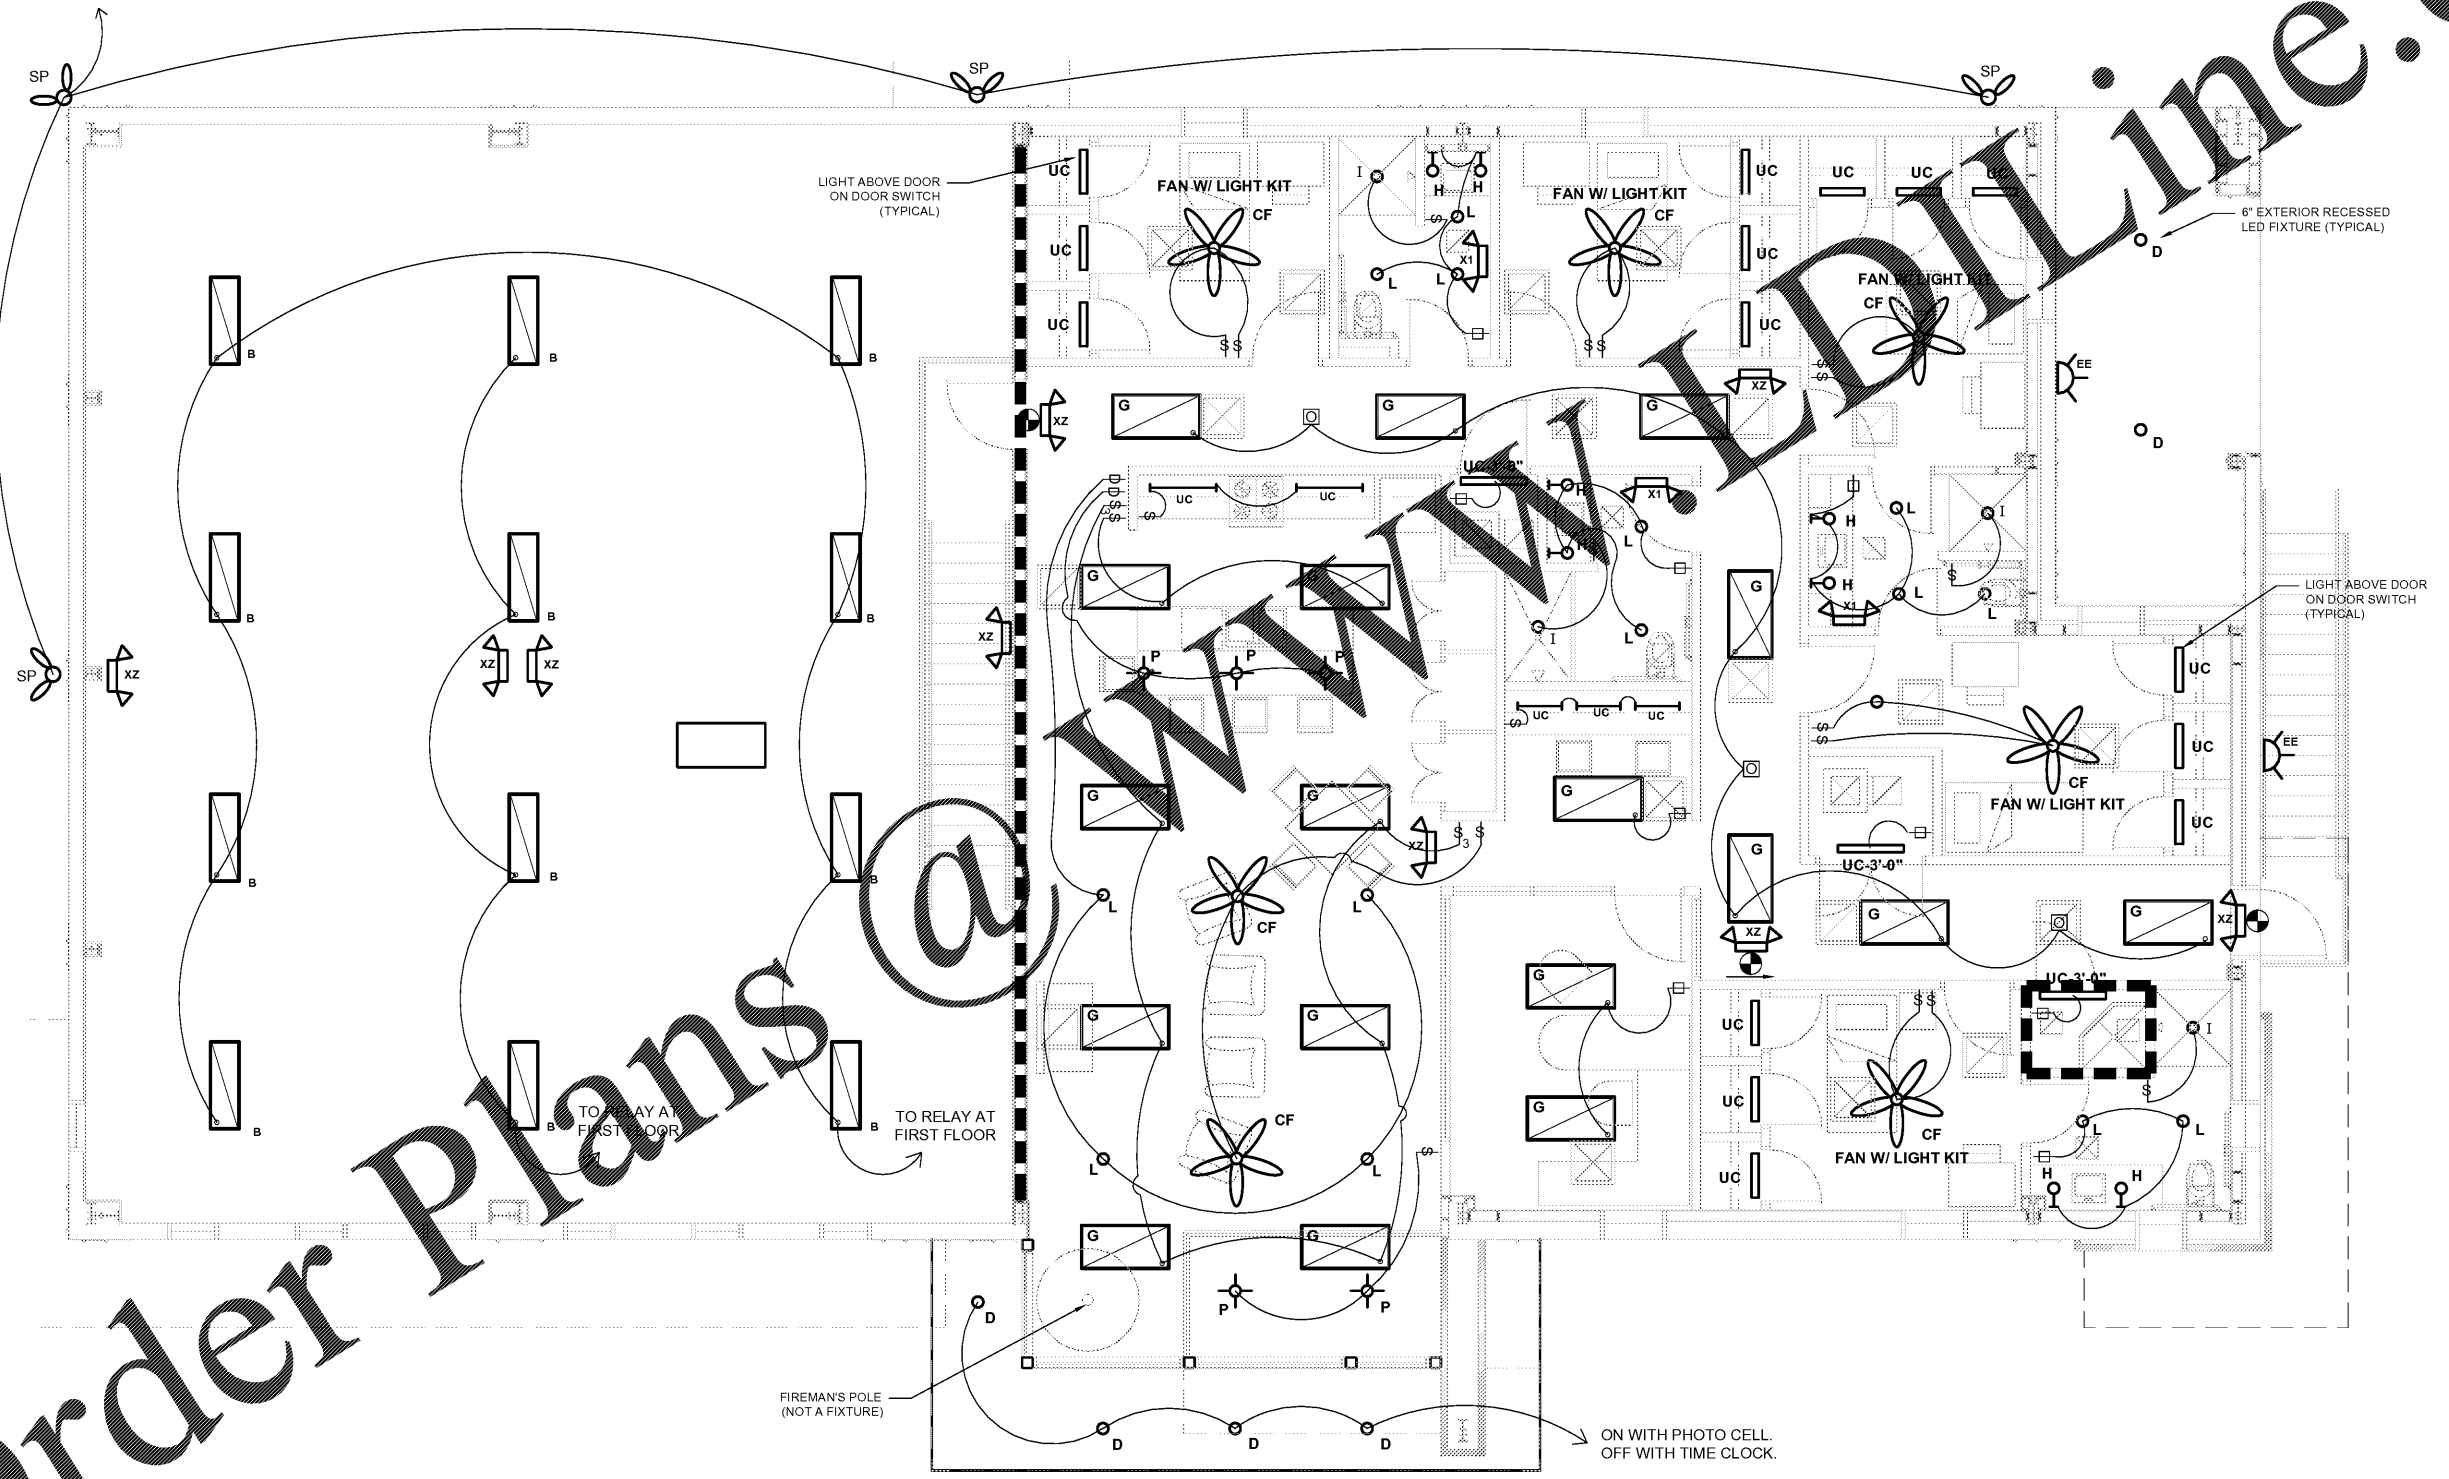

 **1 SECOND FLOOR ELECTRICAL LIGHTING PLAN**  
 SCALE: 1/4" = 1'-0"



Order Plans @ [www.wdwline.com](mailto:www.wdwline.com)