

ARCHITECT'S STAMP



SMITH DESIGN GROUP, INC.

206 WEST HAMILTON STREET
LAGRANGE, GEORGIA 30240
770-82-5511 www.SDGarch.net

LEGEND

- EXTERIOR WEATHERPROOF OUTLET
- 110V DUPLEX OUTLET
- 110V QUAD OUTLET
- VOICE / DATA DROP
- JUNCTION BOX FOR POWER
- POWER IN FLOOR (VERIFY WITH OWNER)
- WEATHERPROOF DISCONNECT
- EXHAUST FAN TO OUTSIDE
- CABLE TV OUTLET
- FLUSH MOUNTED SPEAKER (CEILING MOUNT) SEE REFLECTED CEILING PLAN.

--- RATED WALL - EXTEND TIGHT AGAINST FLOOR OR ROOF DECK ABOVE. SEAL ALL PENETRATIONS.


REVISIONS

DATE	DESCRIPTION

PROJECT:
VERNON ROAD FIRE STATION
VERNON ROAD
LAGRANGE GEORGIA

TITLE:
**ARCHITECTURAL
ELECTRICAL SYSTEM
FIRST FLOOR PLAN**

MODIFIED DATE:	JOB NO: 1731
ISSUED DATE: FOR BID AND PERMIT 07 MAY 2018	SHEET: E-8

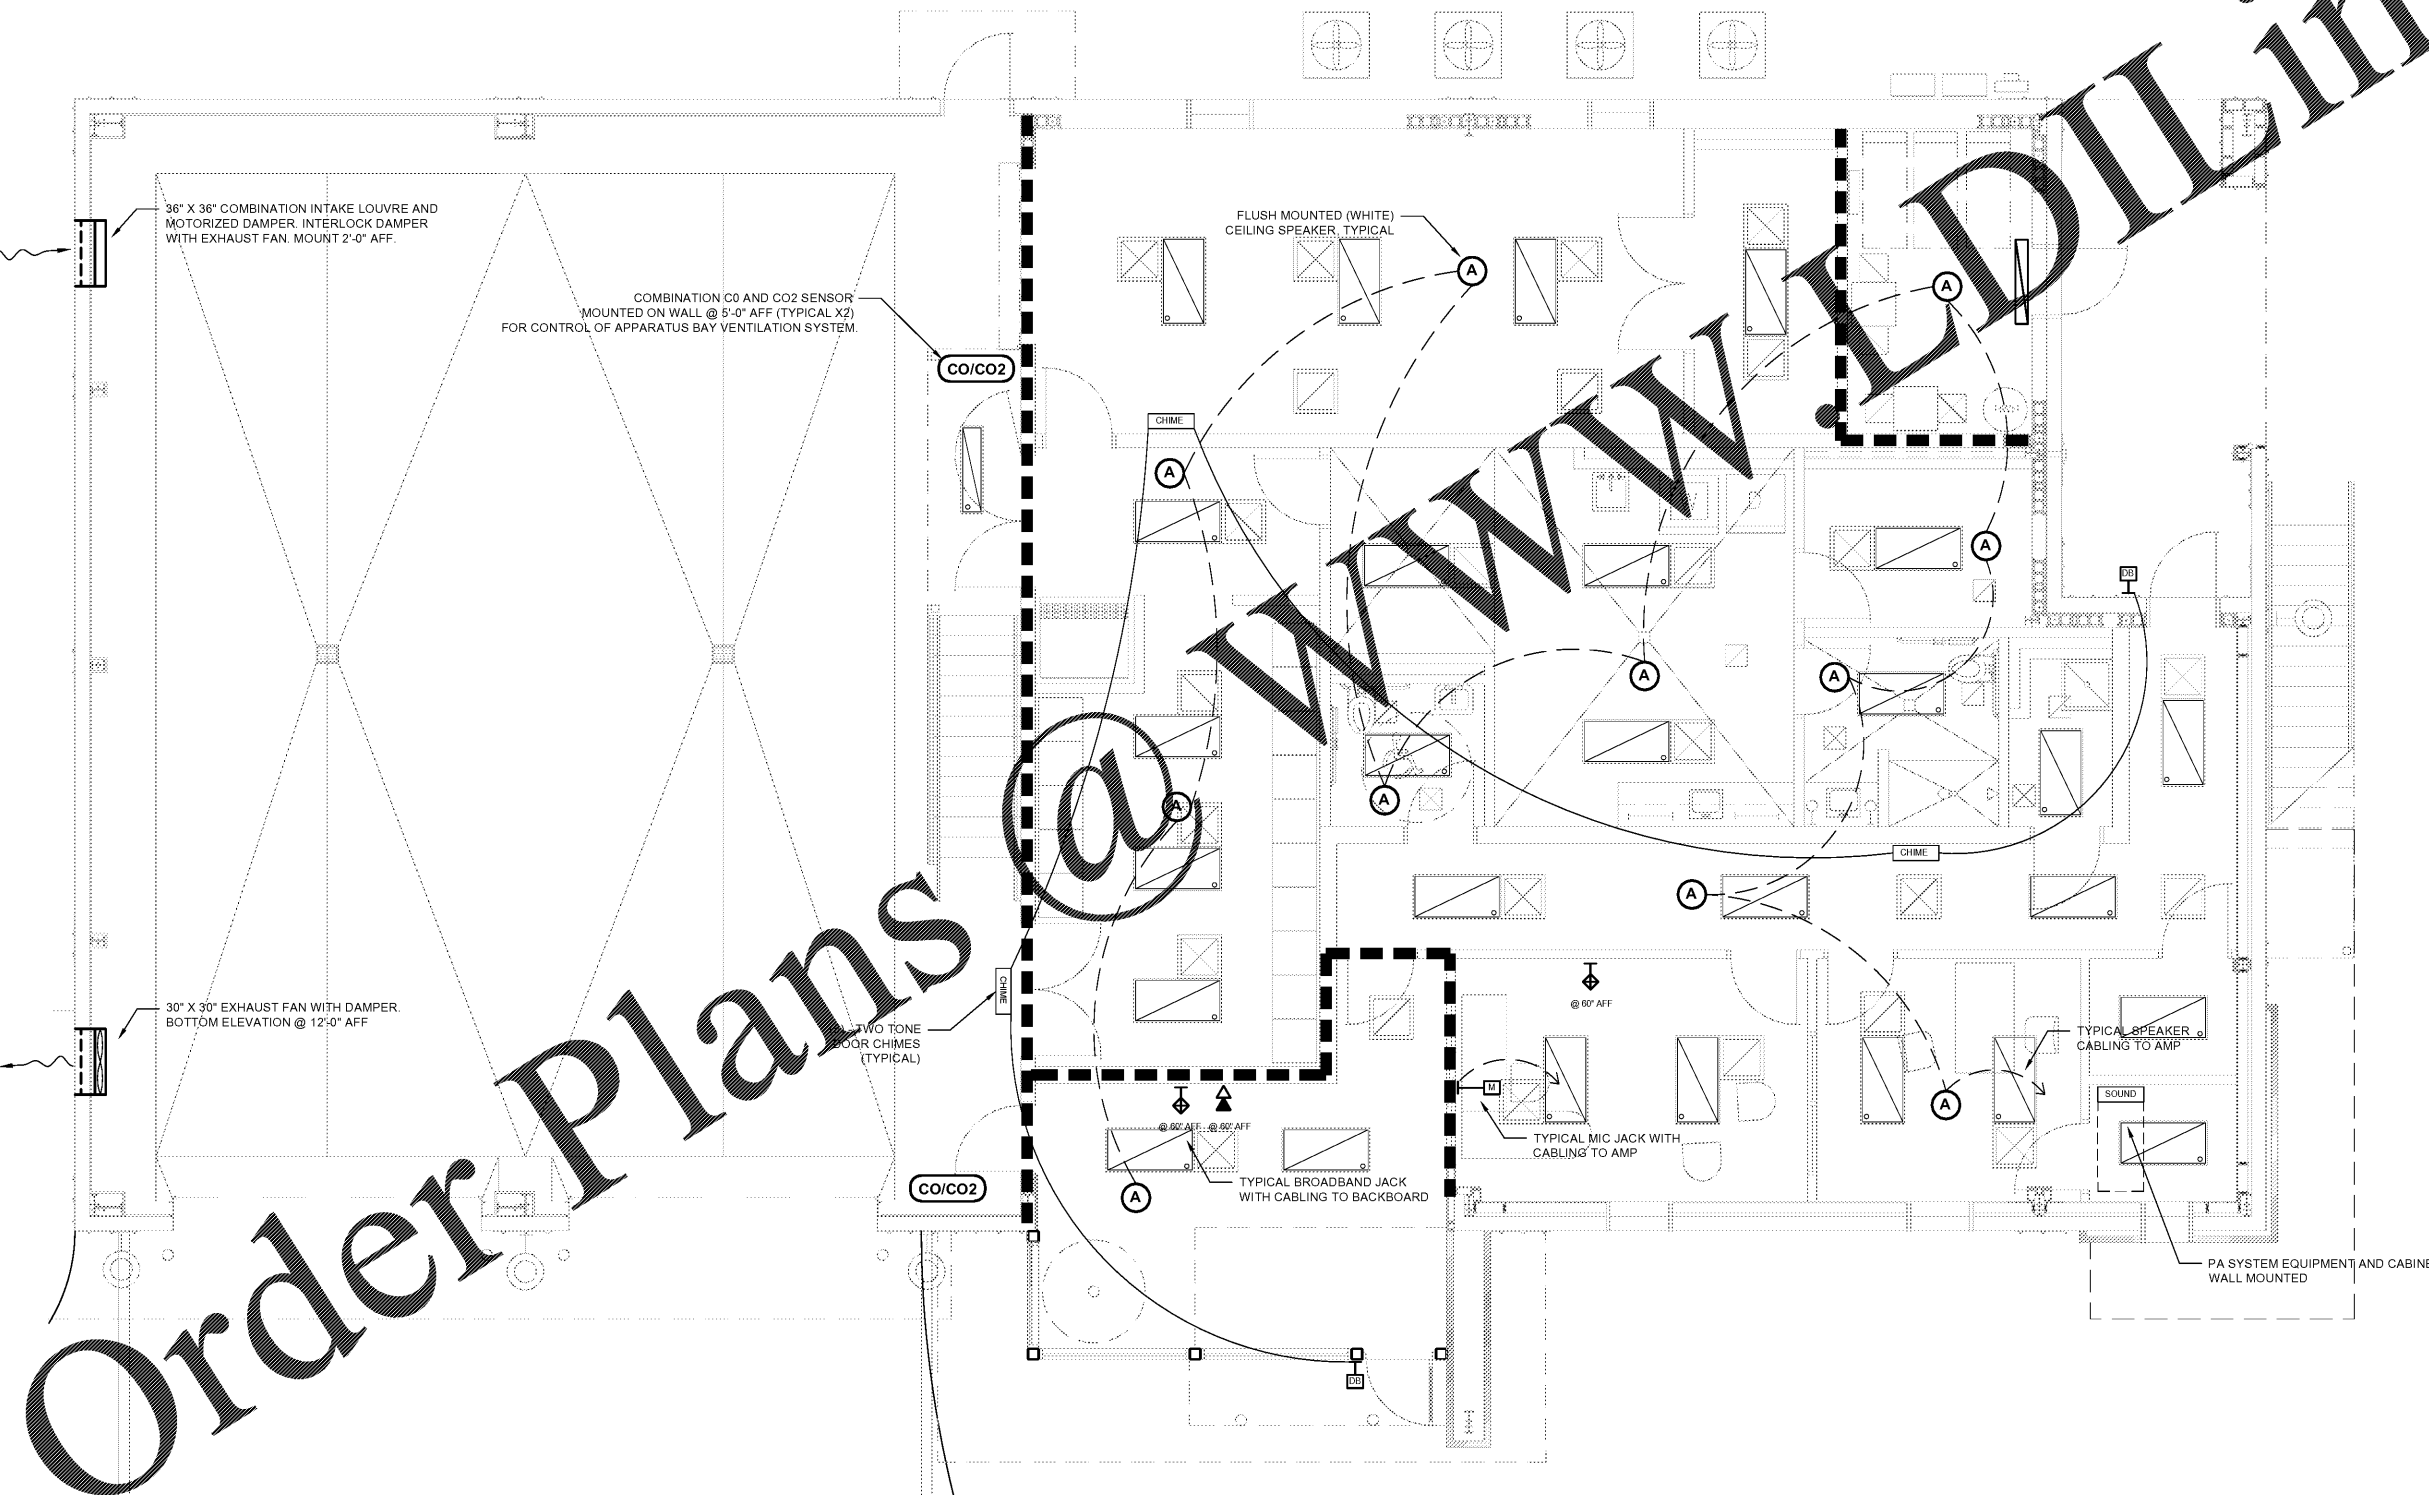

Order Plans @

1 FIRST FLOOR PLAN - ELECTRICAL SYSTEM
E-8 SCALE: 1/4" = 1'-0"