



SIGNATURE REQUIRED

SMITH DESIGN GROUP, INC.

20 WEST JACKSON STREET
 LAGRANGE, GEORGIA 30240
 706-882-5511 www.SDGarch.net

LEGEND

- CEILING FAN LIGHT COMBO
- DECORATIVE PENDANT HUNG FIXTURE
- WALL MOUNTED DECORATIVE LIGHT
- 2X4 LED LAY-IN FIXTURE
- 2X2 LED LAY-IN FIXTURE
- 1X4 LED CEILING MOUNTED FIXTURE
- 8'-0" HANGING LED
- WALL SCONCE EACH SIDE OF MIRROR MOUNT AT 5'-6" A.F.F. - SEE INTERIOR ELEVATIONS
- 4" RECESSED LED CANS ON DIMMER
- 4" RECESSED LED CANS
- 3' LONG UNDER CABINET LIGHTS
- 2'-0" OR 3'-0" WALL MOUNTED LIGHT IN CLOSET AREAS ABOVE DOOR
- 2'X2' LAY-IN CEILING AND GRID
- FLUSH MOUNTED SPEAKER (CEILING MOUNT) SEE REFLECTED CEILING PLAN.
- RATED WALL - EXTEND TIGHT AGAINST FLOOR OR ROOF DECK ABOVE. SEAL ALL PENETRATIONS.


REVISIONS

DATE	DESCRIPTION


PROJECT:
 VERNON ROAD FIRE STATION
 VERNON ROAD
 LAGRANGE GEORGIA

TITLE:
 SECOND FLOOR PLAN
 ELECTRICAL SYSTEMS
 PLAN

MODIFIED DATE:	JOB NO: 1731
ISSUED DATE: FOR BID AND PERMIT 07 MAY 2018	SHEET: AE-9

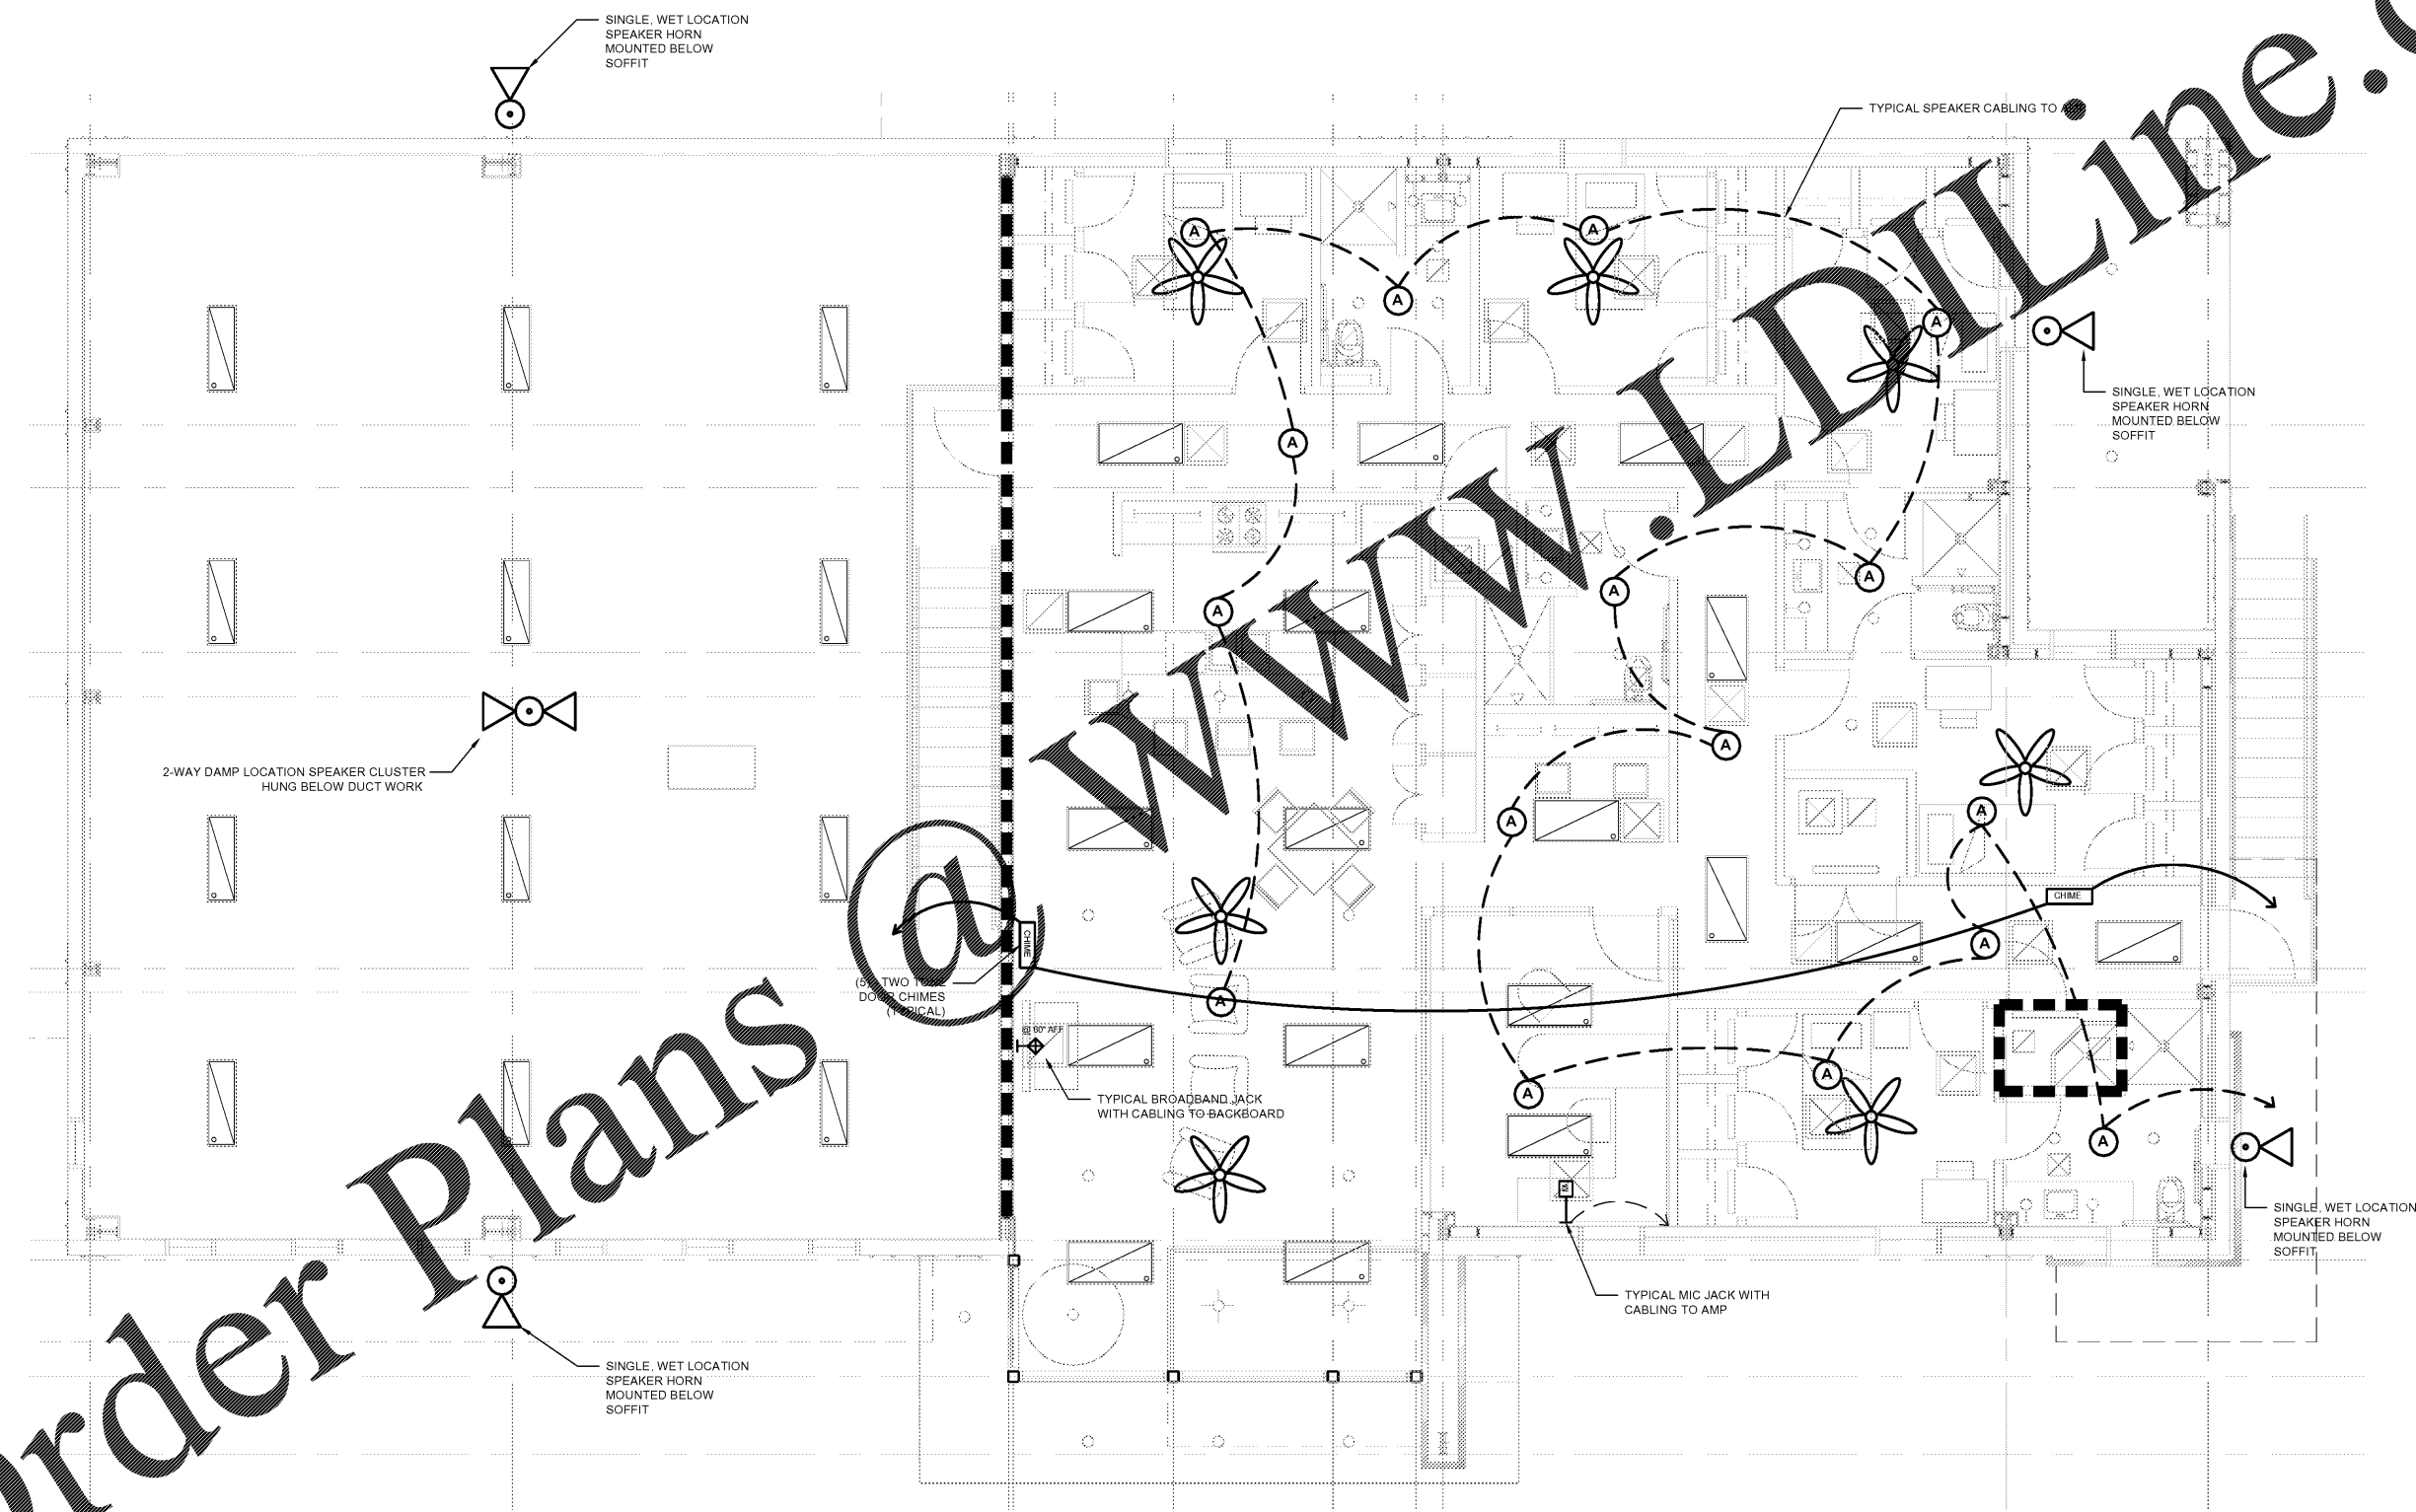

 1 SECOND FLOOR ELECTRICAL SYSTEMS PLAN
 AE-9 SCALE: 1/4" = 1'-0"



Order Plans