


SPECIALTY EQUIPMENT SCHEDULE			
ITEM	DESCRIPTION	MANUFACTURER # MODEL	QTY
BCS	RECESSED STAINLESS STEEL BABY CHANGING STATION	BRADLEY 562	3
GB-1	1-1/2" DIAMETER 36" LONG STAINLESS STEEL GRAB BARS WITH CONCEALED MOUNTING	BRADLEY 612-001-36-2	6
GB-2	1-1/2" DIAMETER 42" LONG STAINLESS STEEL GRAB BARS WITH CONCEALED MOUNTING	BRADLEY 612-001-42-2	10
GB-3	1-1/2" DIAMETER 24" LONG STAINLESS STEEL GRAB BARS WITH CONCEALED MOUNTING	BRADLEY 612-001-24-2	9
GB-4	1-1/2" DIAMETER 18" LONG STAINLESS STEEL GRAB BARS WITH CONCEALED MOUNTING	BRADLEY 612-001-18-2	1
HD	DYSON AIRBLADE HAND DRYER (GREY)	DYSON AB14	4
M-1	SURFACE MOUNTED LAV DECK MIRROR WITH WOOD FRAME - W18" x H42"	BRADLEY 747-01-8420	5
M-2	STAINLESS STEEL CHANNEL FRAME FULL LENGTH MIRROR W 24" x H 60"	BRADLEY 781-2436	3
M-3	STAINLESS STEEL CHANNEL FRAME FAMILY PK MIRROR W 24" x H 36"	BRADLEY 781-2436	3
M-4	STAINLESS STEEL CHANNEL FRAME CHILD'S HEIGHT MIRROR W 18" x H 24"	BRADLEY 781-1824	1
M-5	SURFACE MOUNTED LAV DECK MIRROR WITH WOOD FRAME - W60" x H42"	BRADLEY 747-02-8420	1
NTD	SURFACE MOUNTED FEMININE NAPKIN DISPOSAL	BRADLEY 4722-15	13
NTV	SEMI-RECESSED FEMININE NAPKIN/TAMPON VENDOR, STAINLESS STEEL	BRADLEY 4517	1
PTD	SEMI-RECESSED PAPER TOWEL DISPENSER AND WASTE RECEPTACLE	BRADLEY 2425-1036	3
SC	SURFACE MOUNTED SEAT COVER DISPENSER	BRADLEY 5831	17
SD	LAVATORY MOUNTED SOAP DISPENSER	GOJID 8520-D1	8
SD-2	SURFACE MOUNTED SOAP DISPENSER	BRADLEY 6362	4
TFD	SURFACE MOUNTED TOILET TISSUE DISPENSER - DUAL JUMBO ROLL	BRADLEY 5425	18
TFD-2	SURFACE MOUNTED TOILET TISSUE DISPENSER - SINGLE JUMBO ROLL	BRADLEY 5424	1

1. SEE DIMENSION AND REFERENCE FLOOR PLANS FOR ADDITIONAL NOTES AND DIMENSIONS.
 2. ACCESSIBLE AND AMBULATORY TOILET PARTITION DOORS MUST BE 7' USE STAINLESS STEEL ACCESS PANELS FOR ALL PLUMBING FIXTURES 1.1. INSTALL SEALANT IN JOINT BETWEEN CUT WALL TILE EDGE AND SELF CLOSING RECESSED RESTROOM ACCESSORY UNITS.
 3. ANY NEW CONTROLS FOR WATER CLOSETS AND LAVATORIES SHALL BE 4500S. BE ON THE FIXTURES ACCESSIBLE (WIDE) SIDE.
 4. DOORS TO HANDICAPPED TOILETS SHALL HAVE A MINIMUM 3/4" CLEAR WIDTH.
 5. WRAP ALL EXPOSED PIPES WITH INSULATION UNDER LAVATORY COUNTERS, TYP.
6. PROVIDE ALL NEW HARDWARE AND TRIM FOR NEW RESTROOM PARTITIONS. NEW PARTITIONS TO BE OVERHEAD AND WALL BRACED.
 7. USE STAINLESS STEEL ACCESS PANELS FOR ALL PLUMBING FIXTURES 1.1. INSTALL SEALANT IN JOINT BETWEEN CUT WALL TILE EDGE AND RECESSED RESTROOM ACCESSORY UNITS.
 8. PATCH AND REPAIR ALL SURFACES WHERE TILE WAS REMOVED TO RECEIVE NEW TILE. SLOPE FLOORS TOWARD DRAIN.
10. PROVIDE BLOCKING AS REQUIRED FOR MOUNTING OF ALL TOILET ACCESSORIES.
 11. COORDINATE ELECTRICAL FLUSH VALVE SENSOR LOCATIONS PER MANUFACTURERS REQUIREMENTS.
 12. COORDINATE HANGAR CLEARANCE WITH TOILET COMPARTMENT ACCESSORIES IN ACCESSIBLE STALLS.
 14. RE. PLUMBING FOR NEW FAUCET AND SINK SPECS.

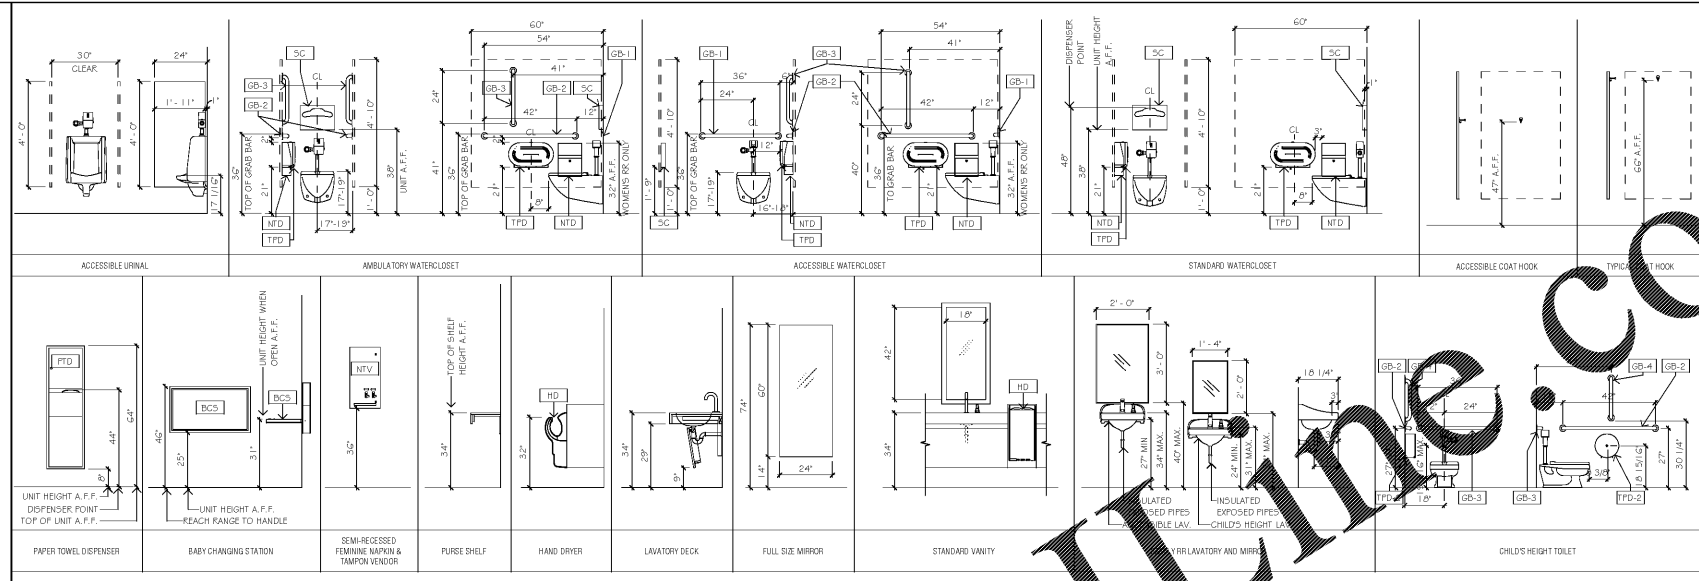


P1 EQUIPMENT SCHEDULE


P8 RESTROOM FIXTURE NOTES




SHEET LEGEND	
GEN	GENERAL INFORMATION & SCHEDULES
MECH	Mechanical
PL	PLUMBING
EL	ELECTRICAL
STR	STRUCTURAL
INT	INTERIOR
EXT	EXTERIOR
FIN	FINISHES
EQ	EQUIPMENT

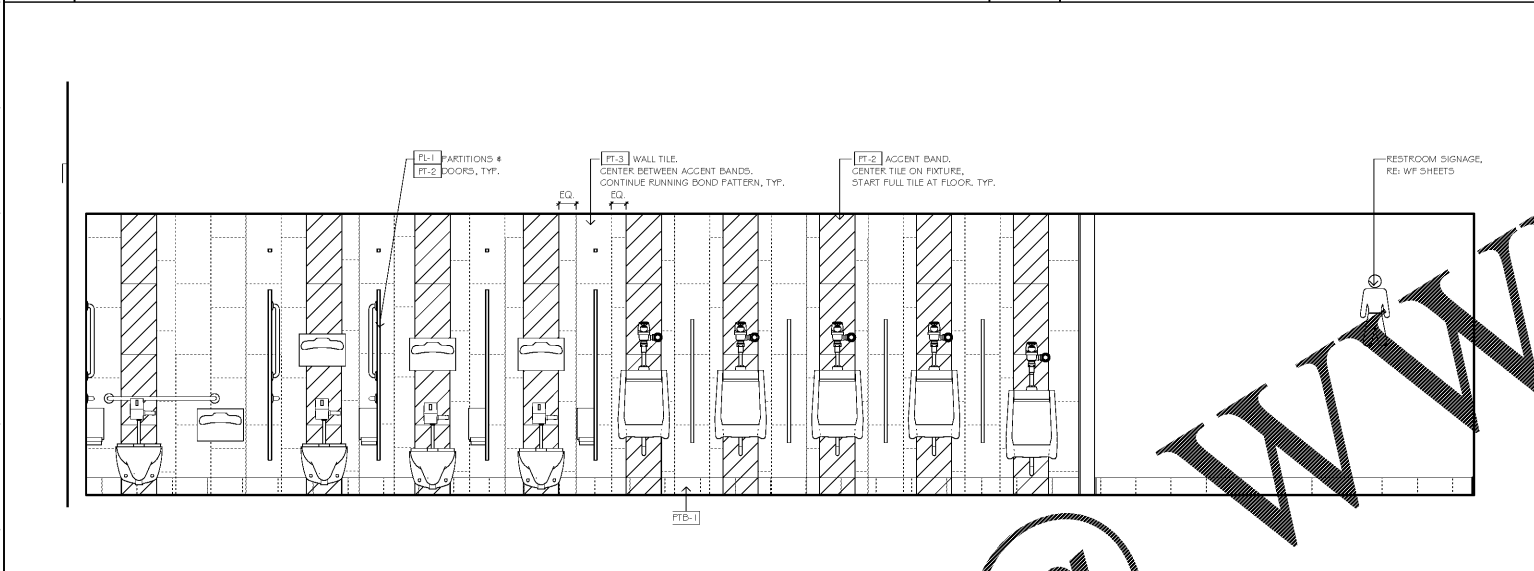


H1 RESTROOM ELEVATION - MENS

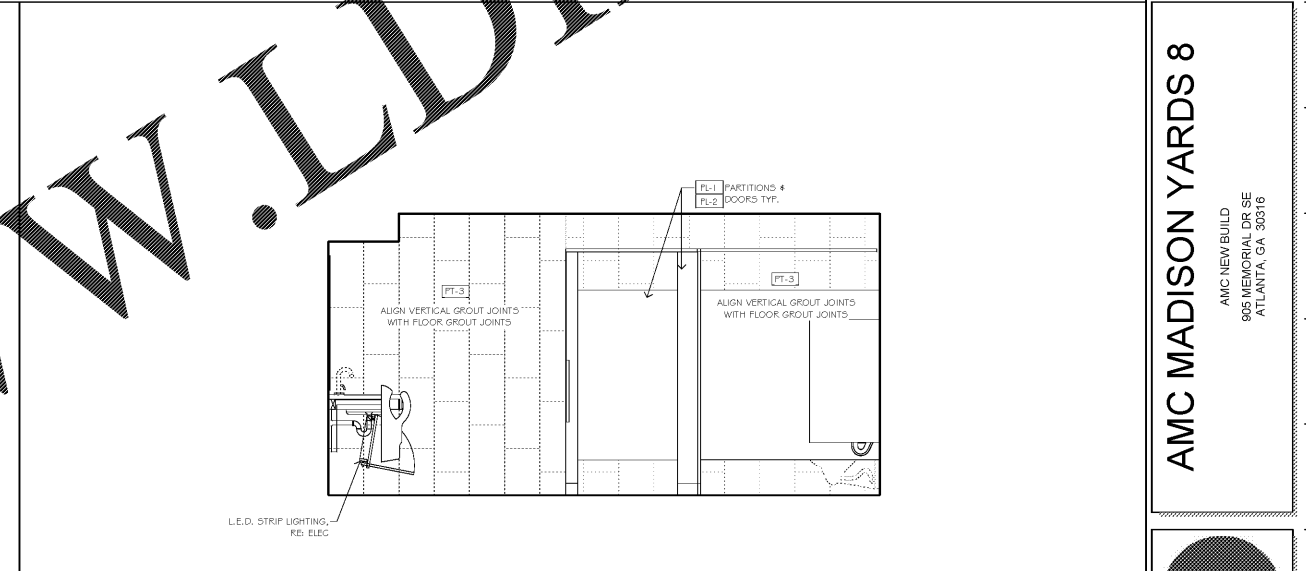

H12 RESTROOM ELEVATION - MENS

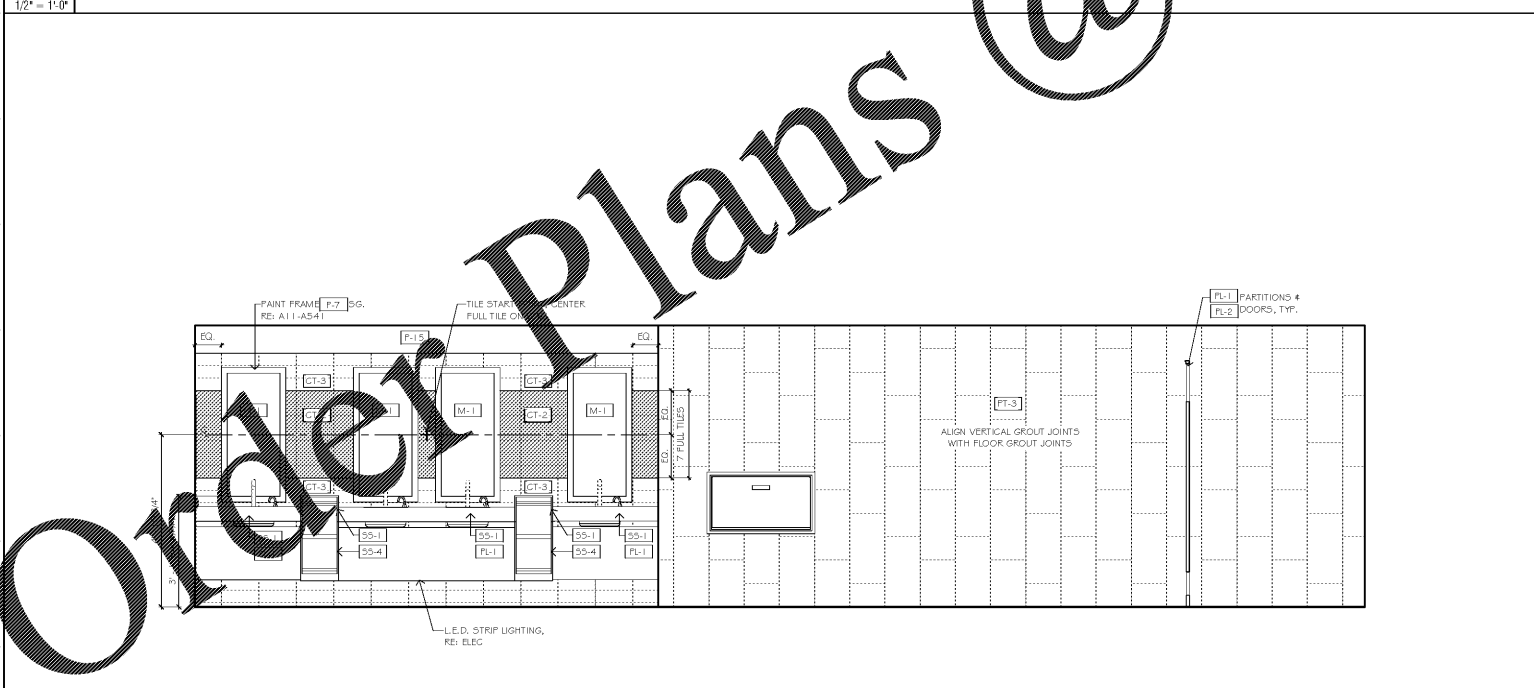

A1 RESTROOM ELEVATION - MENS

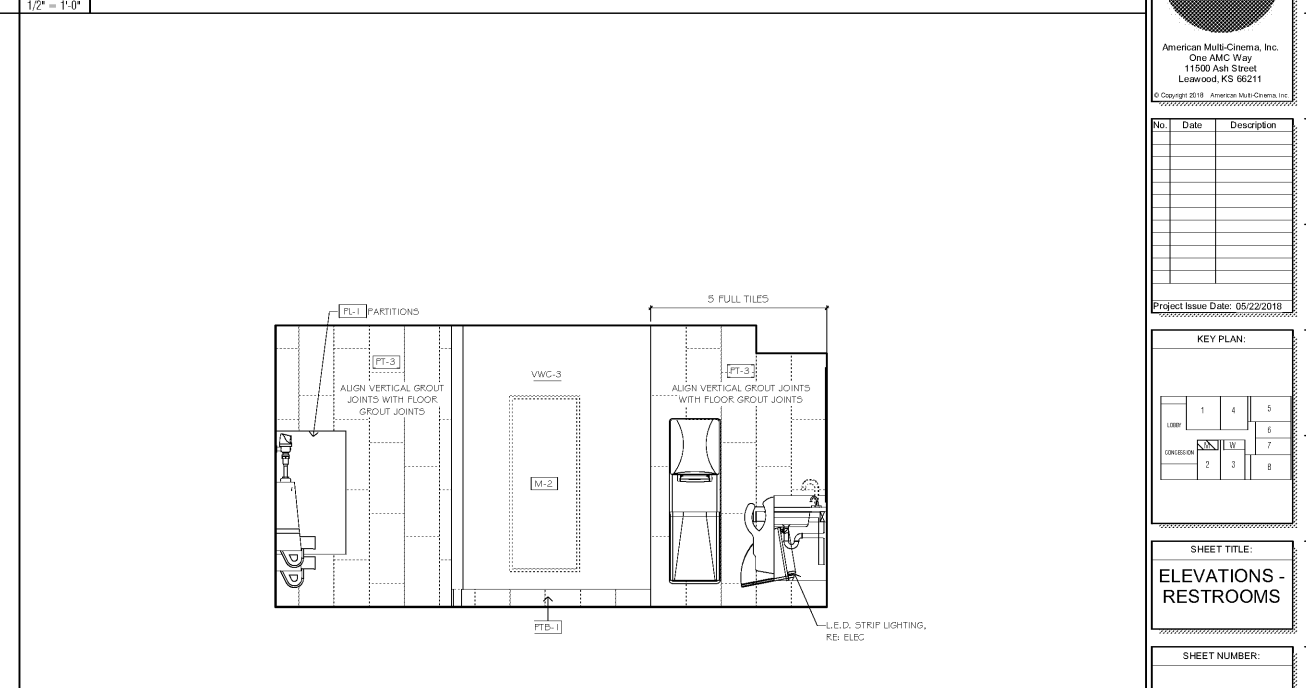

A12 RESTROOM ELEVATION - MENS

AMC MADISON YARDS 8
 AMC NEW BUILD
 906 MEMORIAL DR SE
 ATLANTA, GA 30316



No.	Date	Description

KEY PLAN:	
1	4
2	5
3	6
4	7
5	8

SHEET TITLE:
ELEVATIONS - RESTROOMS

SHEET NUMBER:
A220

Order Plans @ www.lddline.com