


SPECIALTY EQUIPMENT SCHEDULE			
ITEM	DESCRIPTION	MANUFACTURER # MODEL	QTY
BCS	RECESSED STAINLESS STEEL BABY CHANGING STATION	BRADLEY 562	3
GB-1	1-1/2" DIAMETER 36" LONG STAINLESS STEEL GRAB BARS WITH CONCEALED MOUNTING	BRADLEY 612-001-36-2	6
GB-2	1-1/2" DIAMETER 42" LONG STAINLESS STEEL GRAB BARS WITH CONCEALED MOUNTING	BRADLEY 612-001-42-2	10
GB-3	1-1/2" DIAMETER 24" LONG STAINLESS STEEL GRAB BARS WITH CONCEALED MOUNTING	BRADLEY 612-001-24-2	9
GB-4	1-1/2" DIAMETER 18" LONG STAINLESS STEEL GRAB BARS WITH CONCEALED MOUNTING	BRADLEY 612-001-18-2	1
HD	DYSON AIRBLADE HAND DRYER (GREY)	DYSON AB14	4
M-1	SURFACE MOUNTED LAV DECK MIRROR WITH WOOD FRAME - W18" x H42"	BRADLEY 747-01-6420	5
M-2	STAINLESS STEEL CHANNEL FRAME FULL LENGTH MIRROR W 24" x H 60"	BRADLEY 761-2436	3
M-3	STAINLESS STEEL CHANNEL FRAME FAMILY PK MIRROR W 24" x H 36"	BRADLEY 761-2436	3
M-4	STAINLESS STEEL CHANNEL FRAME CHILD'S HEIGHT MIRROR W 18" x H 24"	BRADLEY 761-1824	1
M-5	SURFACE MOUNTED LAV DECK MIRROR WITH WOOD FRAME - W60" x H42"	BRADLEY 747-02-6420	1
NTD	SURFACE MOUNTED FEMININE NAPKIN DISPOSAL	BRADLEY 4722-15	13
NTV	SEMI-RECESSED FEMININE NAPKIN/TAMPON VENDOR, STAINLESS STEEL	BRADLEY 4217	1
PTD	SEMI-RECESSED PAPER TOWEL DISPENSER AND WASTE RECEPTACLE	BRADLEY 2425-1036	3
SC	SURFACE MOUNTED SEAT COVER DISPENSER	BRADLEY 5631	17
SD	LAVATORY MOUNTED SOAP DISPENSER	GOJID 8520-D1	8
SD-2	SURFACE MOUNTED SOAP DISPENSER	BRADLEY 6362	4
TFD	SURFACE MOUNTED TOILET TISSUE DISPENSER - DUAL JUMBO ROLL	BRADLEY 5425	18
TFD-2	SURFACE MOUNTED TOILET TISSUE DISPENSER - SINGLE JUMBO ROLL	BRADLEY 5424	1

- SEE DIMENSION AND REFERENCE FLOOR PLANS FOR ADDITIONAL NOTES AND DIMENSIONS.
- ACCESSIBLE AND AMBULATORY TOILET PARTITION DOORS MUST BE SELF-CLOSING.
- ANY NEW CONTROLS FOR WATER CLOSETS AND LAVATORIES SHALL BE ON THE FIXTURES ACCESSIBLE (WIDE) SIDE.
- DOORS TO HANDICAPPED TOILETS SHALL HAVE A MINIMUM 34" CLEAR WIDTH.
- WRAP ALL EXPOSED PIPES WITH INSULATION UNDER LAVATORY COUNTERS, TYP.
- PROVIDE ALL NEW HARDWARE AND TRIM FOR NEW RESTROOM PARTITIONS. NEW PARTITIONS TO BE OVERHEAD AND WALL BRACED.
- USE STAINLESS STEEL ACCESS PANELS FOR ALL PLUMBING FIXTURES RECESSED RESTROOM ACCESSORY UNITS.
- COORDINATE ELECTRICAL FLUSH VALVE SENSOR LOCATIONS PER MANUFACTURERS REQUIREMENTS.
- COORDINATE HANDRAIL CLEARANCE WITH TOILET COMPARTMENT ACCESSORIES IN ACCESSIBLE STALLS.
- RE: PLUMBING FOR NEW FAUCET AND SINK SPECS.
- PROVIDE BLOCKING AS REQUIRED FOR MOUNTING OF ALL TOILET ACCESSORIES.
- INSTALL SEALANT IN JOINT BETWEEN CUT WALL TILE EDGE AND RECESSED RESTROOM ACCESSORY UNITS.
- COORDINATE ELECTRICAL FLUSH VALVE SENSOR LOCATIONS PER MANUFACTURERS REQUIREMENTS.
- COORDINATE HANDRAIL CLEARANCE WITH TOILET COMPARTMENT ACCESSORIES IN ACCESSIBLE STALLS.
- RE: PLUMBING FOR NEW FAUCET AND SINK SPECS.

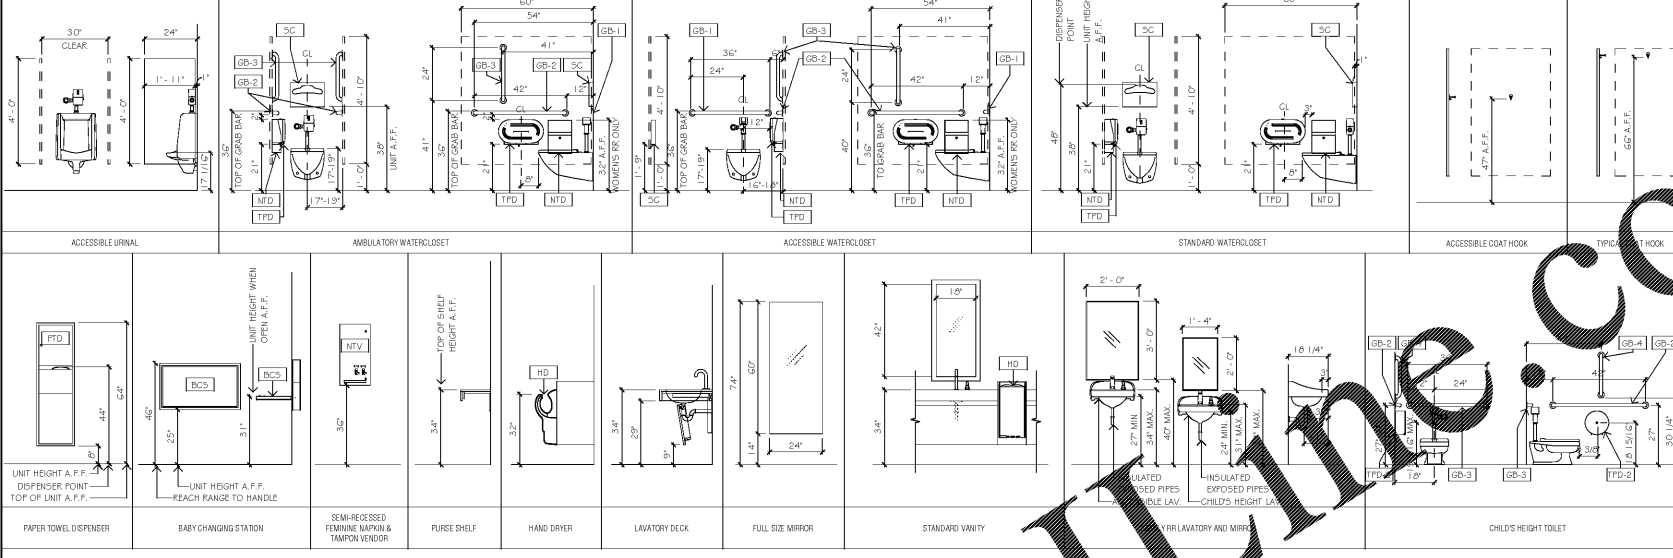


P1 EQUIPMENT SCHEDULE

P8 RESTROOM FIXTURE NOTES


STATE OF GEORGIA
 REGISTERED PROFESSIONAL ARCHITECT
 LICENSE NO. 18188
 L. L. KEENE, AIA
 14 West 3rd Street, Suite 102
 Atlanta, GA 30333
 (404) 525-1237
 (404) 525-1231

SHEET LEGEND
 GENERAL INFORMATION & SCHEDULES
 ARCHITECTURE & INTERIOR ELEVATIONS
 BUILDING SECTIONS
 EXTERIOR & INTERIOR DETAILS
 FLOOR SCHEDULES, SCHEDULES
 MECHANICAL, ELECTRICAL, PLUMBING
 STRUCTURAL
 FINISHES
 SCHEDULES & EQUIPMENT
 AUDITORIUM

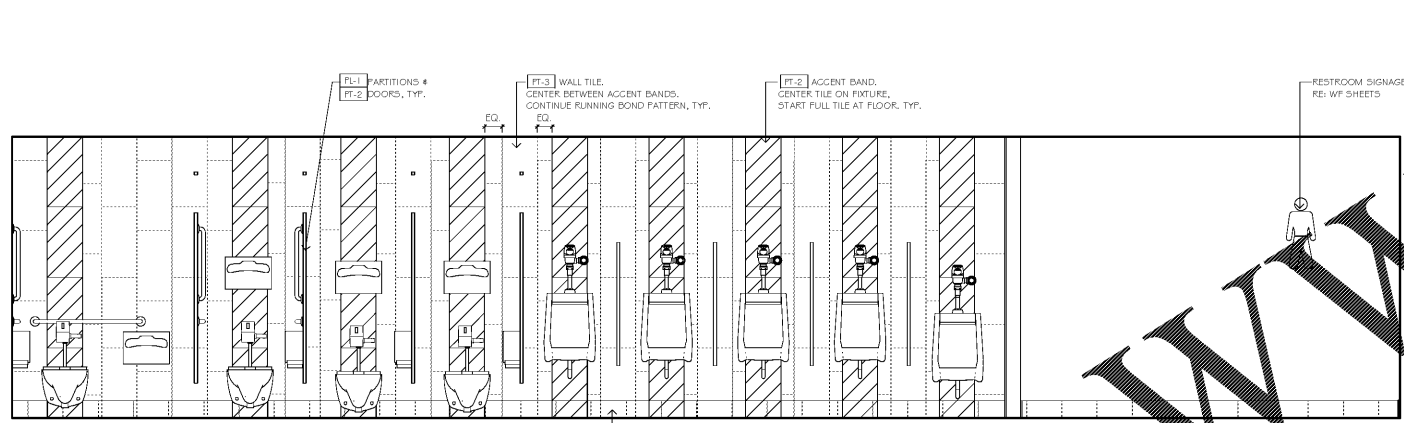


H1 RESTROOM ELEVATION - MENS

1/2" = 1'-0"

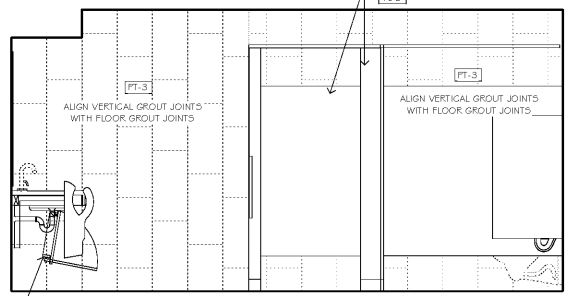


H12 RESTROOM ELEVATION - MENS

1/2" = 1'-0"

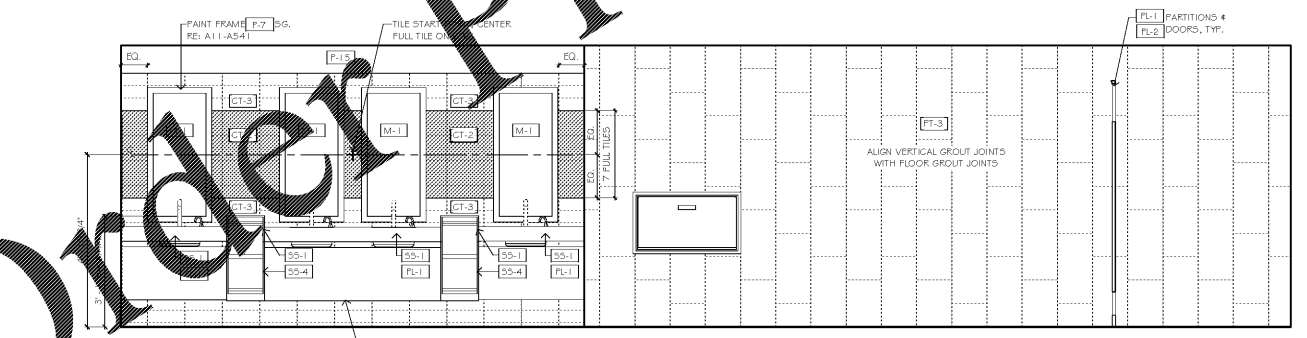

A1 RESTROOM ELEVATION - MENS

1/2" = 1'-0"

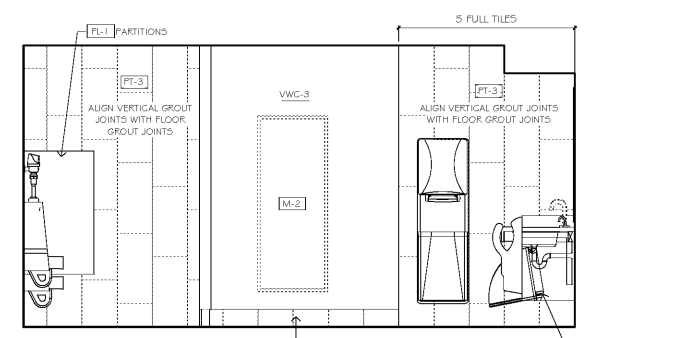

A12 RESTROOM ELEVATION - MENS

1/2" = 1'-0"

AMC MADISON YARDS 8
 AMC NEW BUILD
 905 MEMORIAL DR SE
 ATLANTA, GA 30316

amc
 American Multi-Cinema, Inc.
 One AMC Way
 11500 Ash Street
 Lenexa, KS 66211
 © Copyright 2018 American Multi-Cinema, Inc.

No.	Date	Description

Project Issue Date: 05/22/2018

KEY PLAN:

1	4	5
2	6	7
3	8	

SHEET TITLE:
 ELEVATIONS - RESTROOMS

SHEET NUMBER:
 A220

Order Plans @ WWW.LDMLINE.COM