


SPECIALTY EQUIPMENT SCHEDULE			
ITEM	DESCRIPTION	MANUFACTURER & MODEL	QTY
BC3	RECESSED STAINLESS STEEL BABY CHANGING STATION	BRADLEY 362	3
GB-1	1-1/2" DIAMETER 36" LONG STAINLESS STEEL GRAB BARS WITH CONCEALED MOUNTING	BRADLEY 812-001-36-2	6
GB-2	1-1/2" DIAMETER 42" LONG STAINLESS STEEL GRAB BARS WITH CONCEALED MOUNTING	BRADLEY 812-001-42-2	10
GB-3	1-1/2" DIAMETER 24" LONG STAINLESS STEEL GRAB BARS WITH CONCEALED MOUNTING	BRADLEY 812-001-24-2	9
GB-4	1-1/2" DIAMETER 18" LONG STAINLESS STEEL GRAB BARS WITH CONCEALED MOUNTING	BRADLEY 812-001-18-2	1
HD	DYSON AIRBLADE HAND DRYER (GREY)	DYSON AB14	4
M-1	SURFACE MOUNTED LAV DECK MIRROR WITH WOOD FRAME - W18" x H42"	BRADLEY 747-01-8420	5
M-2	STAINLESS STEEL CHANNEL FRAME FULL LENGTH MIRROR W 24" x H 60"	BRADLEY 781-2436	3
M-3	STAINLESS STEEL CHANNEL FRAME FAMILY PK MIRROR W 24" x H 36"	BRADLEY 781-2436	3
M-4	STAINLESS STEEL CHANNEL FRAME CHILD'S HEIGHT MIRROR W 18" x H 24"	BRADLEY 781-1824	1
M-5	SURFACE MOUNTED LAV DECK MIRROR WITH WOOD FRAME - W60" x H42"	BRADLEY 747-02-8420	1
NTD	SURFACE MOUNTED FEMININE NAPKIN DISPOSAL	BRADLEY 4722-15	13
NTV	SEMI-RECESSED FEMININE NAPKIN/TAMPON VENDOR, STAINLESS STEEL	BRADLEY 5831	1
PTD	SEMI-RECESSED PAPER TOWEL DISPENSER AND WASTE RECEPTACLE	BRADLEY 2425-1036	3
SC	SURFACE MOUNTED SEAT COVER DISPENSER	BRADLEY 5831	17
SD	LAVATORY MOUNTED SOAP DISPENSER	GOJO 8520-01	8
SD-2	SURFACE MOUNTED SOAP DISPENSER	BRADLEY 6362	4
TFD	SURFACE MOUNTED TOILET TISSUE DISPENSER - DUAL JUMBO ROLL	BRADLEY 5425	18
TFD-2	SURFACE MOUNTED TOILET TISSUE DISPENSER - SINGLE JUMBO ROLL	BRADLEY 5424	1

- SEE DIMENSION AND REFERENCE FLOOR PLANS FOR ADDITIONAL NOTES AND DIMENSIONS.
- ACCESSIBLE AND AMBULATORY TOILET PARTITION DOORS MUST BE SELF-CLOSING.
- ANY NEW CONTROLS FOR WATER CLOSETS AND LAVATORIES SHALL BE ON THE FIXTURES ACCESSIBLE (WIDE) SIDE.
- DOORS TO HANDICAPPED TOILETS SHALL HAVE A MINIMUM 34" CLEAR WIDTH.
- WRAP ALL EXPOSED PIPES WITH INSULATION UNDER LAVATORY COUNTERTOPS, TYP.
- PROVIDE ALL NEW HARDWARE AND TRIM FOR NEW RESTROOM PARTITIONS. NEW PARTITIONS TO BE OVERHEAD AND WALL BRACED.
- USE STAINLESS STEEL ACCESS PANELS FOR ALL PLUMBING FIXTURES REQUIRING ACCESS LOCATIONS.
- ANY EXPOSED TILE EDGES SHALL HAVE TRIM, RE: A5005.
- PATCH AND REPAIR ALL SURFACES WHERE TILE WAS REMOVED TO RECEIVE NEW TILE. SLOPE FLOORS TOWARD DRAIN.
- COORDINATE HANDRAIL CLEARANCE WITH TOILET COMPARTMENT ACCESSORIES IN ACCESSIBLE SPALLS.
- RE: PLUMBING FOR NEW FAUCET AND SINK. SPECS.
- PROVIDE BLOCKING AS REQUIRED FOR MOUNTING OF ALL TOILET ACCESSORIES.
- INSTALL SEALANT IN JOINT BETWEEN CUT WALL TILE EDGE AND RECESSED RESTROOM ACCESSORY UNITS.
- COORDINATE ELECTRIC FLUSH VALVE SENSOR LOCATIONS PER MANUFACTURER'S REQUIREMENTS.
- COORDINATE HANDRAIL CLEARANCE WITH TOILET COMPARTMENT ACCESSORIES IN ACCESSIBLE SPALLS.
- RE: PLUMBING FOR NEW FAUCET AND SINK. SPECS.




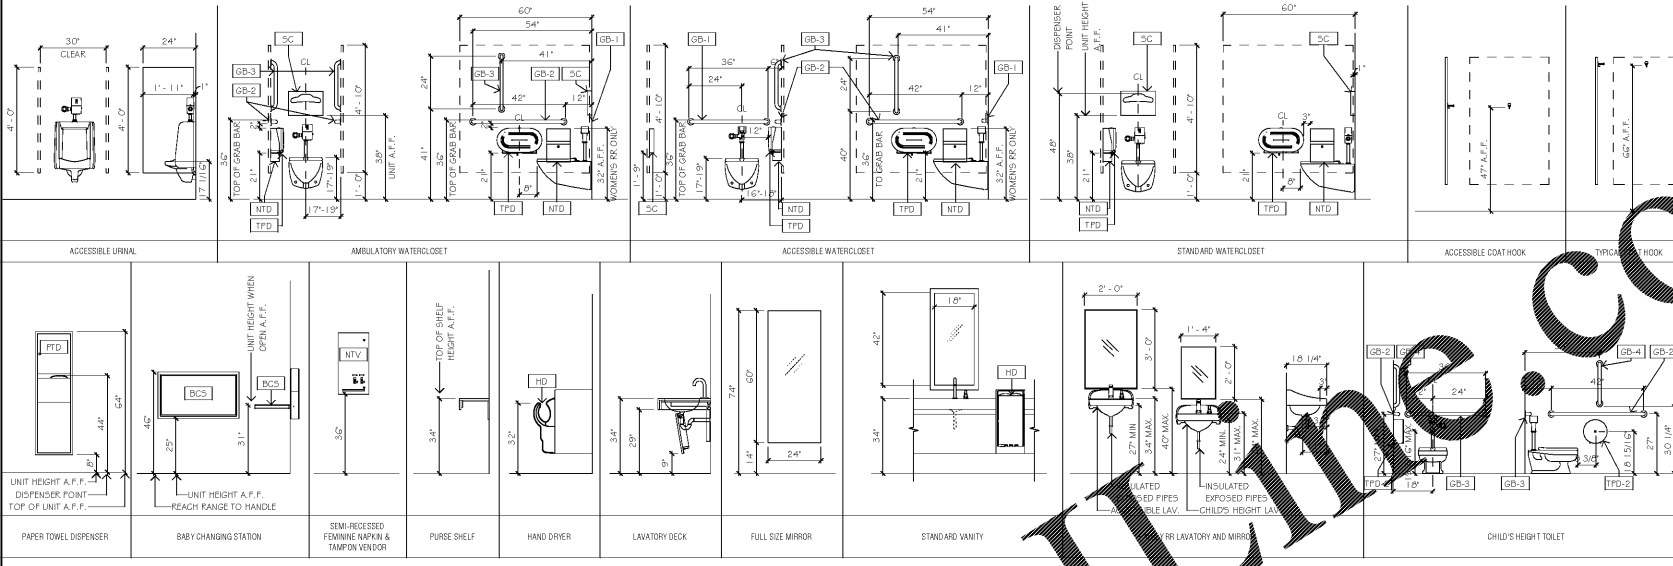


P8 RESTROOM FIXTURE NOTES  
3/8" = 1'-0"

P1 EQUIPMENT SCHEDULE



SHEET LEGEND	
GEN	GENERAL INFORMATION & SCHEDULES
MECH	MECHANICAL
PL	PLUMBING
EL	ELECTRICAL
W	WORKING DETAILS
R	RESTROOM & EQUIPMENT
A	AUDITORIUM

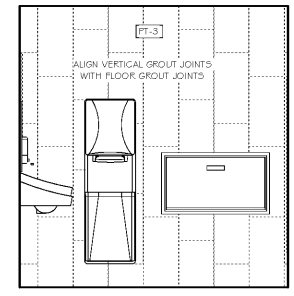
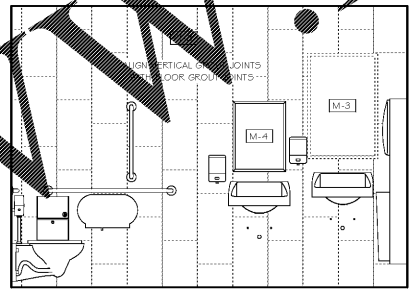
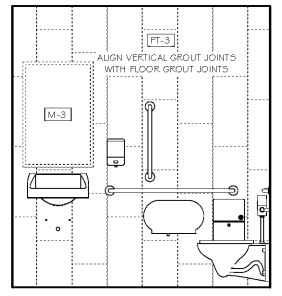
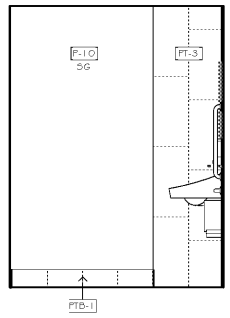


H1 RESTROOM ELEVATION - WOMEN (MEN MIRRORED)  
1/2" = 1'-0"

H5 RESTROOM ELEVATION - WOMEN (MEN MIRRORED)  
1/2" = 1'-0"

H10 RESTROOM ELEVATION - FAMILY  
1/2" = 1'-0"

H16 RESTROOM ELEVATION - FAMILY  
1/2" = 1'-0"

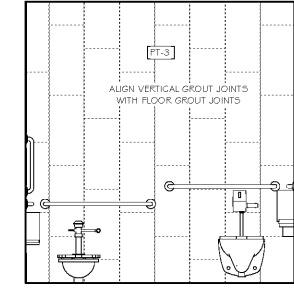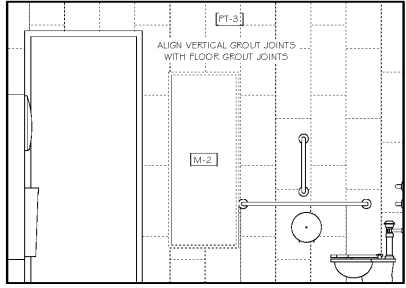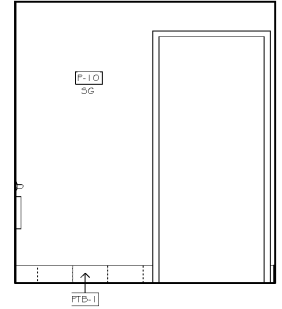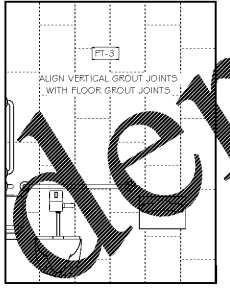

A1 RESTROOM ELEVATION - WOMEN (MEN MIRRORED)  
1/2" = 1'-0"

A5 RESTROOM ELEVATION - WOMEN (MEN MIRRORED)  
1/2" = 1'-0"

A10 RESTROOM ELEVATION - FAMILY  
1/2" = 1'-0"

A16 RESTROOM ELEVATION - FAMILY  
1/2" = 1'-0"

AMC MADISON YARDS 8  
AMC NEW BUILD  
906 MEMORIAL DR SE  
ATLANTA, GA 30316



American Multi-Cinema, Inc.  
One AMC Way  
11500 Ash Street  
Lenexa, KS 66211  
© Copyright 2018 American Multi-Cinema, Inc.

No.	Date	Description

KEY PLAN:	
1	4 5
2	6 7 8

SHEET TITLE:  
ELEVATIONS - RESTROOMS

SHEET NUMBER:  
A222

Order Plans @ WWW.LDLINE.COM