

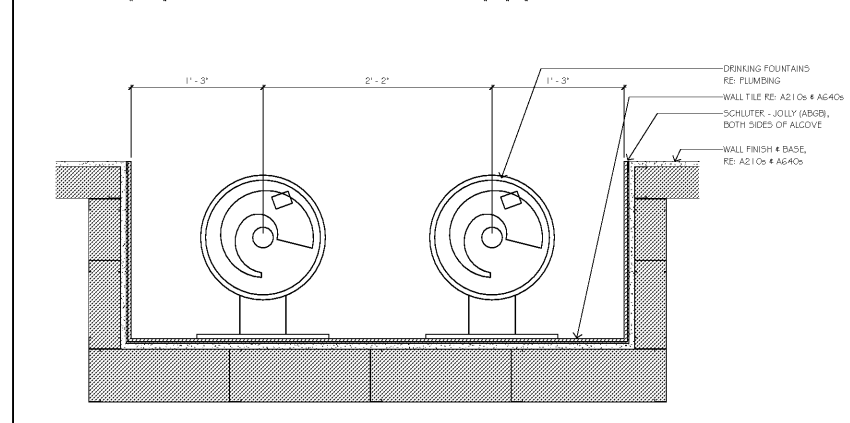



R1 PNEUMATIC TUBE ELEVATION
3/4" = 1'-0"

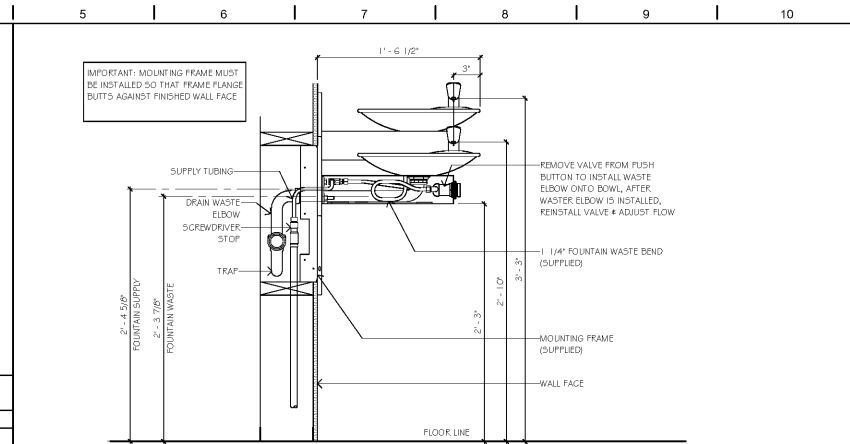


L5 DRINKING FOUNTAIN SECTION
1/2" = 1'-0"

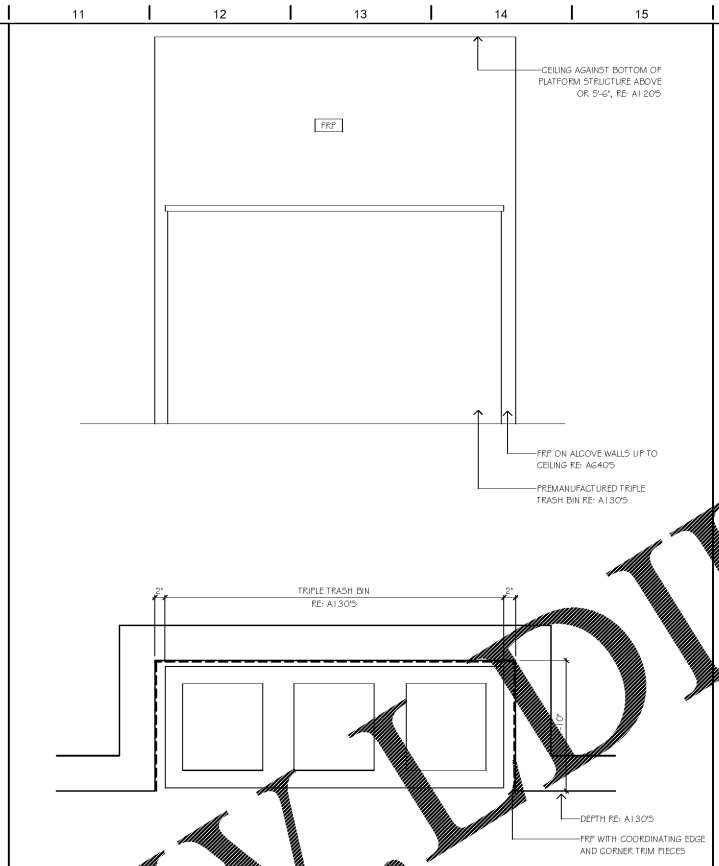


L11 TRASH ALCOVE ELEVATION AND PLAN
1" = 1'-0"

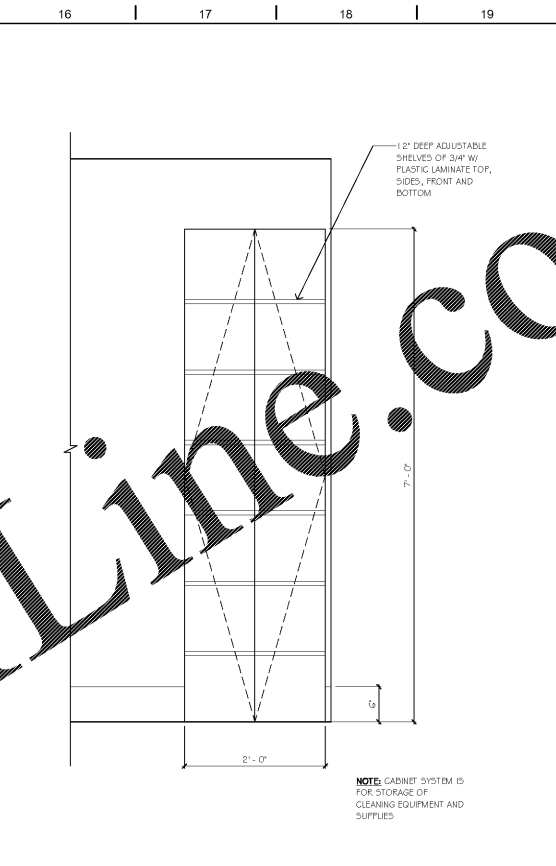


L16 JANITOR CABINET
1" = 1'-0"

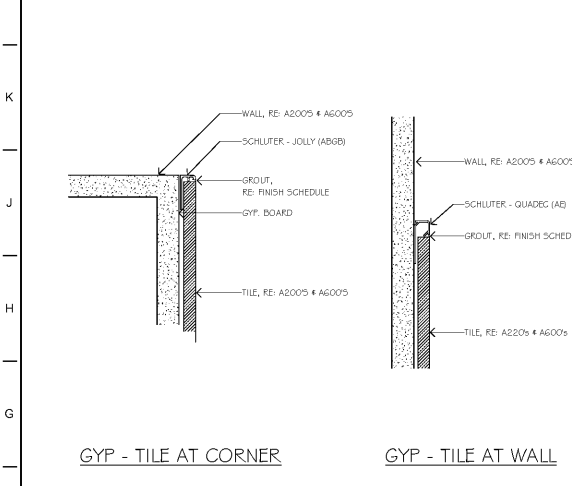


F1 FINISH EDGE DETAILS
6" = 1'-0"

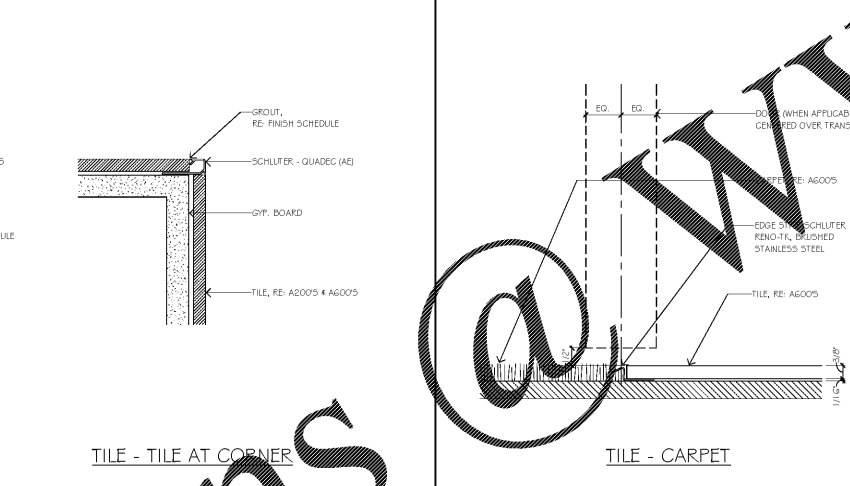


F8 FLOOR TRANSITION DETAILS
6" = 1'-0"

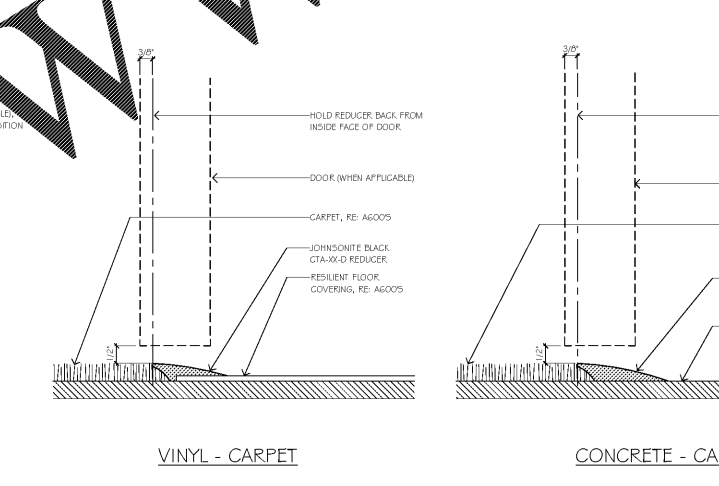


F8 FLOOR TRANSITION DETAILS
6" = 1'-0"

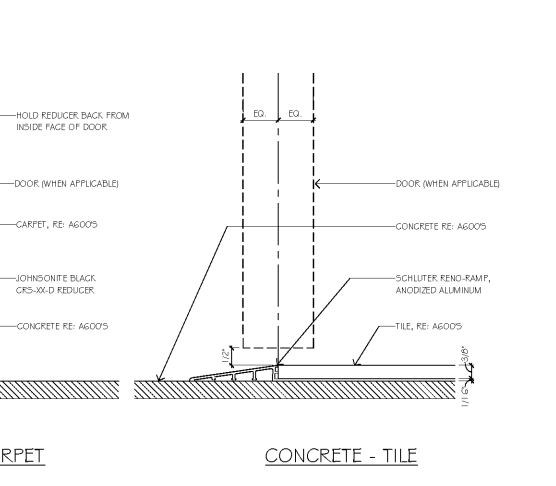


F8 FLOOR TRANSITION DETAILS
6" = 1'-0"

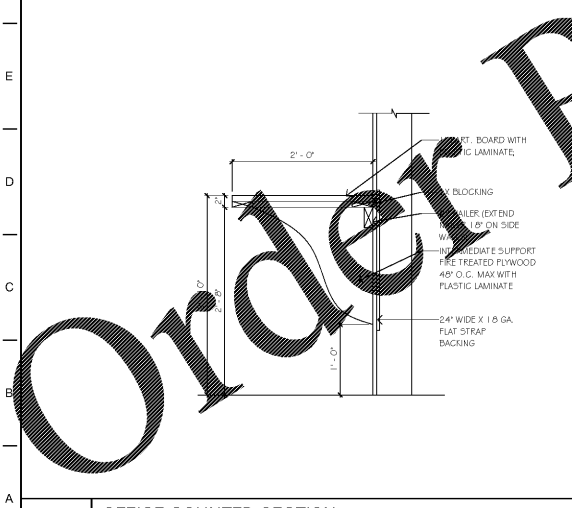


A1 OFFICE COUNTER SECTION
1" = 1'-0"

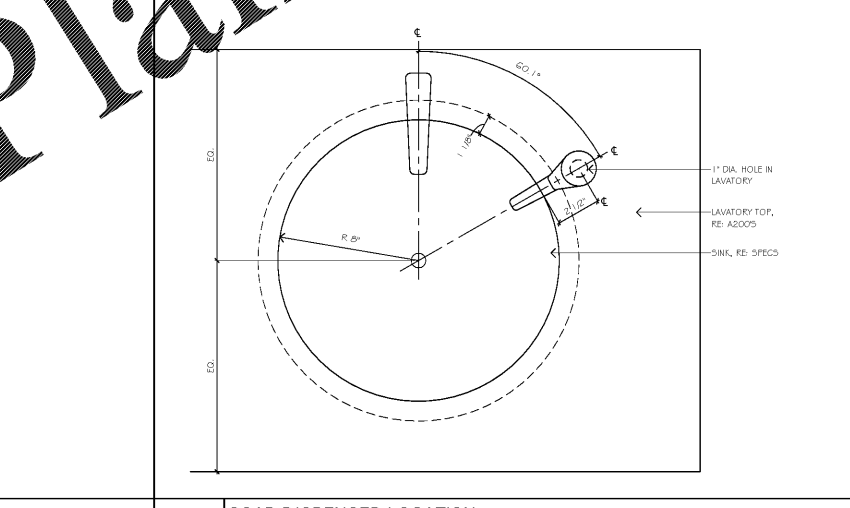

A6 SOAP DISPENSER LOCATION
3" = 1'-0"

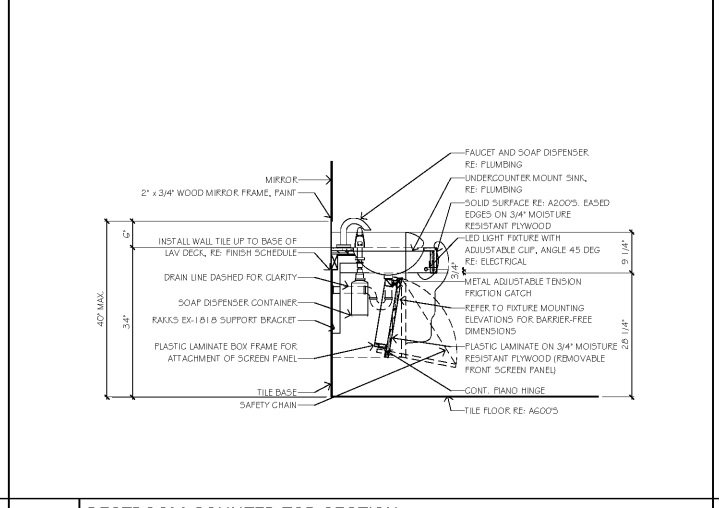

A11 RESTROOM COUNTER TOP SECTION
3/4" = 1'-0"

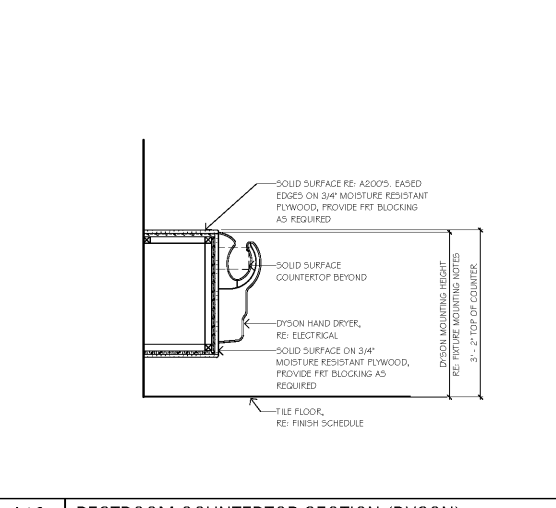

A16 RESTROOM COUNTERTOP SECTION (DYSON)
3/4" = 1'-0"

STATE OF GEORGIA
REGISTERED PROFESSIONAL ARCHITECT
L. W. KE...
18
14 West 3rd Street, Suite 102
Atlanta, GA 30333
(404) 525-1234

SHEET LEGEND

GENERAL INFORMATION & SCOPE OF WORK
GENERAL NOTES & DETAILS

A100 FLOOR PLANS & CEILING PLANS
A200 EXTERIOR & INTERIOR ELEVATIONS
A300 BUILDING SECTIONS
A400 FINISH SCHEDULES
A500 EXTERIOR & INTERIOR DETAILS
A600 FLOOR SCHEDULES, DOOR SCHEDULES
A700 MECHANICAL, ELECTRICAL, PLUMBING
A800 AUDITORIUM LIGHTING DETAILS
A900 MECHANICAL, ELECTRICAL, PLUMBING
A1000 WARDING DETAILS
A1100 CASEWORK & EQUIPMENT
A1200 PLUMBING

AMC MADISON YARDS 8

AMC NEW BUILD
905 MEMORIAL DR SE
ATLANTA, GA 30316

amc

American Multi-Cinema, Inc.
One AMC Way
11500 Ash Street
Lawrence, KS 66211

© Copyright 2018 American Multi-Cinema, Inc.

| No. | Date | Description |
|-----|------|-------------|
| | | |
| | | |
Project Issue Date: 05/22/2018

KEY PLAN:

| | | |
|---|---|---|
| 1 | 4 | 5 |
| 2 | 3 | 6 |
| 7 | 8 | |

SHEET TITLE:
MISC. DETAILS

SHEET NUMBER:
A541

Order Plans

WWW.LDILine.com