


PLAN NOTES

- MEZANINE SHALL BE 2 1/2" LIGHT WEIGHT CONCRETE ON 8" GALVANIZED STEEL COMPOSITE DECK (3 1/2" TOTAL THICKNESS). PROVIDE 10 GA. DECK FOR SPANS UP TO 10'-0". 10 GA. DECK FOR SPANS GREATER THAN 10'-0" AND UP TO 12'-0". FASTEN DECK WITH 5/8" DIA. RIVULE WELDS AT 12" O.C. DECK SHALL HAVE MIN Fy = 50KSI. REINFORCE WITH 8#-#2 @ 12" O.C.
 - RE SHEET 5911 FOR COMPOSITE BEAM KEY.
 - RISER SLABS SHALL BE 2" LIGHT WEIGHT CONCRETE ON 2" 20 GA. GALVANIZED STEEL DECK (4" TOTAL THICKNESS). PROVIDE 10 GA. DECK FOR SPANS UP TO 9'-6" AND UP TO 11'-0". 10 GA. DECK. REINFORCE CONCRETE WITH 8#-#2 @ 12" O.C. FASTEN DECK WITH 5/8" DIA. RIVULE WELDS AT 12" O.C. DECK SHALL HAVE MIN Fy = 50KSI U.N.C.
 - PROVIDE OPENINGS IN SLAB FOR MEP PENETRATIONS. RE: DETAIL 11-9910 FOR FRAMING SUPPORT INFORMATION. RE: MEP FOR REQUIRED LOCATIONS.
 - STAIR CONSTRUCTION SHALL BE M12X10 6 STRINGERS W/ CONCRETE FILLED PANS. REFERENCE ARCH FOR EXACT STAIR DIMENSIONS AND TREAD INFORMATION.
 - PROVIDE 1/2"x3/16" DIAGONAL BRACES FROM TOP OF RISER COLUMN TO FLANGE OF RISER PLATE FOR ALL CANTILEVERED RISER AND/OR CONTINUOUS OVER COLUMN BEAM CONDITIONS. BRACES SHALL BE AT 45 DEGREE ANGLE IN EACH DIRECTION.
 - PROVIDE 14 GA. GALVANIZED STEEL FOR STOP WITH 1/2" RETURN LIP AT EDGES OF COMPOSITE SLABS U.N.C.
- RE 11-9912 FOR STAIR CONSTRUCTION

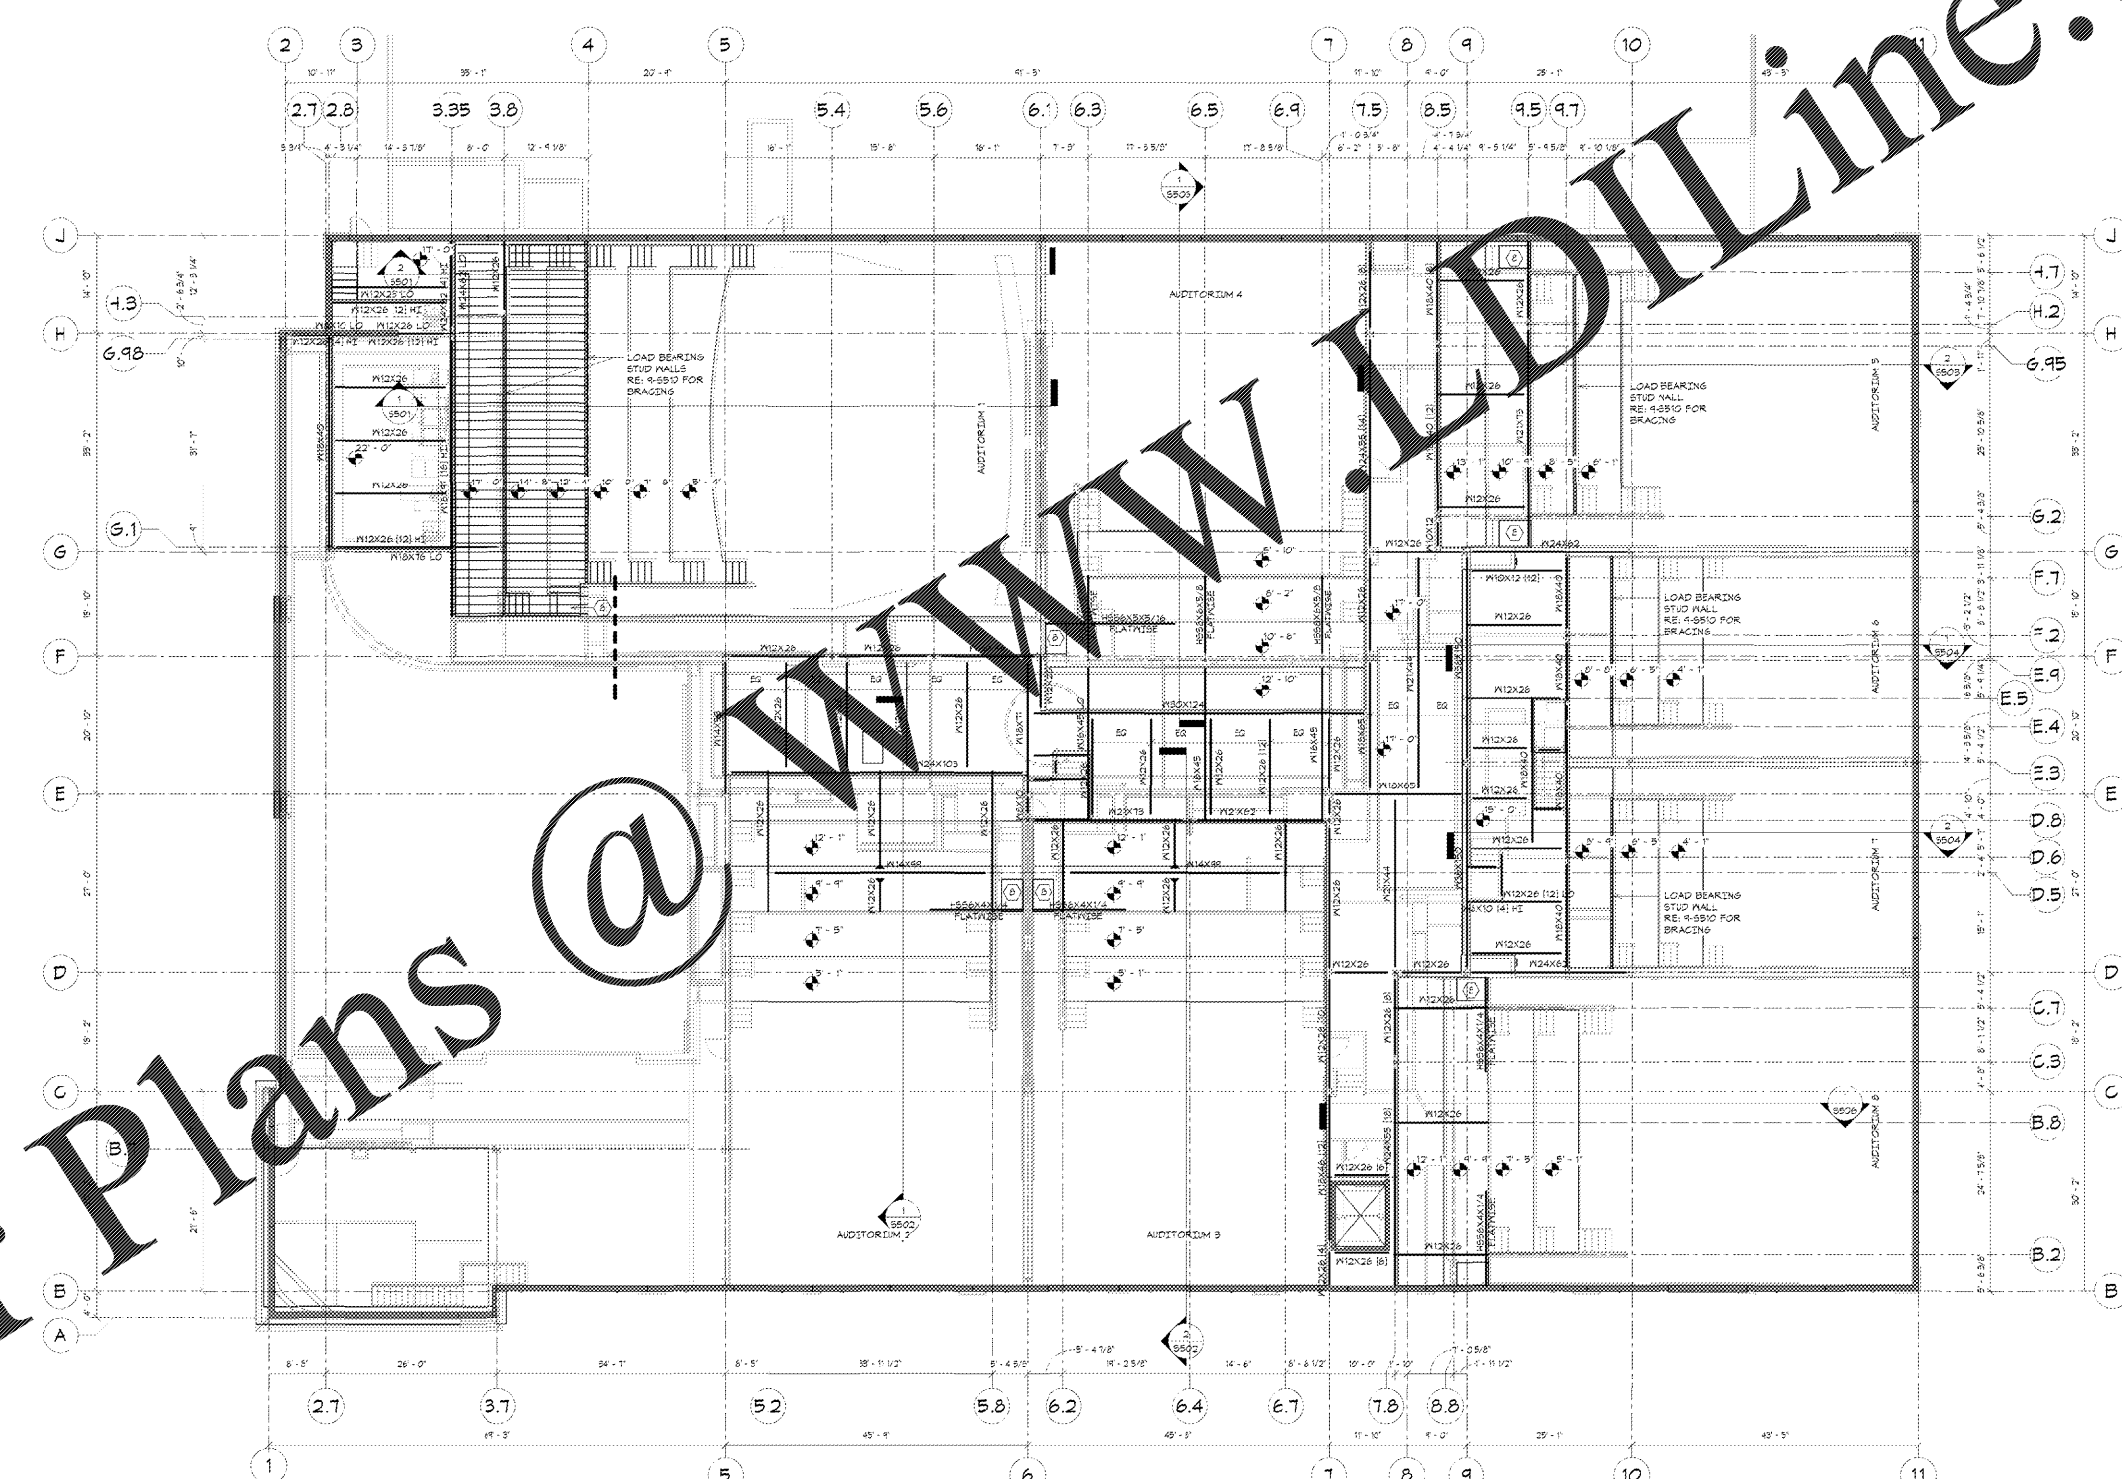

1 OVERALL PROJECTION LEVEL FRAMING PLAN
3/32" = 1'-0"

Professional Engineer Seal for William A. Schmidt, No. 42919, State of Georgia, Mechanical Engineering, License No. 1000. The seal is circular with the text 'WILLIAM A. SCHMIDT' around the perimeter and 'MECHANICAL ENGINEERING' at the bottom. The registration number '42919' and state 'STATE OF GEORGIA' are also visible.

SHEET LEGEND

6000	GENERAL INFORMATION & STORE OF WORK
6100	WORKSHEET PLANS & DETAILS
6200	ARCHITECTURAL PLANS & CONSTRUCTION
6300	MECHANICAL & ELECTRICAL PLANS
6400	PLUMBING & HYDRAULIC PLANS
6500	MECHANICAL & ELECTRICAL DETAILS
6600	MECHANICAL & ELECTRICAL CONSTRUCTION
6700	PLUMBING & HYDRAULIC CONSTRUCTION
6800	MECHANICAL & ELECTRICAL CONSTRUCTION
6900	PLUMBING & HYDRAULIC CONSTRUCTION
7000	MECHANICAL & ELECTRICAL CONSTRUCTION
7100	PLUMBING & HYDRAULIC CONSTRUCTION
7200	MECHANICAL & ELECTRICAL CONSTRUCTION
7300	PLUMBING & HYDRAULIC CONSTRUCTION
7400	MECHANICAL & ELECTRICAL CONSTRUCTION
7500	PLUMBING & HYDRAULIC CONSTRUCTION
7600	MECHANICAL & ELECTRICAL CONSTRUCTION
7700	PLUMBING & HYDRAULIC CONSTRUCTION
7800	MECHANICAL & ELECTRICAL CONSTRUCTION
7900	PLUMBING & HYDRAULIC CONSTRUCTION
8000	MECHANICAL & ELECTRICAL CONSTRUCTION

AMC MADISON YARDS 8

AMC NEW BUILD
906 MEMORIAL DR SE
ATLANTA, GA 30316

amc

American Multi-Cinema, Inc.
One AMC Way
11500 Ash Street
Louisville, KY 40211

KEY PLAN

No.	Date	Description

Project Issue Date: 05/22/2018

SHEET TITLE:
PROJ. LEVEL FRAMING PLAN

SHEET NUMBER:
S201

Order Plans @ www.ArchLine.com