



DATE: 11-18
Robert A. Schmidt
Professional Engineer, L.L.C.
1105 Peachtree Street, NE, Suite 200
Atlanta, GA 30309
Phone: 404-525-4532
Fax: 404-525-9999
www.rschmidtpe.com
N.S. JOB NUMBER: 2017-2018
© 2018 Robert A. Schmidt, L.L.C.

SHEET LEGEND

SYMBOLS: DIMENSIONS, INFORMATION & NOTES
SYMBOLS: WALLS, DOORS & DETAILS

ALIAS: FLOOR PLANS & CEILING PLANS
ACAD: ELECTRICAL & MECHANICAL SYMBOLS
APP: STRUCTURAL SYMBOLS
APP: MECHANICAL SYMBOLS
APP: ELECTRICAL & INSTRUMENTATION SYMBOLS
APP: MECHANICAL SYMBOLS
APP: MECHANICAL SYMBOLS
APP: MECHANICAL SYMBOLS
APP: MECHANICAL SYMBOLS
APP: MECHANICAL SYMBOLS

SYMBOLS: ELECTRICAL
SYMBOLS: MECHANICAL
SYMBOLS: MECHANICAL
SYMBOLS: MECHANICAL
SYMBOLS: MECHANICAL
SYMBOLS: MECHANICAL
SYMBOLS: MECHANICAL
SYMBOLS: MECHANICAL
SYMBOLS: MECHANICAL

AMC MADISON YARDS 8
AMC NEW BUILD
506 MEMORIAL DR SE
ATLANTA, GA 30316




Project Issue Date: 05/22/2018

No.	Date	Description

KEY PLAN:

SHEET TITLE:
**ENLARGED
PLAN - AUD. 1**

SHEET NUMBER:
S202

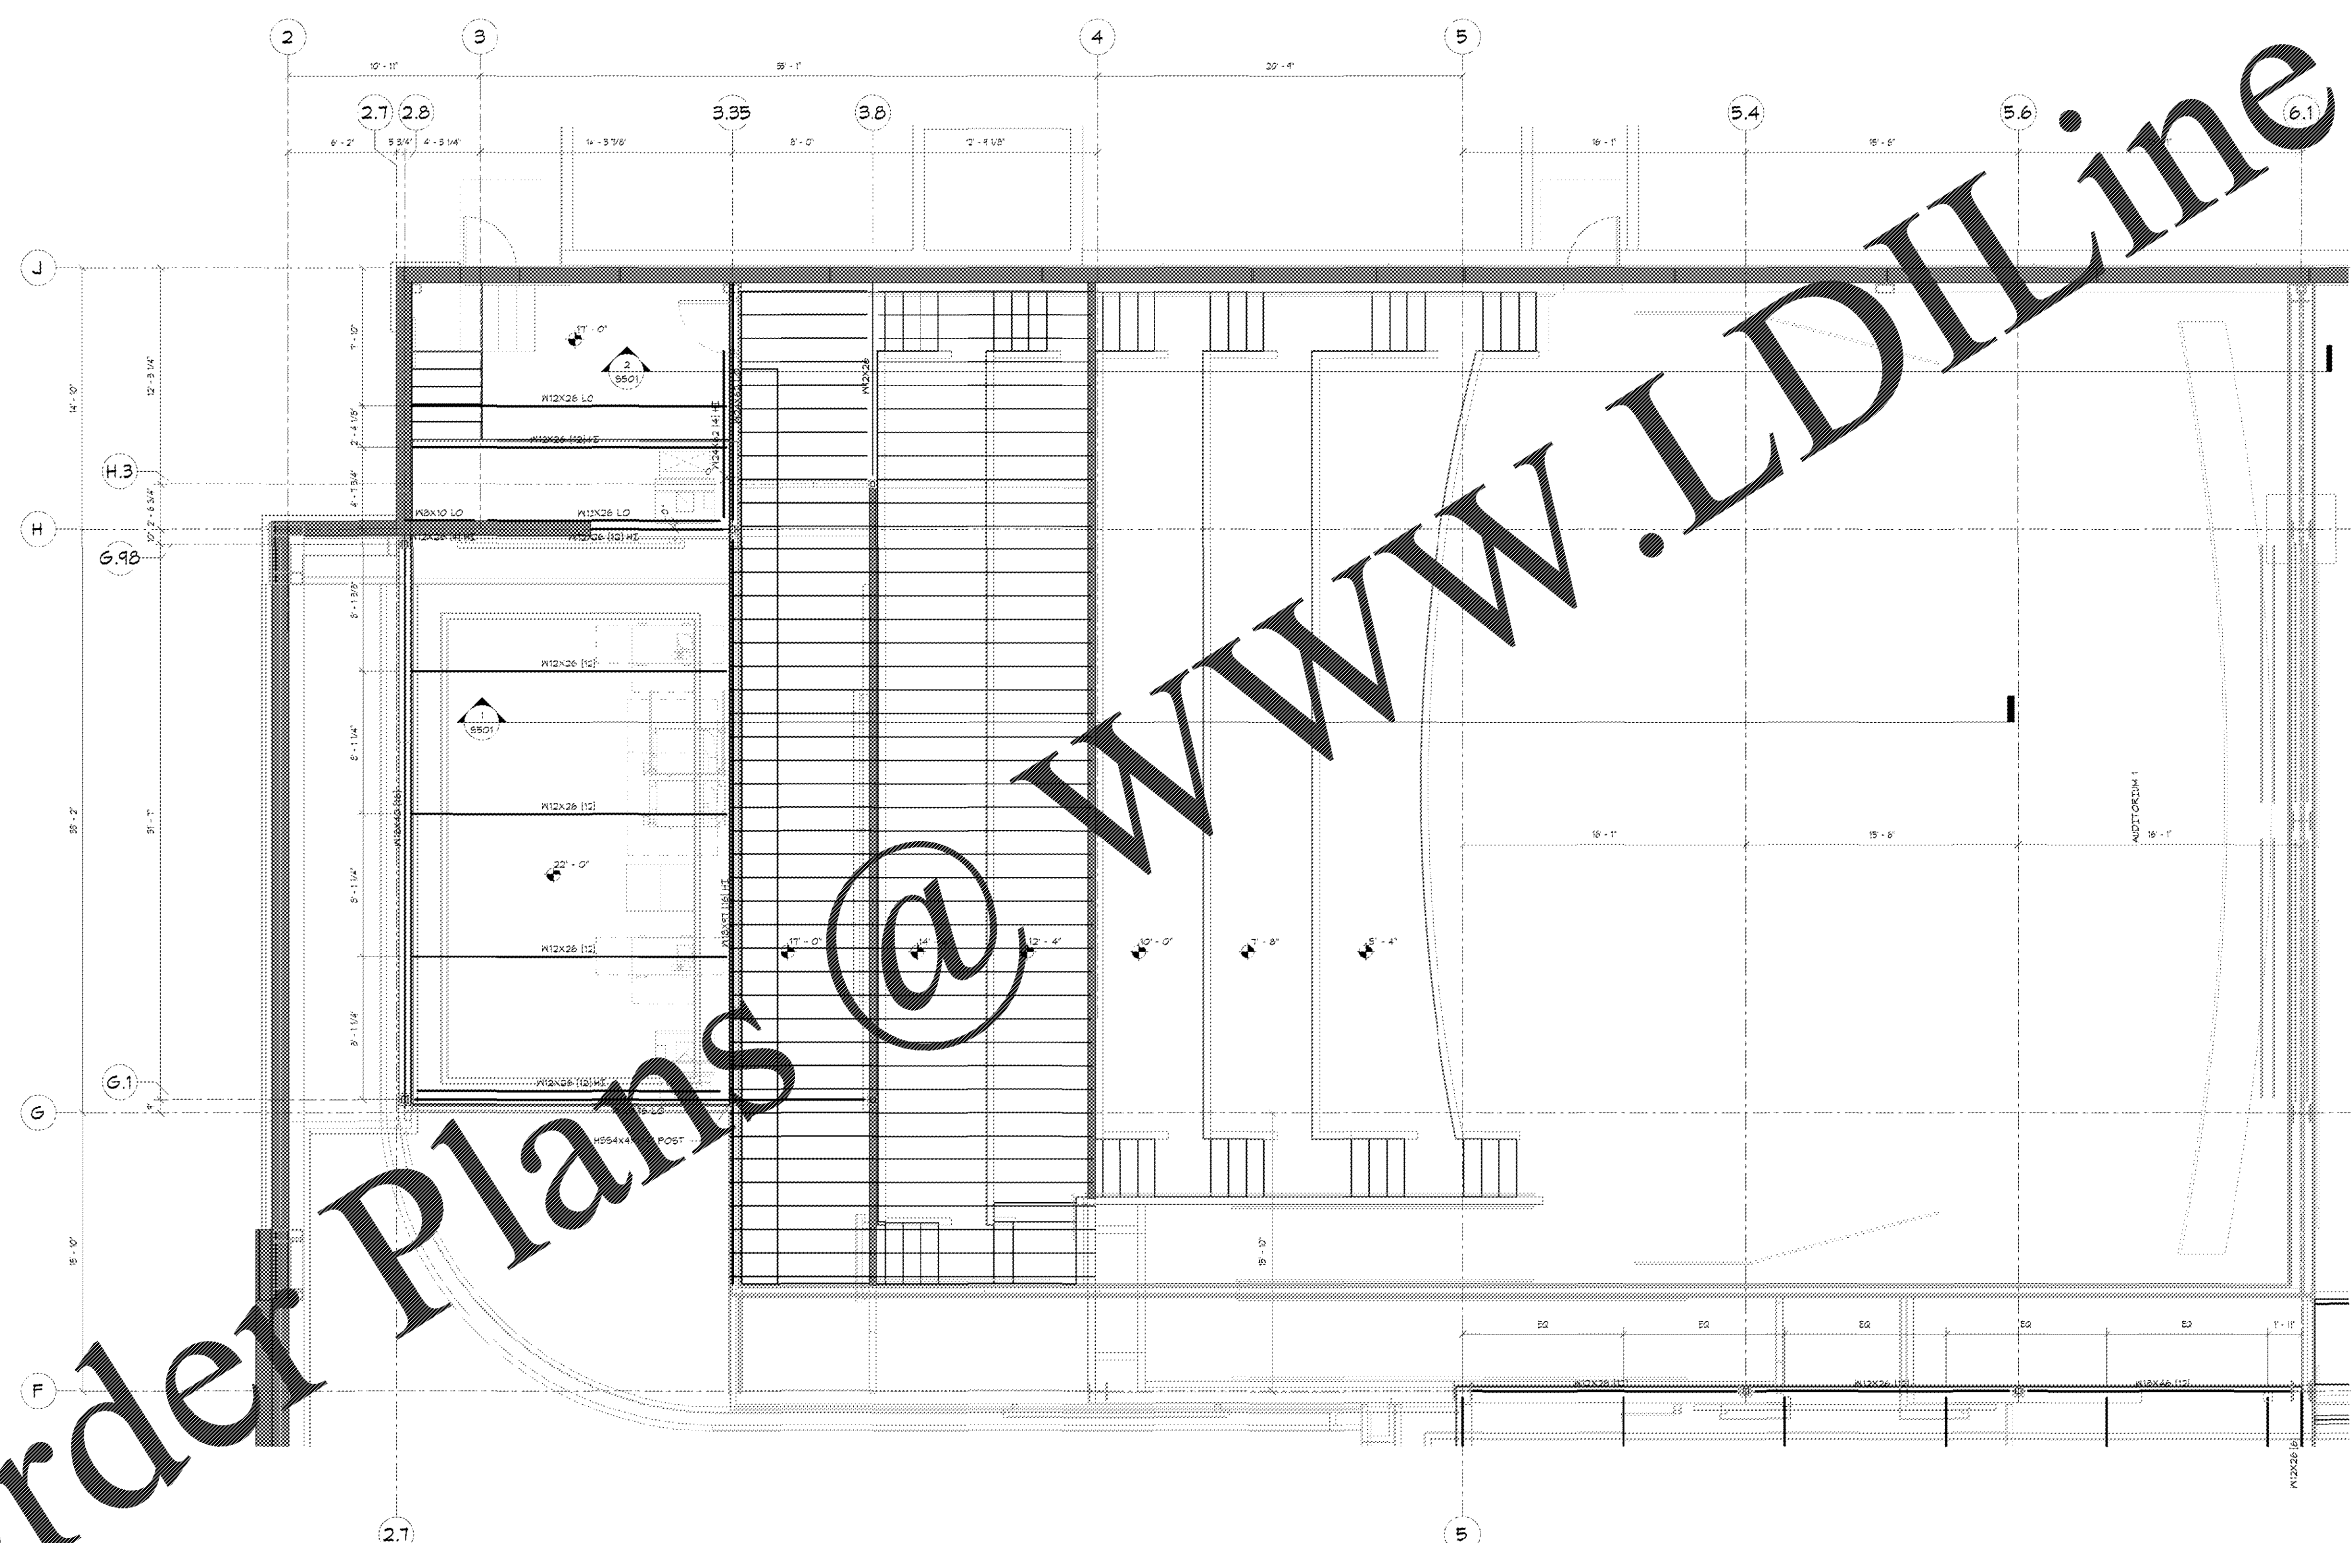

1 ENLARGED PROJECTION LEVEL PLAN - AUD. 1
1/4" = 1'-0"

Order Plans @ www.LDIDline.com