



RE DATE: 11
 Consulting Engineers, L.L.C.
 111 East 11th Avenue
 North Kansas City, MO 64116
 Phone: (816) 487-4522
 Fax: (816) 421-1625
 www.robertson.com
 MISS JCS NUMBER: 2017-2319
 © 2018 Robert Robertson Consulting Engineers, L.L.C.

SHEET LEGEND

0000	GENERAL INFORMATION & SCALE OF WORK
0100	GENERAL NOTES & DETAILS
1000	FLOOR PLANS & CEILING PLANS
2000	ADDITIONAL INFORMATION & DETAILS
3000	MECHANICAL
4000	ELECTRICAL
5000	PLUMBING
6000	MECHANICAL, ELECTRICAL, PLUMBING (MEP)
7000	MECHANICAL, ELECTRICAL, PLUMBING (MEP) DETAILS
8000	MECHANICAL, ELECTRICAL, PLUMBING (MEP) DETAILS
9000	MECHANICAL, ELECTRICAL, PLUMBING (MEP) DETAILS

AMC MADISON YARDS 8
 AMC NEW BUILD
 805 MEMORIAL DR SE
 ATLANTA, GA 30316




No.	Date	Description


Project Issue Date: 05/22/2018
 KEY PLAN:

SHEET TITLE:
AUDITORIUM SECTIONS

SHEET NUMBER:
S501

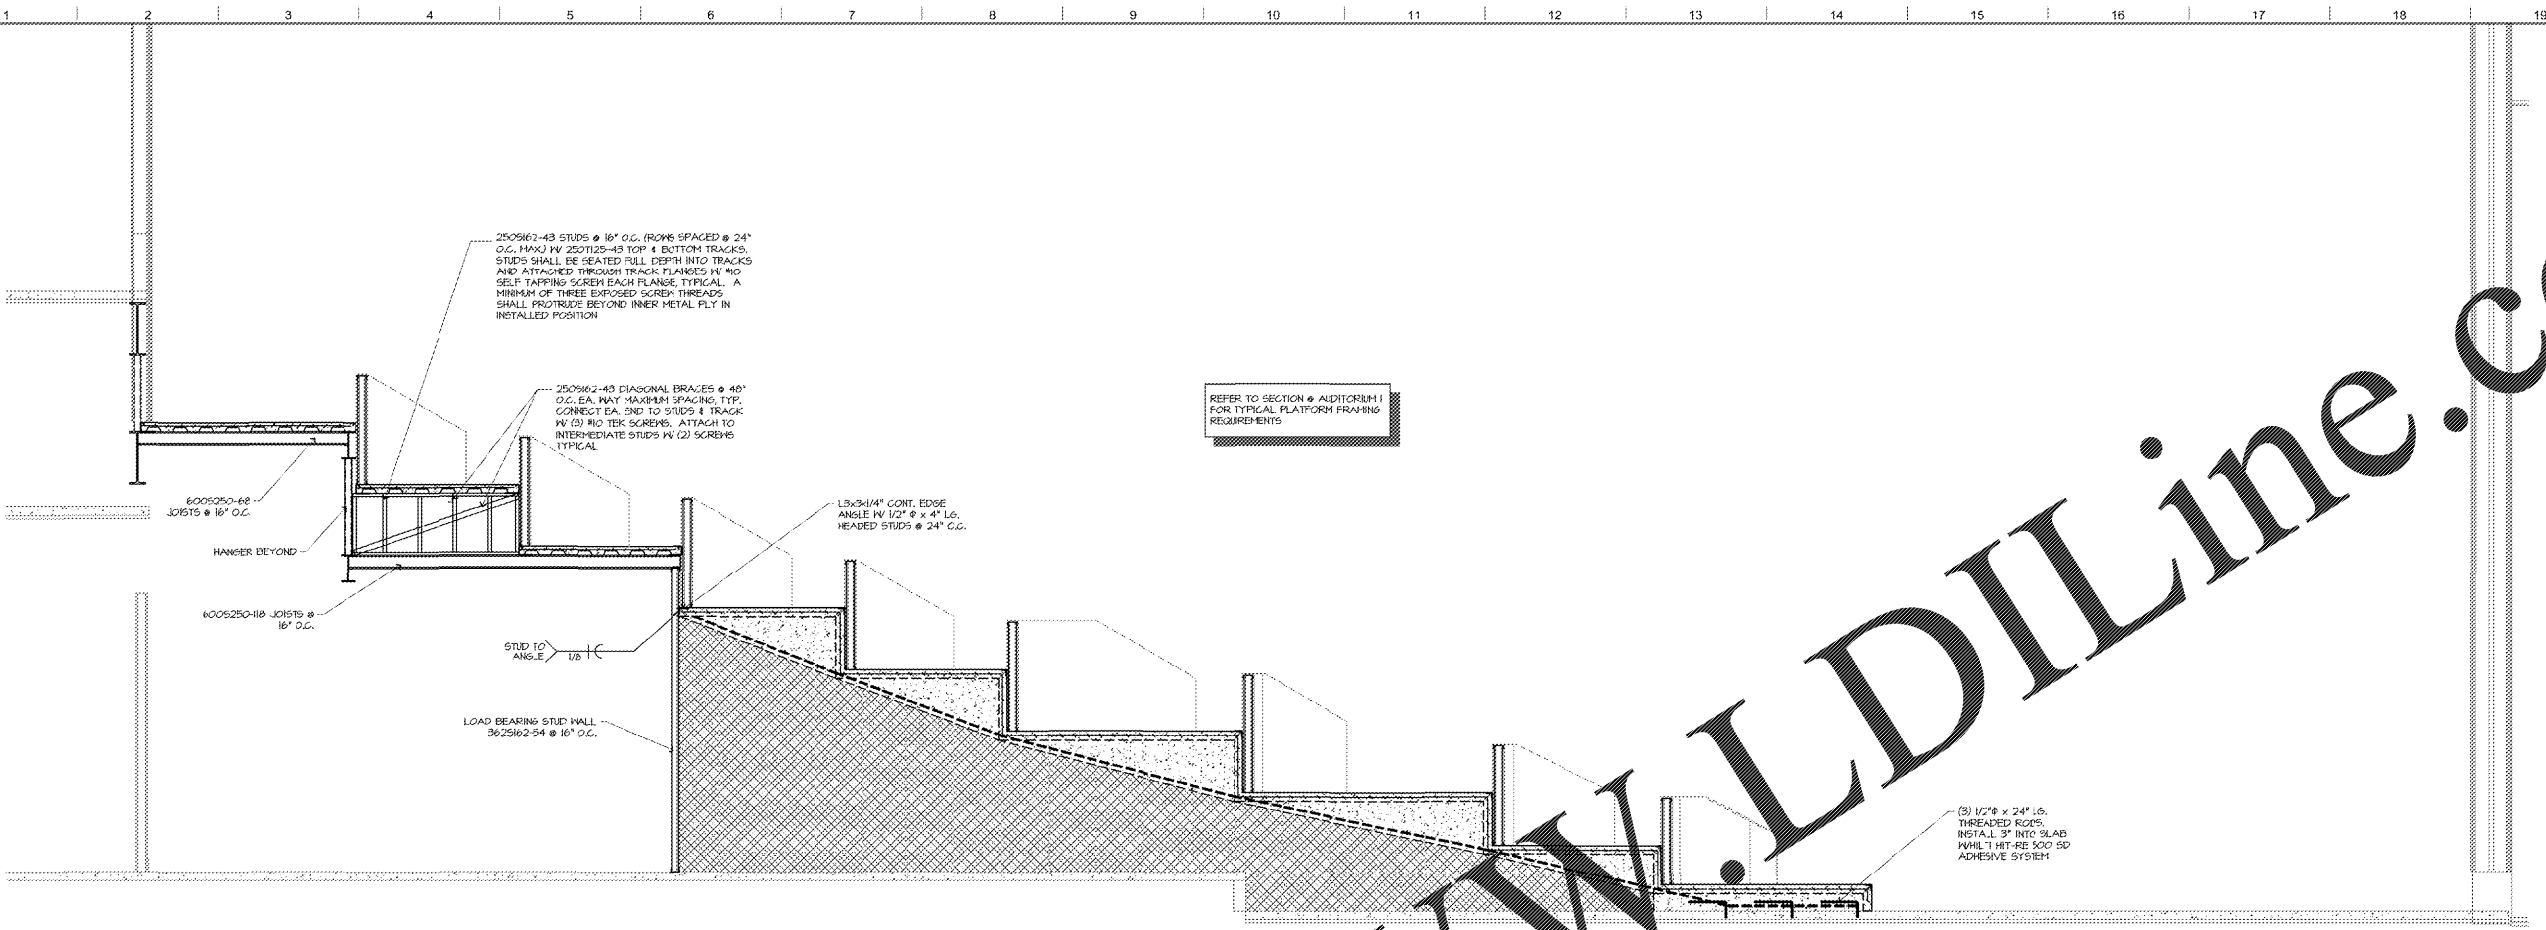

2 SECTION @ AUDITORIUM IA
 SCALE: 3/8" = 1'-0"

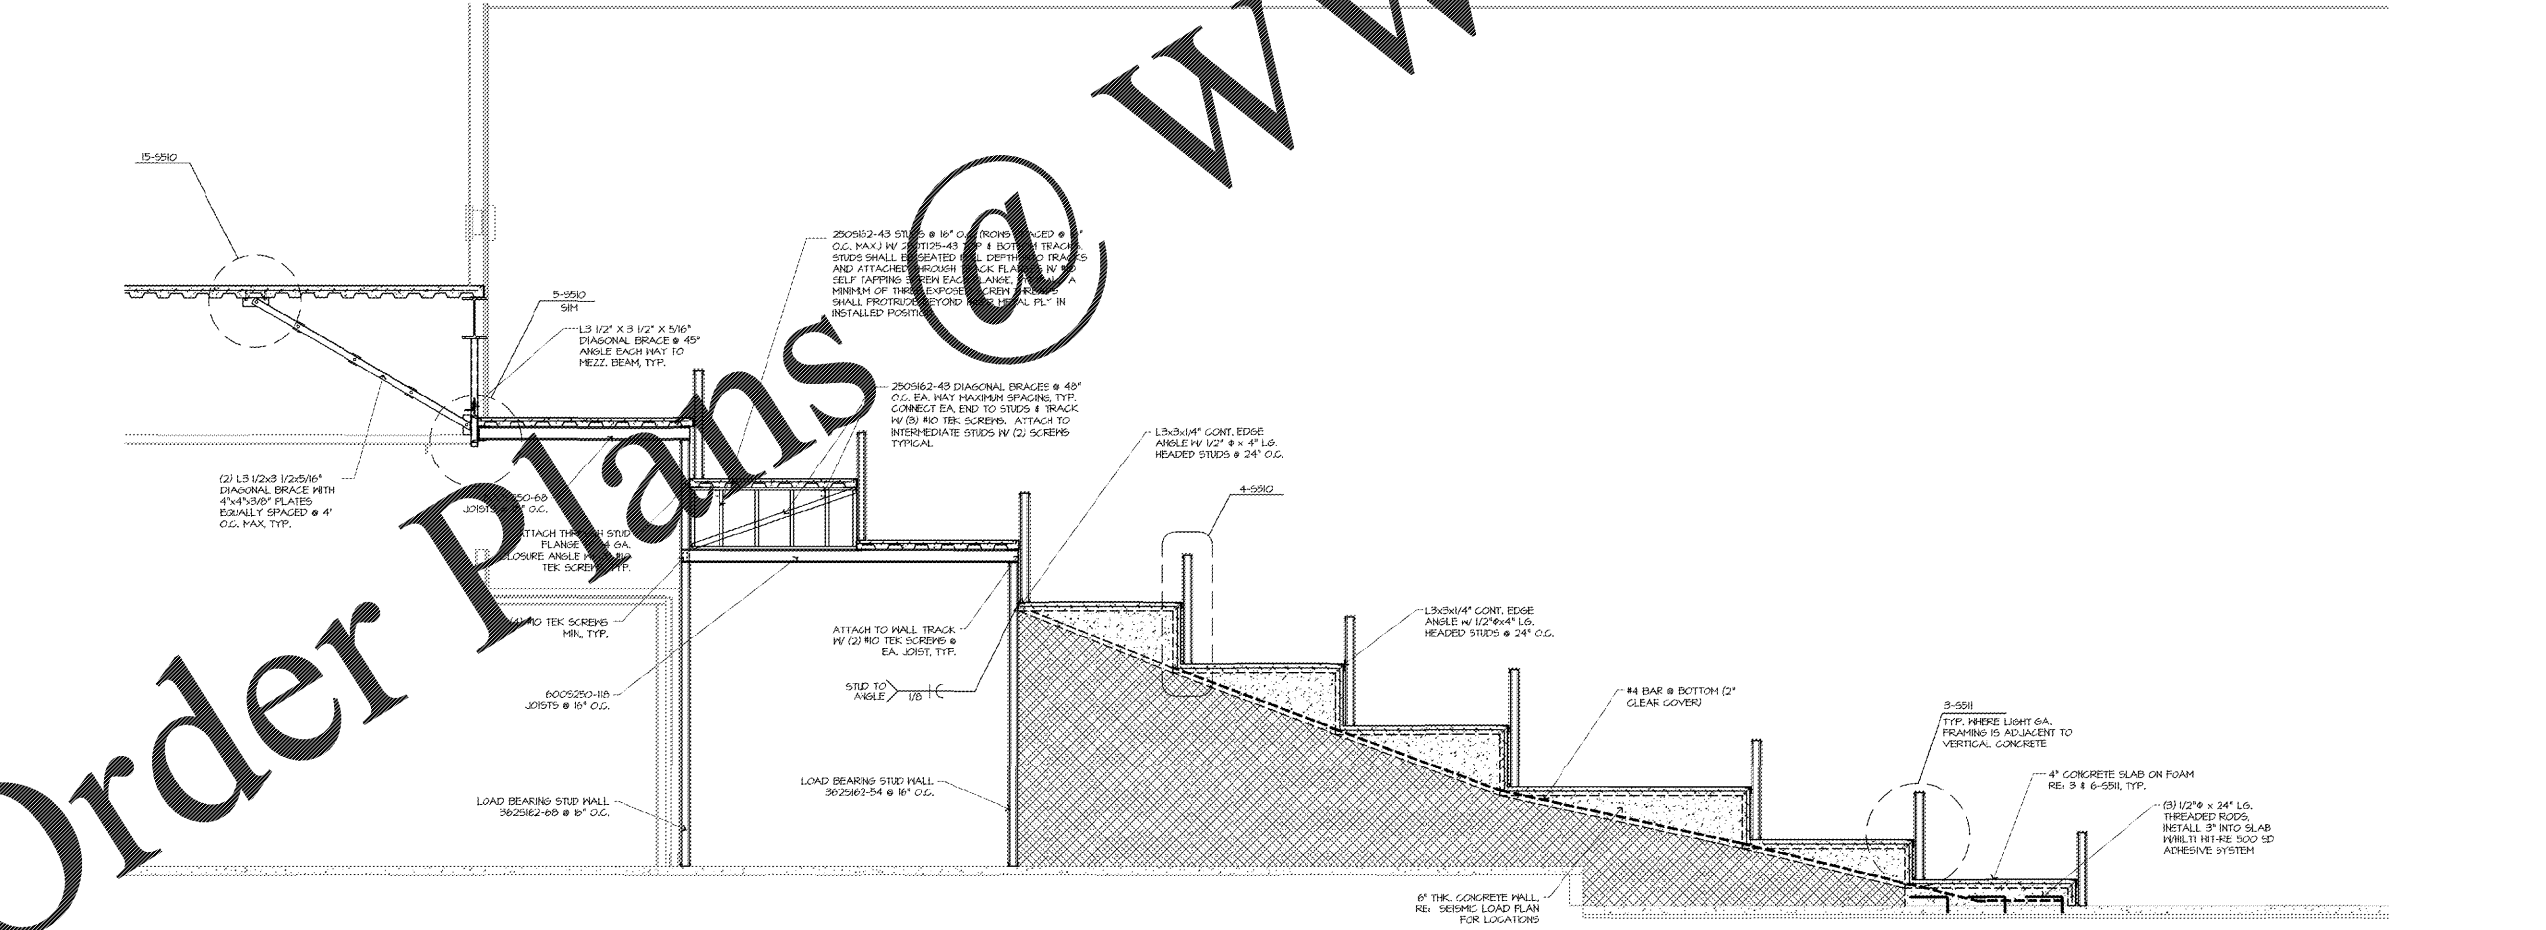

1 SECTION @ AUDITORIUM I
 SCALE: 3/8" = 1'-0"

Order Plans @

WWW.LDILine.com