
 DATE: 11/18/18
James A. Schmitt
 Consulting Engineers, L.L.C.
 411 East 11th Avenue
 North Kansas City, MO 64116
 Phone: (816) 451-1232
 Fax: (816) 421-1625
 www.jaschmitt.com
 MISS JOB NUMBER: 2017-2911
 © 2018 James A. Schmitt Consulting Engineers, L.L.C.

SHEET LEGEND

200% GENERAL INFORMATION & NOTES ON ARCH.
 100% FINISHED ARCHITECT'S DETAILS
 100% FLOOR PLANS & CEILING PLANS
 100% MECHANICAL SYSTEMS & ELECTRICAL SYSTEMS
 100% MECHANICAL PLANS
 100% EXTERIOR & INTERIOR DETAILS
 100% ARCHITECTURAL WORK ITEMS
 100% MECHANICAL WORK ITEMS
 100% ELECTRICAL WORK ITEMS
 100% STRUCTURAL WORK ITEMS
 100% CIVIL WORK ITEMS
 100% CONSTRUCTION ITEMS

AMC MADISON YARDS 8

AMC NEW BUILD
 905 MEMORIAL DR SE
 ATLANTA, GA 30316




American Multi Cinema, Inc.
 One AMC Way
 11570 Ash Street
 Littleton, CO 80121

© Copyright 2018, American Multi Cinema, Inc.

No.	Date	Description


Project Issue Date: 05/22/2018

KEY PLAN:




SHEET TITLE:
AUDITORIUM SECTIONS

SHEET NUMBER:
S502

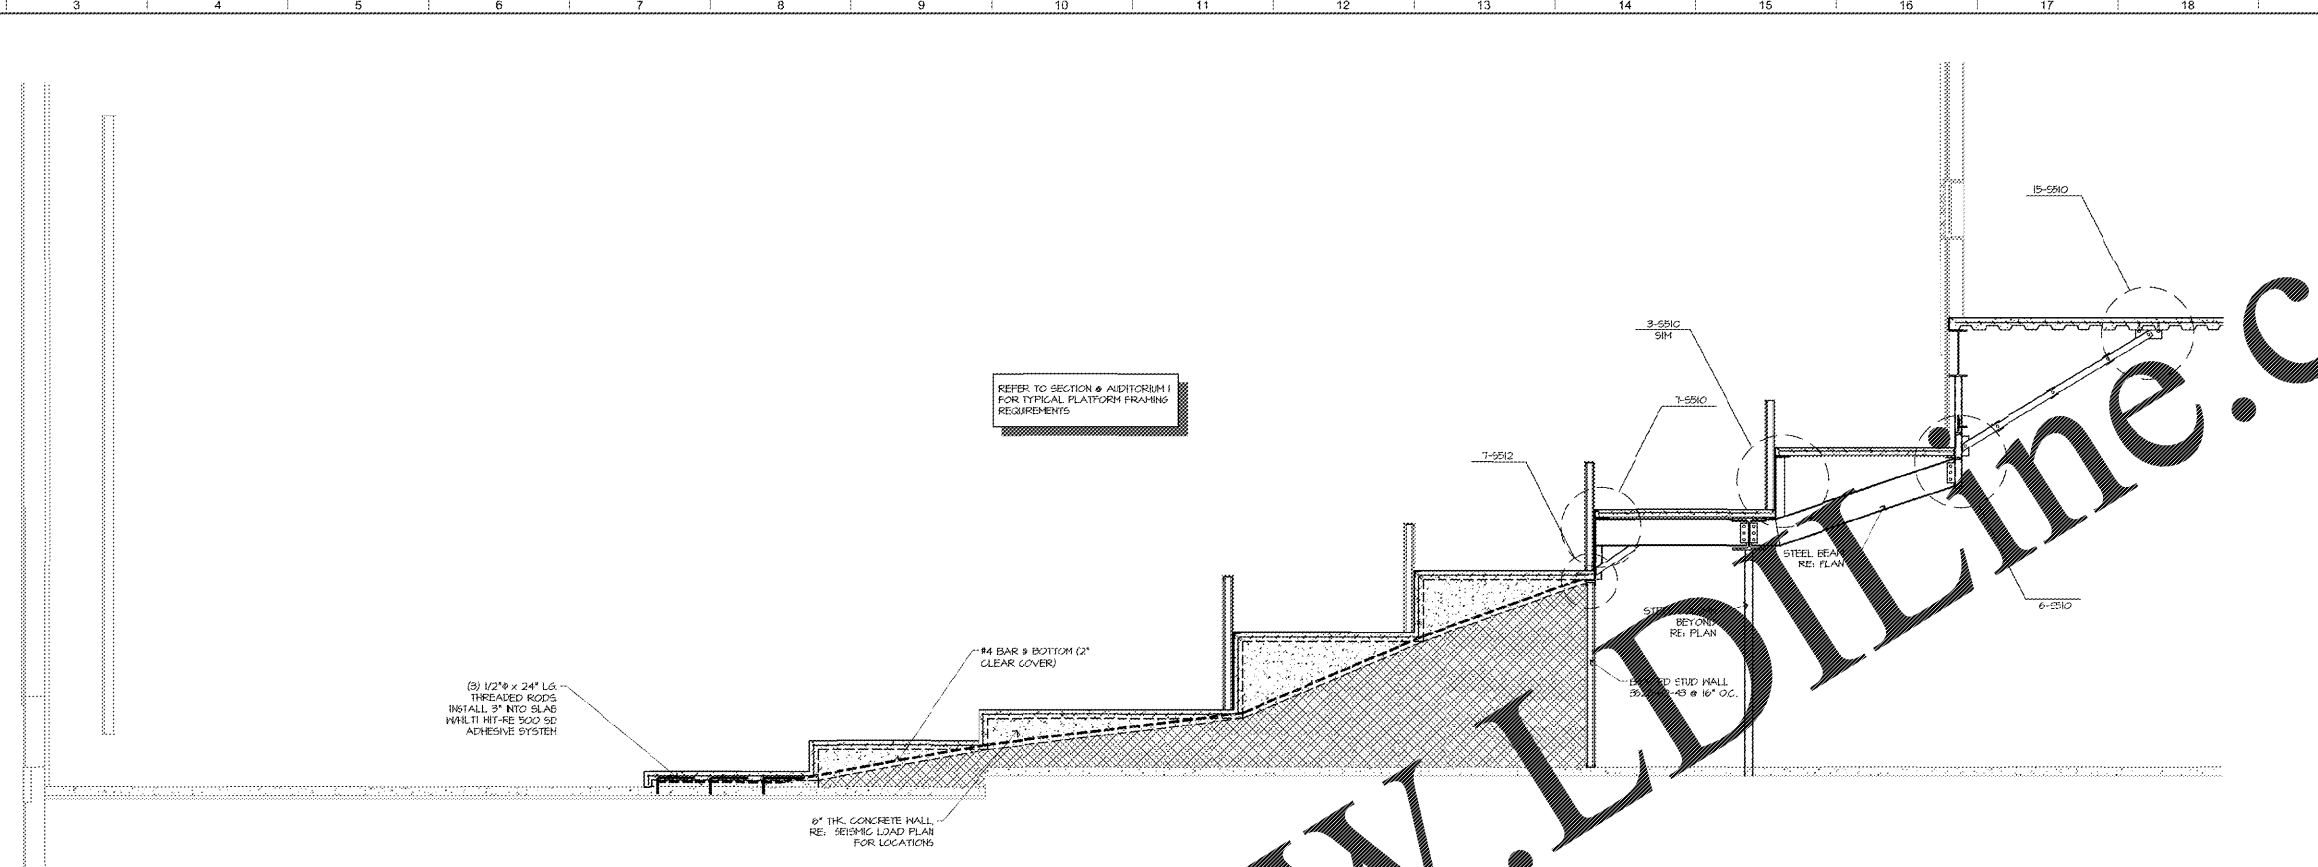

2 SECTION @ AUDITORIUM 3
SCALE: 3/8" = 1'-0"

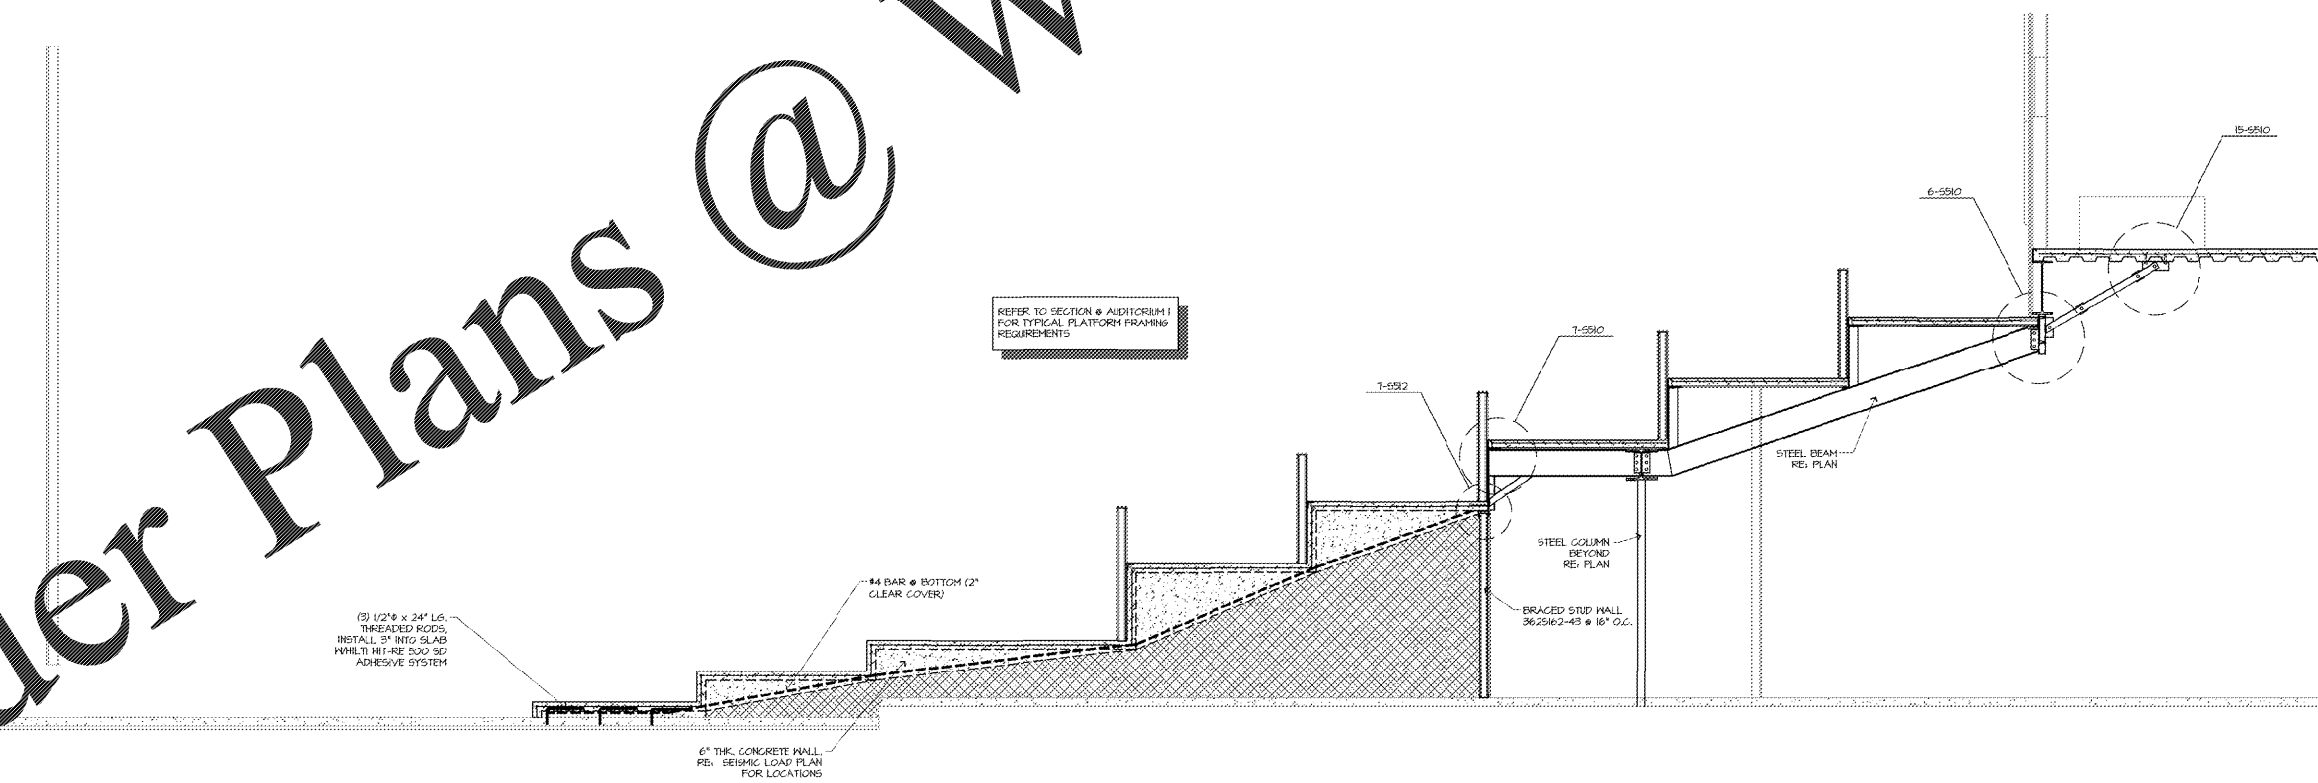

1 SECTION @ AUDITORIUM 2
SCALE: 3/8" = 1'-0"

Order Plans @ www.LDOnline.com