

Robert J. Schmitt
 Consulting Engineers, L.L.C.
 1180 West 11th Avenue
 North Kansas City, MO 64116
 Phone: (816) 437-4522
 Fax: (816) 421-1925
 www.rjschmitt.com
 NCS JCS NUMBER: 2017-2313
 © 2016 Robert J. Schmitt Consulting Engineers, L.L.C.

SHEET LEGEND

0000 GENERAL INFORMATION & NOTES ON ARCHITECTURAL PLANS & DETAILS

A100 FLOOR PLANS & CEILING PLANS
 A200 SECTION & ELEVATION DETAILS
 A300 FOUNDATION
 A400 EXTERIOR & INTERIOR DETAILS
 A500 MECHANICAL
 A600 ELECTRICAL
 A700 PLUMBING
 A800 MECHANICAL, ELECTRICAL & PLUMBING
 A900 ARCHITECTURAL FINISHES & DETAILS

BY: STRUCTURAL
 BY: MECHANICAL
 BY: ELECTRICAL
 BY: PLUMBING
 BY: MECHANICAL, ELECTRICAL & PLUMBING
 BY: ARCHITECTURAL FINISHES & DETAILS

AMC MADISON YARDS 8

AMC NEW BUILD
 805 MEMORIAL DR SE
 ATLANTA, GA 30316




No.	Date	Description

Project Issue Date: 05/22/2018


KEY PLAN:

SHEET TITLE:
AUDITORIUM SECTIONS

SHEET NUMBER:
S503

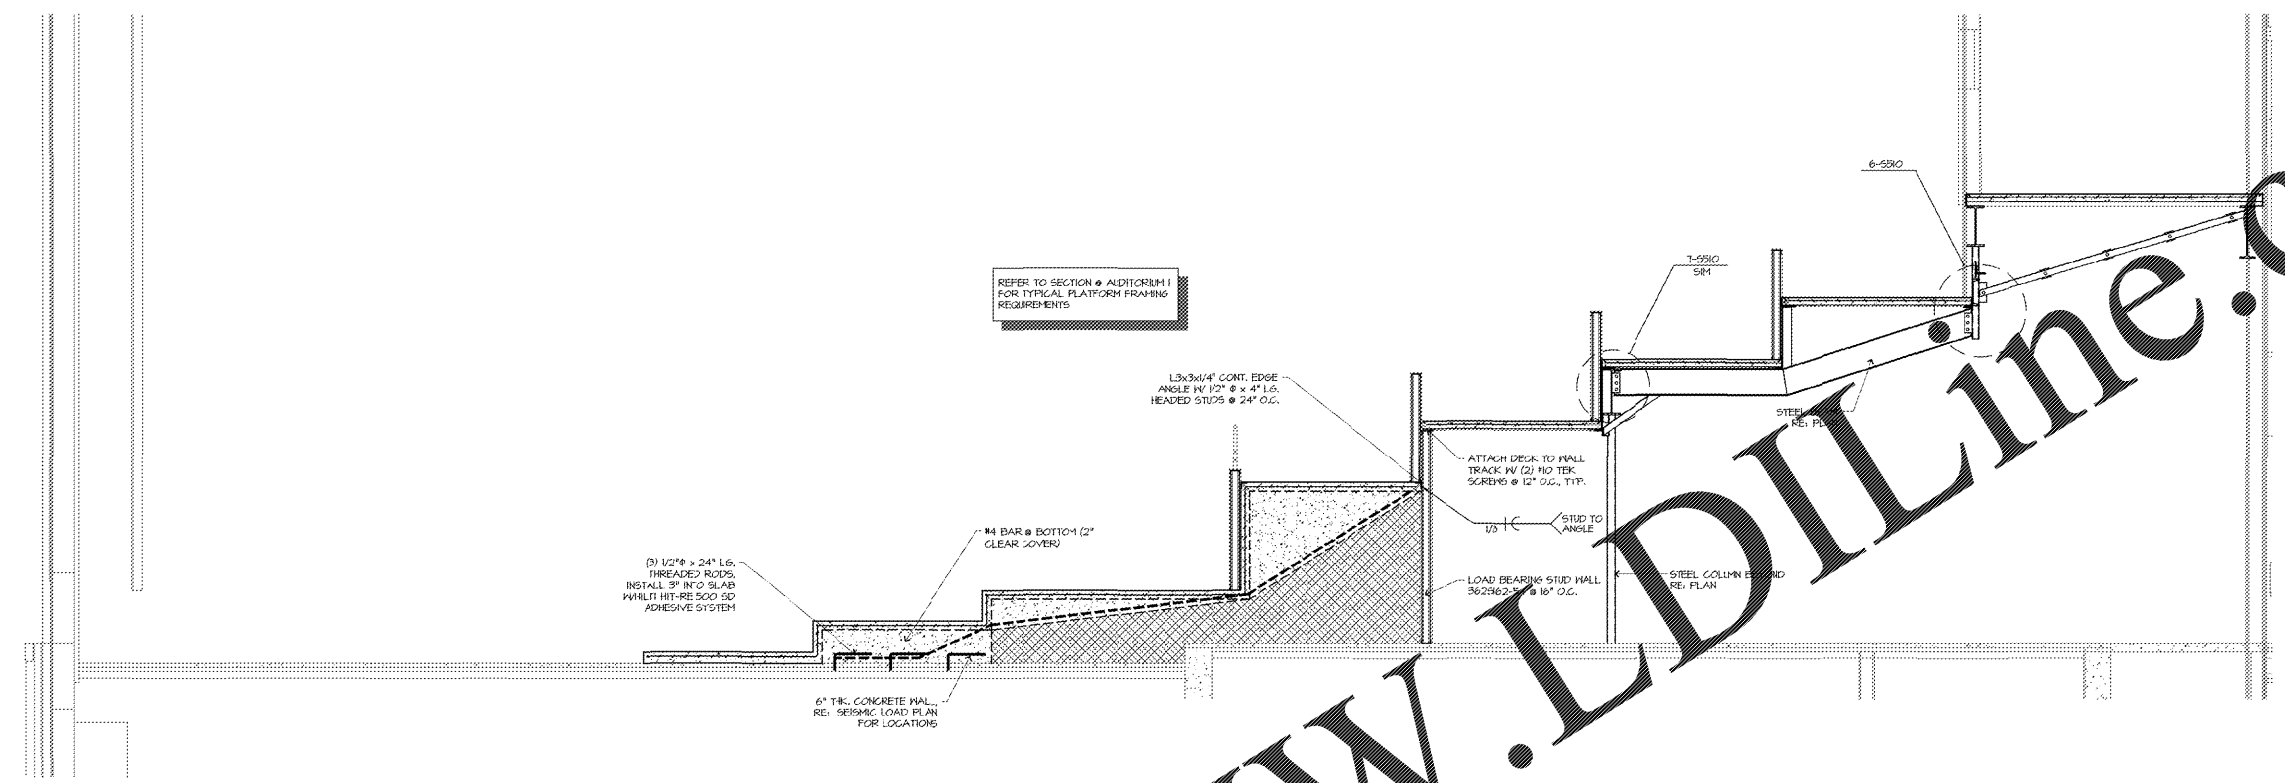

2 SECTION @ AUDITORIUM 5
 SCALE: 3/8" = 1'-0"

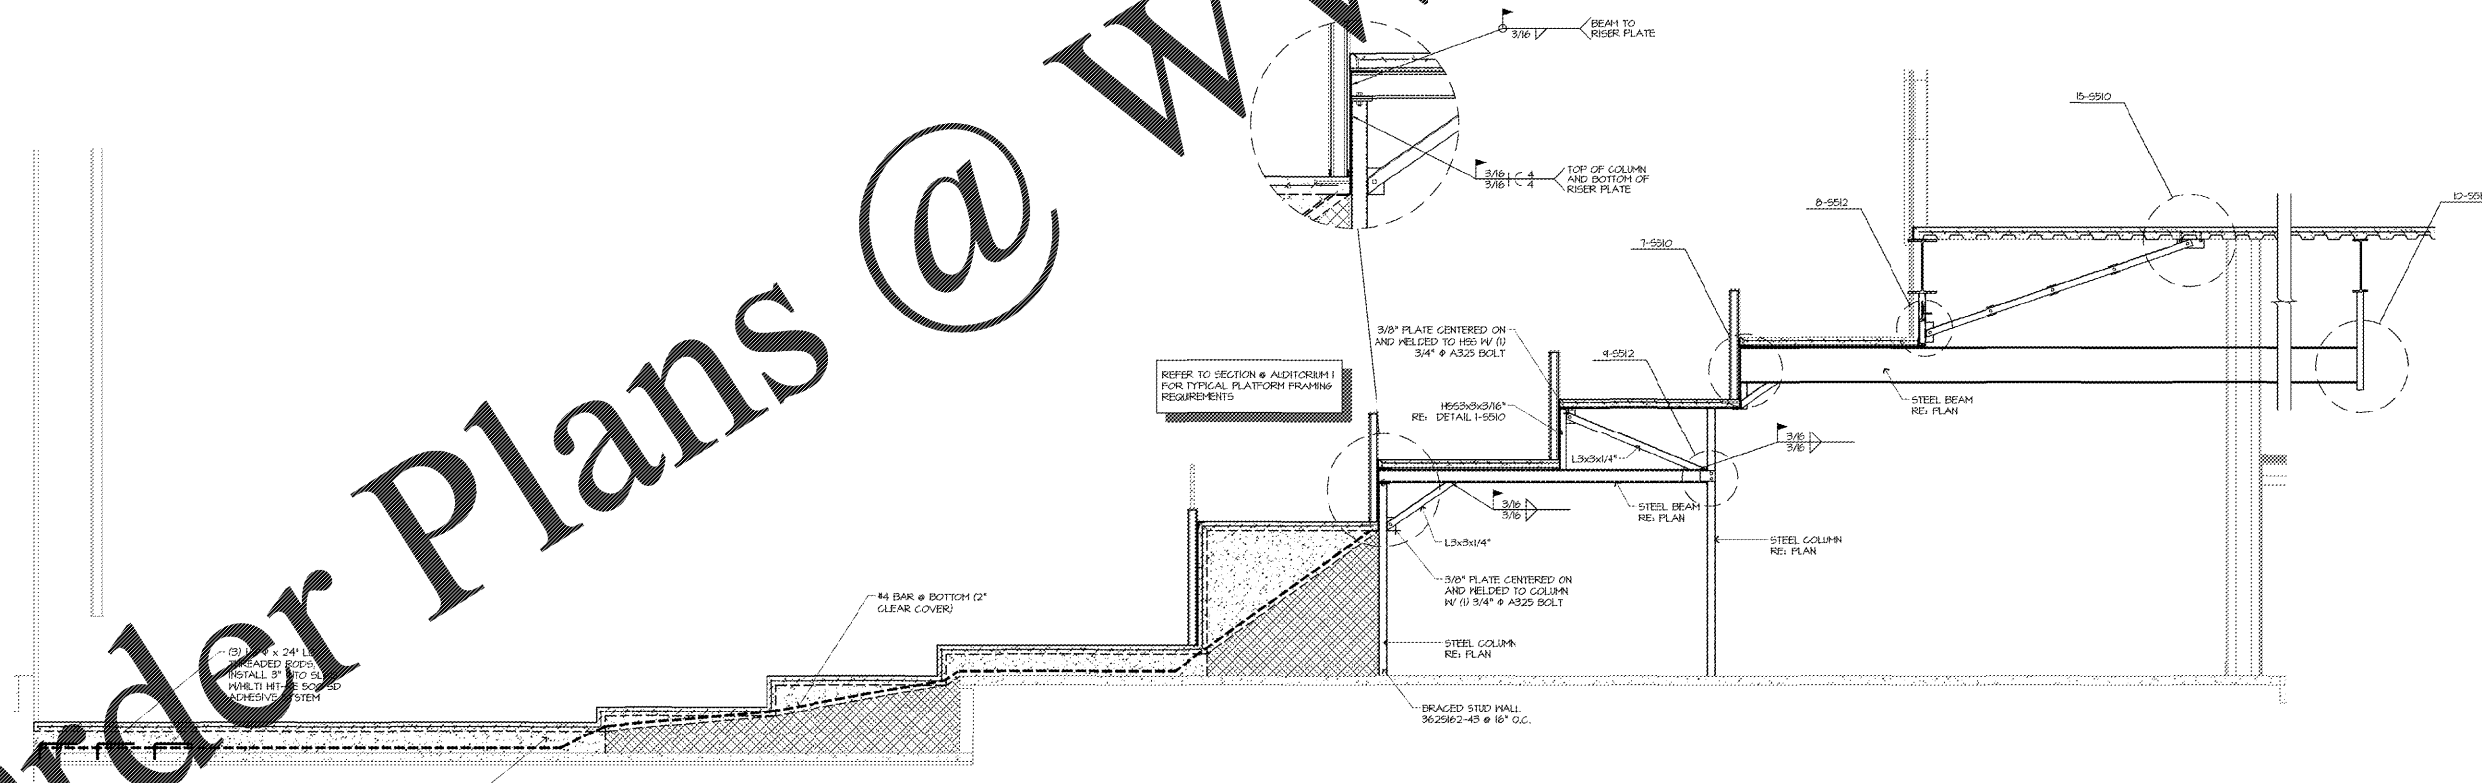

1 SECTION @ AUDITORIUM 4
 SCALE: 3/8" = 1'-0"

Order Plans @ www.LDILine.com