


Richard M. Schmitt
Consulting Engineers, L.L.C.
4111 North 11th Avenue
North Kansas City, MO 64116
Phone: (816) 451-4522
Fax: (816) 421-1625
www.rmschmitt.com
MISS JOB NUMBER: 2017-2911

SHEET LEGEND

0000	GENERAL INFORMATION & OTHER DETAILS
1000	FLOOR PLANS & CEILING PLANS
2000	ARCHITECTURAL DETAILS
3000	MECHANICAL PLANS
4000	ELECTRICAL PLANS
5000	PLUMBING PLANS
6000	STRUCTURAL PLANS
7000	FOUNDATION PLANS
8000	MECHANICAL EQUIPMENT & UTILITIES
9000	ADDITIONAL INFORMATION

AMC MADISON YARDS 8
AMC NEW BUILD
805 MEMORIAL DR SE
ATLANTA, GA 30316

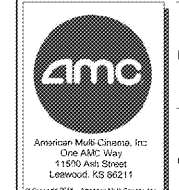


No.	Date	Description

Project Issue Date: 05/22/2018


KEY PLAN:

SHEET TITLE:
AUDITORIUM SECTIONS

SHEET NUMBER:
S504

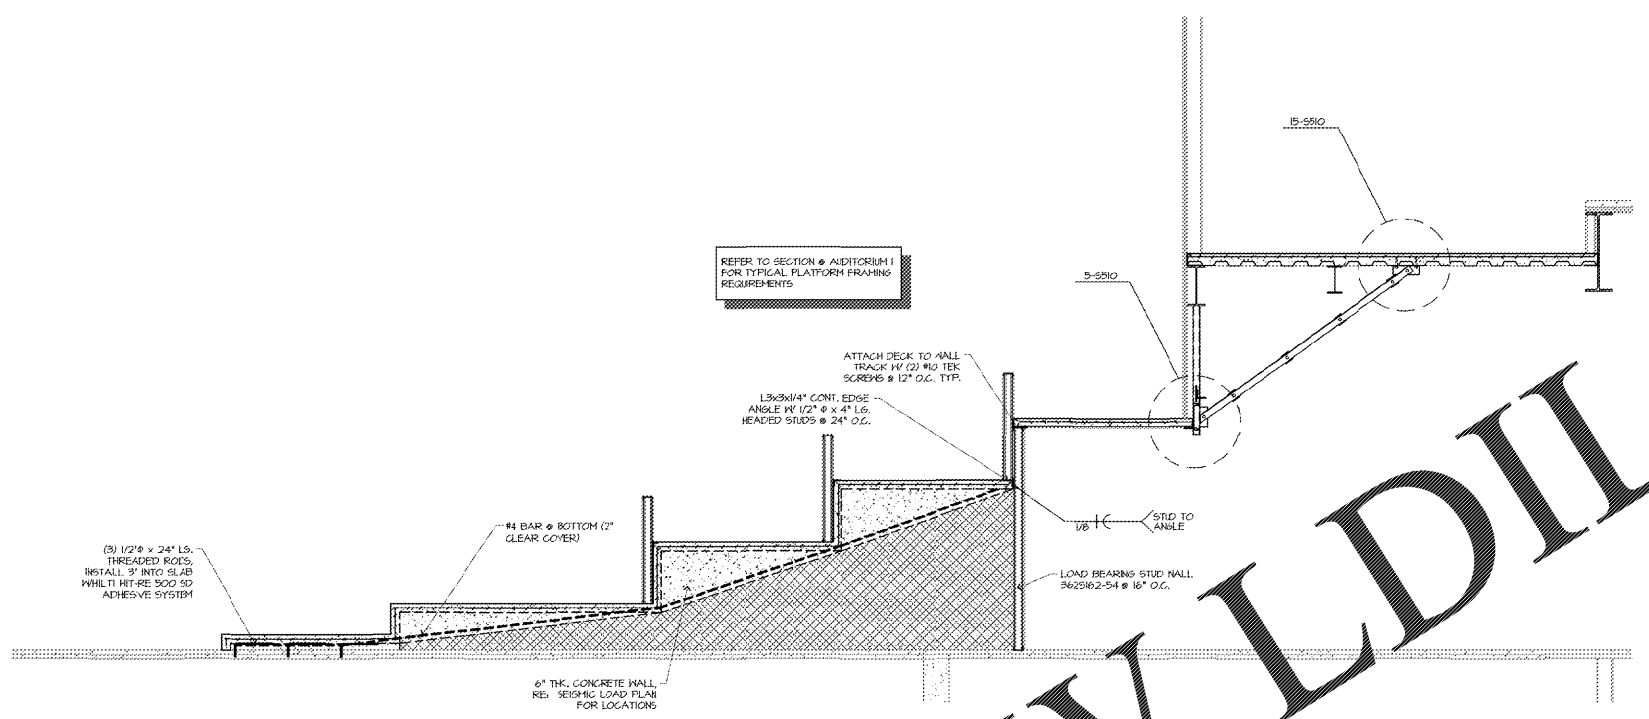

2 SECTION @ AUDITORIUM 7
SCALE: 3/8" = 1'-0"

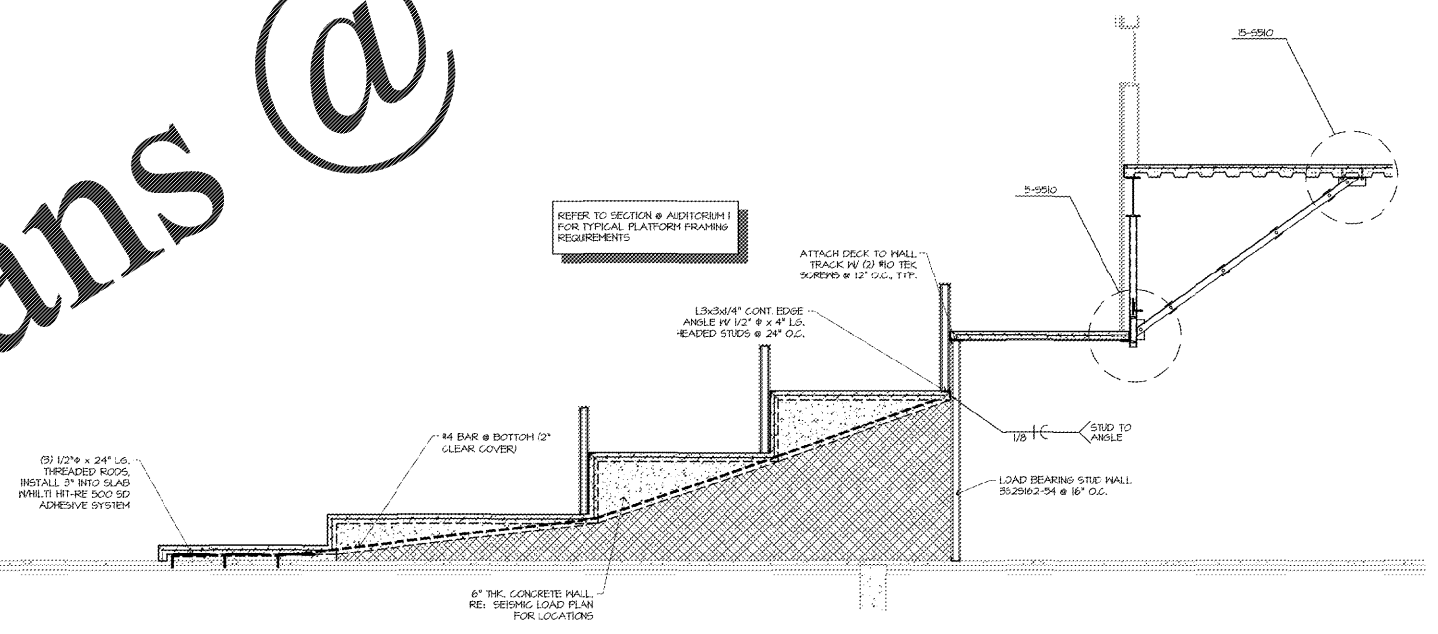

1 SECTION @ AUDITORIUM 6
SCALE: 3/8" = 1'-0"

Order Plans @ www.LDILine.com