



2 NOT USED

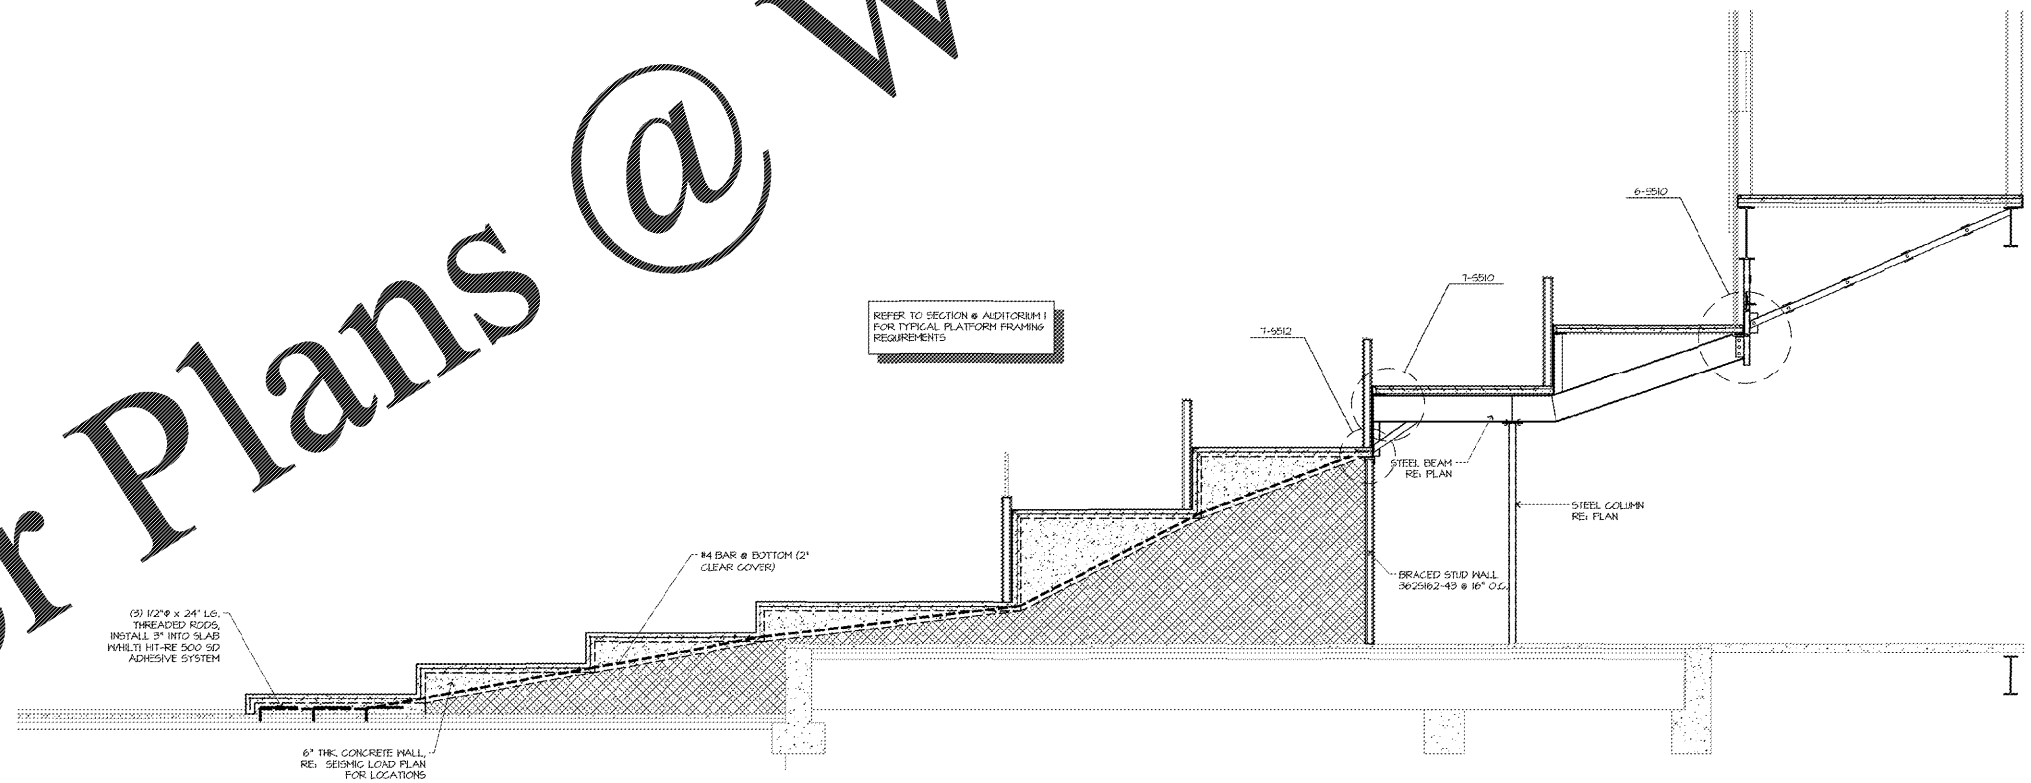

1 SECTION @ AUDITORIUM 8  
SCALE: 3/8" = 1'-0"

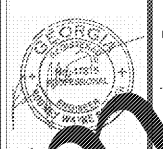

Robert S. Schmidt  
Consulting Engineers, L.L.C.  
111 East 11th Avenue  
North Kansas City, MO 64116  
Phone: (816) 487-4232  
Fax: (816) 421-1925  
www.rschmidtllc.com  
NCS JCS NUMBER: 2017-2313  
© 2017 Robert S. Schmidt Consulting Engineers, L.L.C.

SHEET LEGEND

000%	GENERAL INFORMATION & SCHEDULE
010%	GENERAL NOTES & DETAILS
020%	FLOOR PLANS & CEILING PLANS
030%	SECTION & ELEVATION DETAILS
040%	FOUNDATION DETAILS
050%	MECHANICAL & ELECTRICAL DETAILS
060%	MECHANICAL & ELECTRICAL DETAILS
070%	MECHANICAL & ELECTRICAL DETAILS
080%	MECHANICAL & ELECTRICAL DETAILS
090%	MECHANICAL & ELECTRICAL DETAILS

SYMBOLS:  
S: STRUCTURAL  
M: MECHANICAL  
P: PLUMBING  
E: ELECTRICAL  
ME: MECHANICAL/ELECTRICAL  
PE: PLUMBING/ELECTRICAL  
CE: CEILING/ELECTRICAL

AMC MADISON YARDS 8  
AMC NEW BUILD  
805 MEMORIAL DR SE  
ATLANTA, GA 30316



No.	Date	Description

Project Issue Date: 05/22/2018

KEY PLAN:

SHEET TITLE:  
AUDITORIUM SECTIONS

SHEET NUMBER:  
S505