

U
T
S
R
Q
P
N
M
L
K
J
H
G
F
E
D
C
B
A

PLUMBING GENERAL NOTES
A. REFER TO SHEET P100 FOR PLUMBING GENERAL NOTES.

FIRE PROTECTION GENERAL NOTES
1. REFER TO SHEET P100 FOR FIRE PROTECTION GENERAL NOTES.


PLUMBING PLAN NOTES
1. PROVIDE NEW FREEZELESS WALL HYDRANT WITH 3/4" CW. SEAL WALL PENETRATION WEATHER TIGHT.



ENGINEERING
Gibbons, Drake, Scott, Inc.
1001 E. 6th Street, Suite 100
Buckhead, Atlanta GA 30318
Phone: (404) 525-1790
Fax: (404) 525-1207
www.gdsai.com
CREDENTIAL NO. PE013488

SHEET LEGEND

GEN: GENERAL INFORMATION
SCALE OF WORK
ELEC: ELECTRICAL
ME: MECHANICAL
P: PLUMBING
ES: ELECTRICAL
W: WATERWORKS
S: SANITATION
F: FINISHING & EQUIPMENT

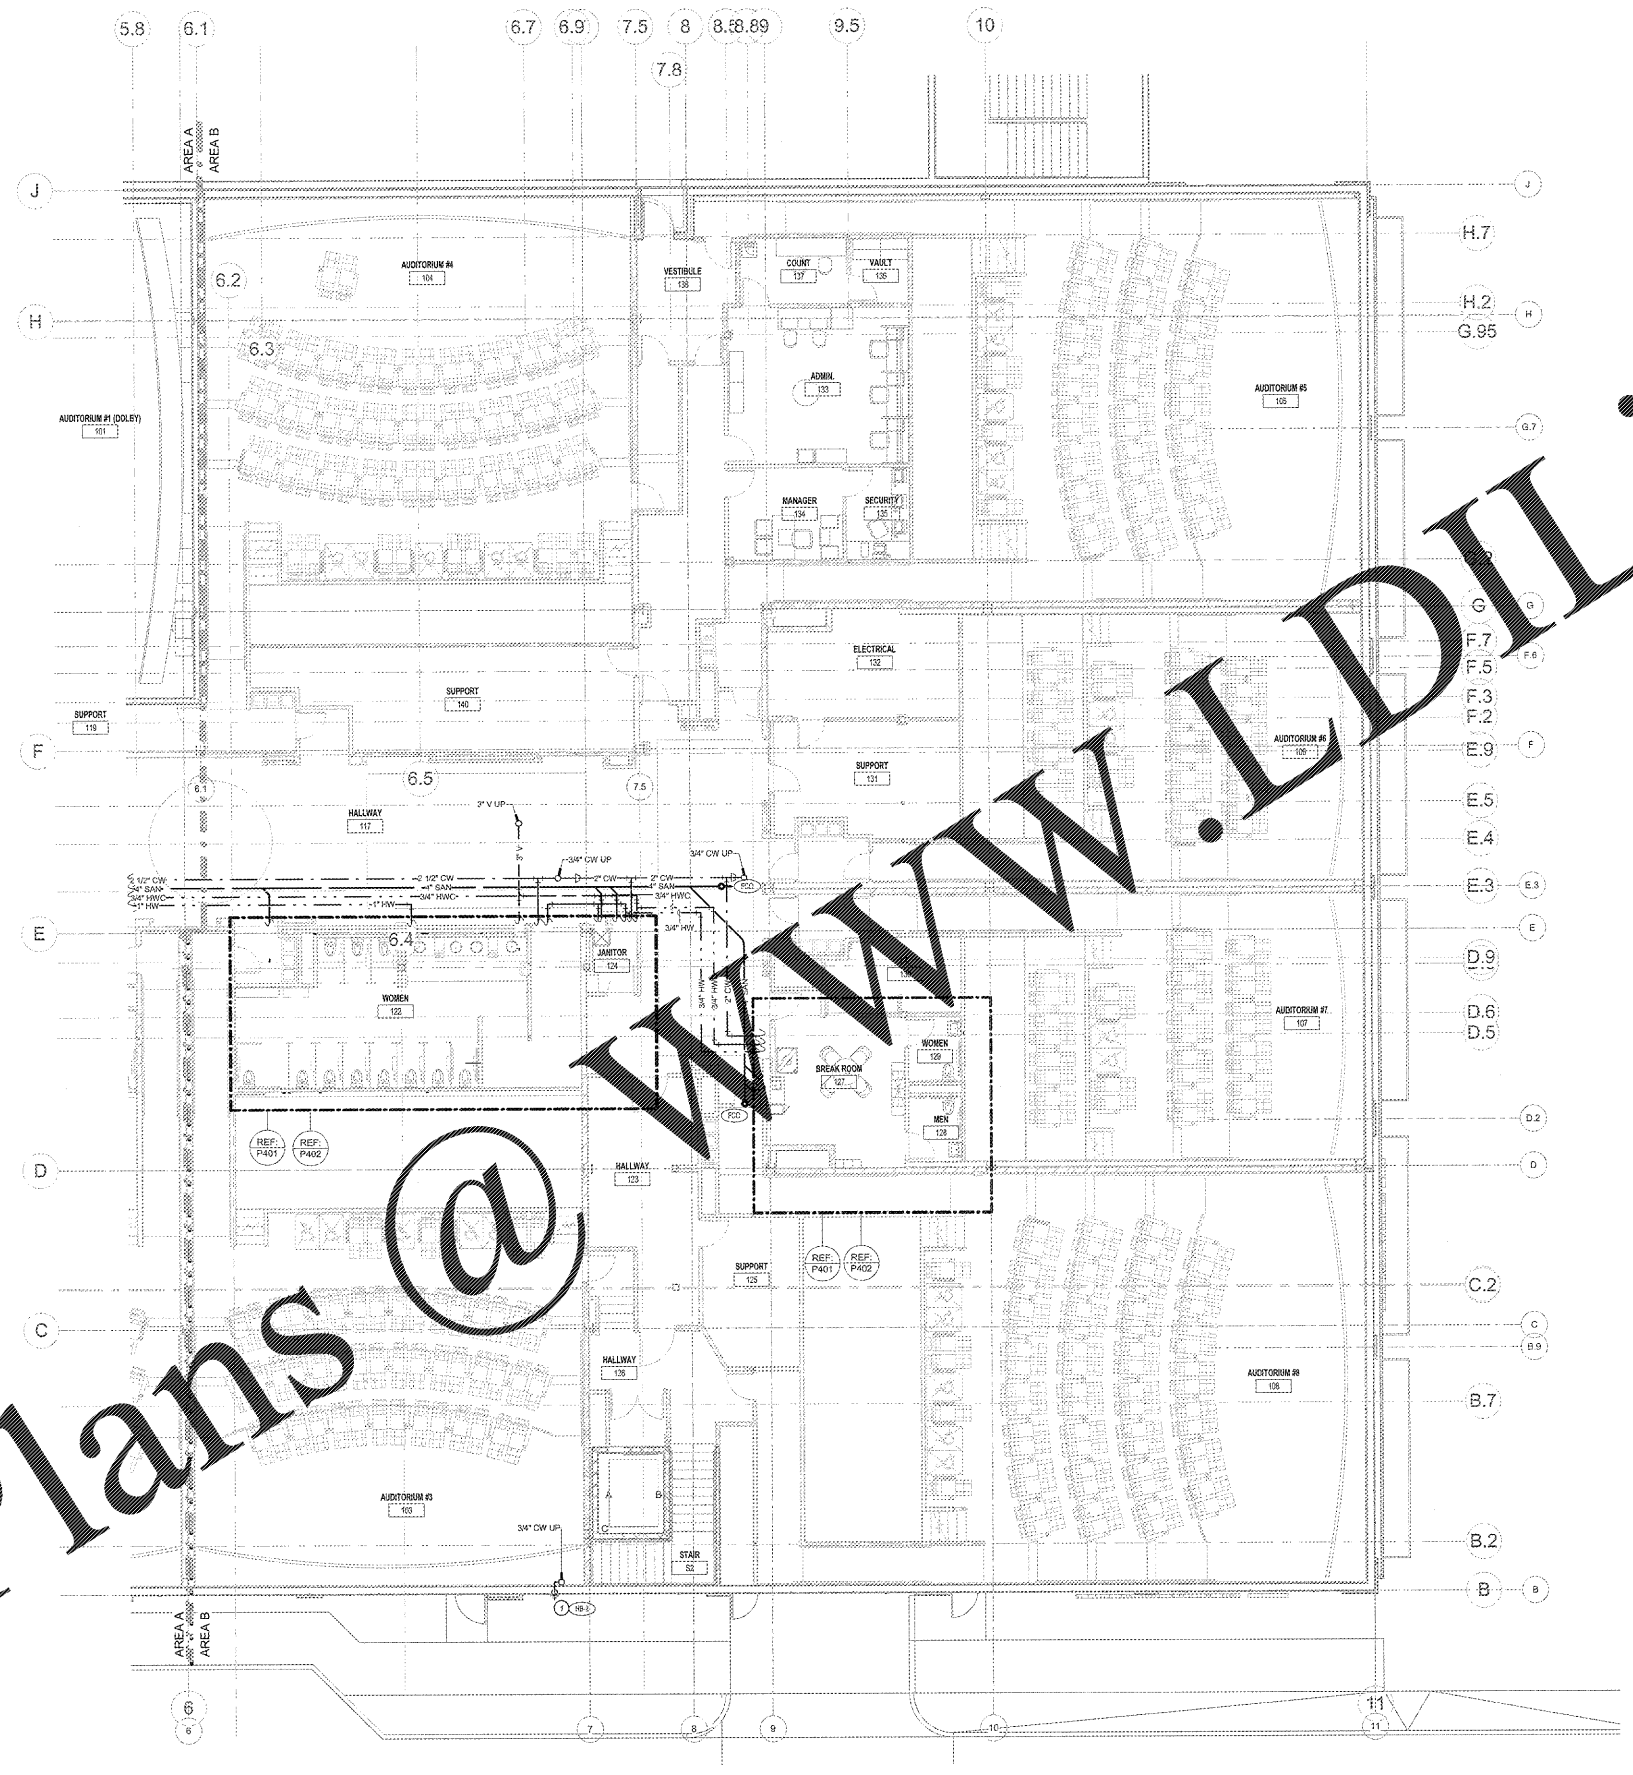


ENTRY LEVEL AREA B PLUMBING PLAN
1/8" = 1'-0"

THIS DRAWING IS A PART OF AN AGREEMENT BETWEEN THE CONTRACTOR AND THE CLIENT. IT IS THE PROPERTY OF THE CONTRACTOR AND IS NOT TO BE REPRODUCED OR TRANSMITTED IN ANY FORM OR BY ANY MEANS, ELECTRONIC OR MECHANICAL, INCLUDING PHOTOCOPYING, RECORDING, OR BY ANY INFORMATION STORAGE AND RETRIEVAL SYSTEM. WITHOUT THE WRITTEN PERMISSION OF THE CONTRACTOR. ANY UNAUTHORIZED USE OF THIS DRAWING IS STRICTLY PROHIBITED AND WILL BE CONSIDERED A VIOLATION OF THE CONTRACT. THE CONTRACTOR SHALL BE RESPONSIBLE FOR OBTAINING ALL NECESSARY PERMITS AND APPROVALS FROM THE APPROPRIATE AGENCIES. THE CONTRACTOR SHALL BE RESPONSIBLE FOR OBTAINING ALL NECESSARY PERMITS AND APPROVALS FROM THE APPROPRIATE AGENCIES. THE CONTRACTOR SHALL BE RESPONSIBLE FOR OBTAINING ALL NECESSARY PERMITS AND APPROVALS FROM THE APPROPRIATE AGENCIES. THE CONTRACTOR SHALL BE RESPONSIBLE FOR OBTAINING ALL NECESSARY PERMITS AND APPROVALS FROM THE APPROPRIATE AGENCIES.


Order Plans @ www.LDLine.com

www.LDLine.com

MADISON YARDS 8
AMC NEW BUILD
905 MEMORIAL DRIVE SE
ATLANTA, GA 30316

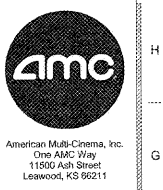

No.	Date	Description

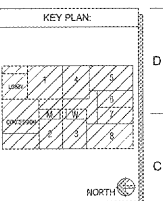

SHEET TITLE:
ENTRY LEVEL AREA-B PLBG PLAN

SHEET NUMBER:
P102