

PLUMBING GENERAL NOTES
 A. REFER TO SHEET P101 FOR PLUMBING GENERAL NOTES.

FIRE PROTECTION GENERAL NOTES
 1. REFER TO SHEET P100 FOR FIRE PROTECTION GENERAL NOTES.

PLUMBING PLAN NOTES Ⓞ



ENGINEERING
 Gibbons, Drake, Scott, Inc.
 3201 E. 63rd Street, Suite 100
 Roswell, Georgia 30076
 Phone: (404) 515-1799
 Fax: (404) 515-2467
 www.gds.com
 LICENSE NO. 150324898


SHEET LEGEND

GENERAL INFORMATION
 NTPD: NOTES
 A: ARCHITECTURE
 E: ELECTRICAL
 M: MECHANICAL
 P: PLUMBING
 S: STRUCTURAL
 W: WATERWORKS

MADISON YARDS 8
 AMC NEW BUILD
 905 MEMORIAL DRIVE SE
 ATLANTA, GA 30316




No.	Date	Description

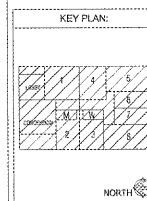

SHEET TITLE:
 PROJECTION LEVEL AREA-B
 PLBG PLAN

SHEET NUMBER:
 P104

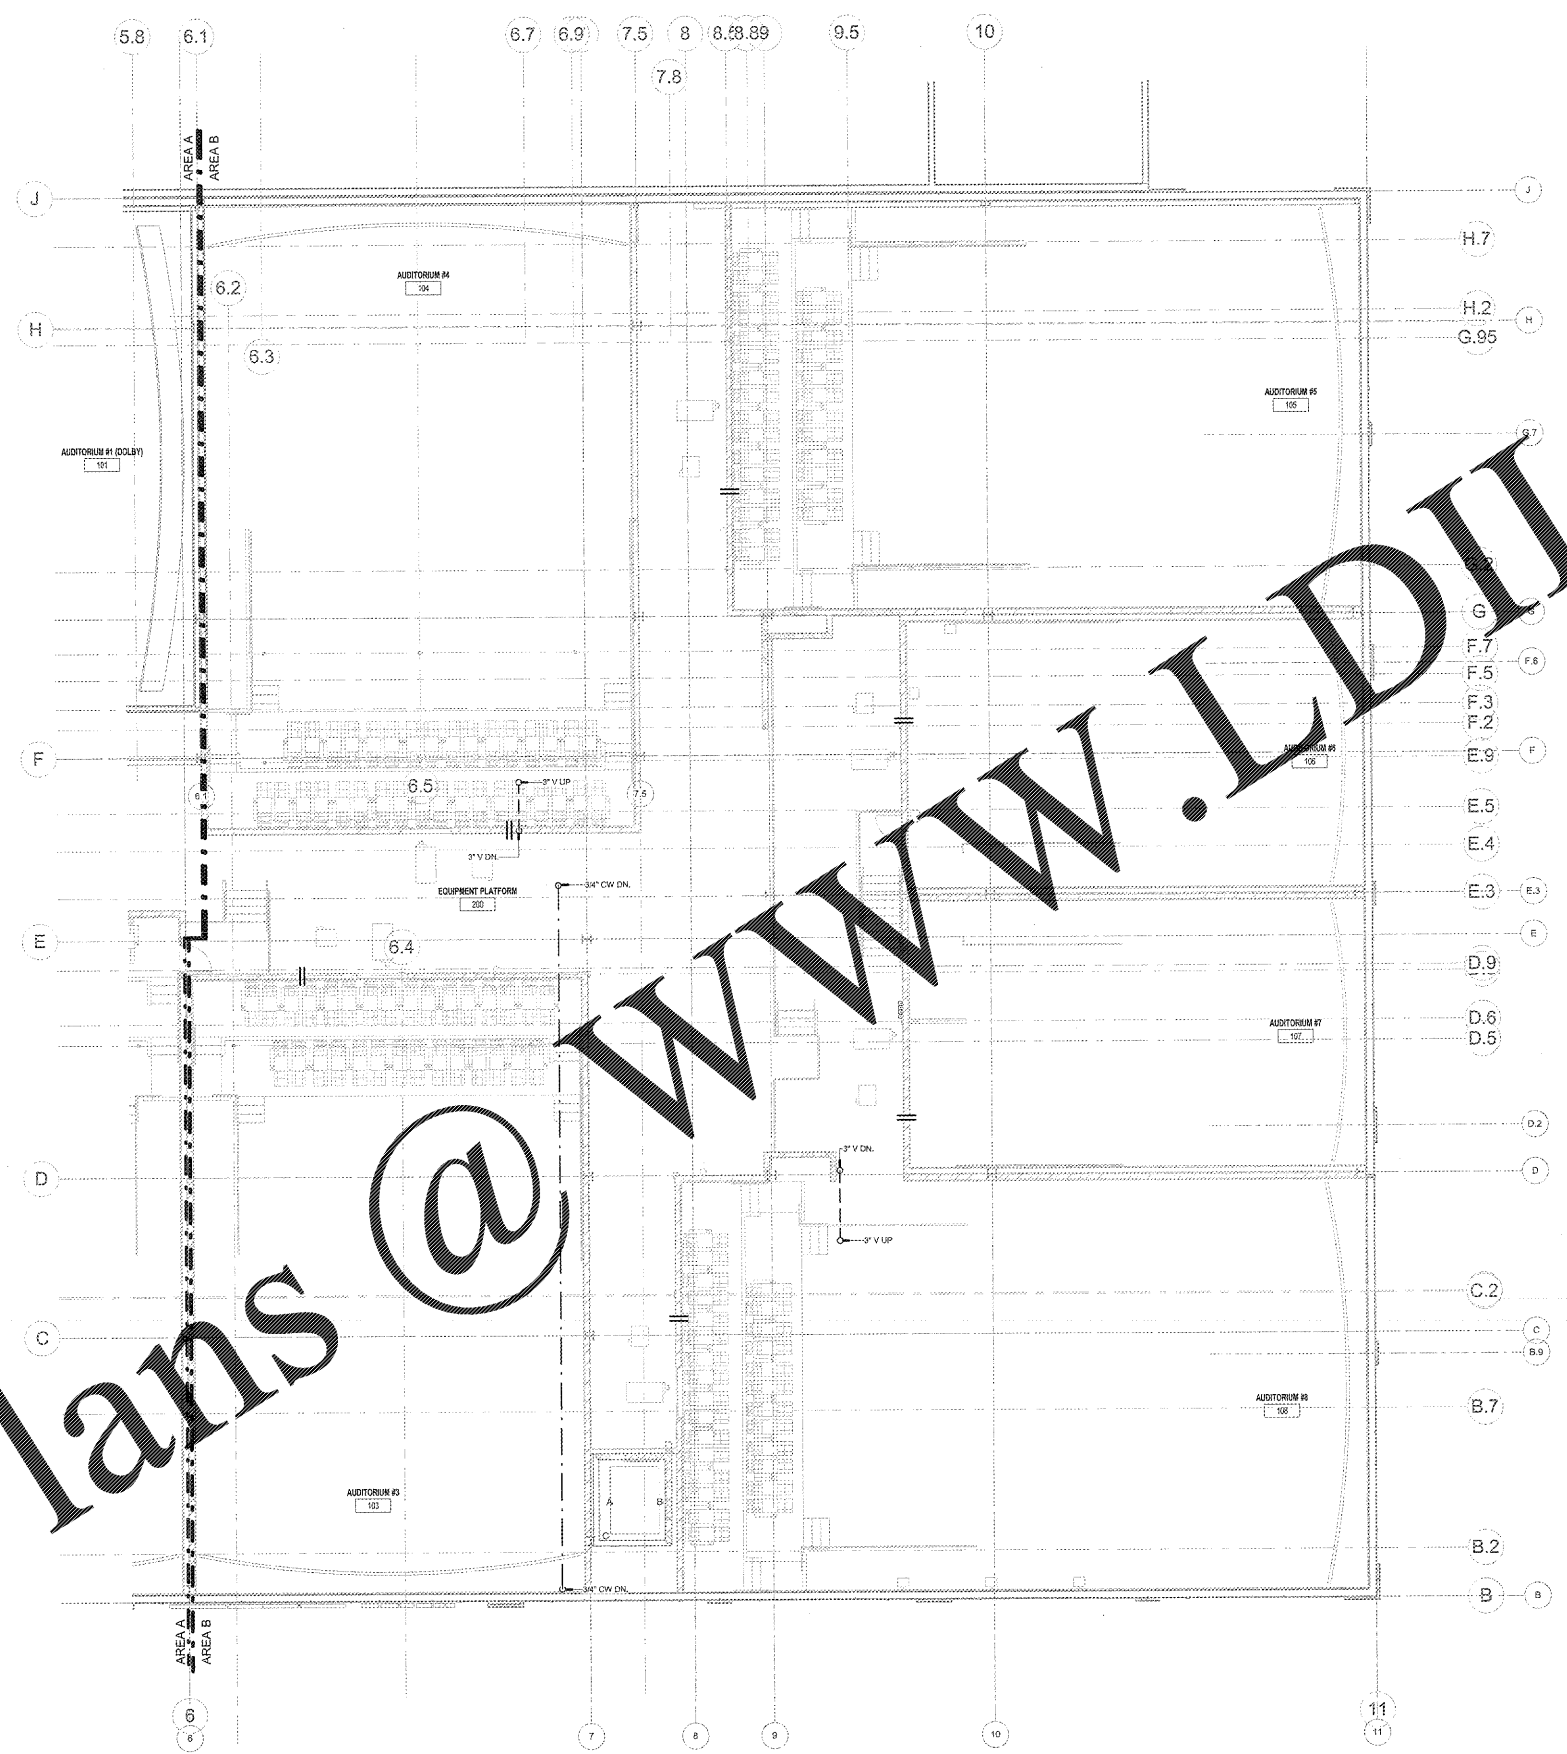

PROJECTION LEVEL AREA B PLUMBING PLAN
 1/8" = 1'-0"

THIS DRAWING IS A PART OF A CONTRACT AND SHALL BE USED ONLY FOR THE PROJECT AND SITE SPECIFICALLY IDENTIFIED THEREIN. IT IS NOT TO BE REPRODUCED, COPIED, OR TRANSMITTED IN ANY FORM OR BY ANY MEANS, ELECTRONIC OR MECHANICAL, INCLUDING PHOTOCOPYING, RECORDING, OR BY ANY INFORMATION STORAGE AND RETRIEVAL SYSTEM, WITHOUT THE WRITTEN PERMISSION OF THE ENGINEER OF RECORD. ANY REPRODUCTION OR TRANSMISSION OF THIS DRAWING WITHOUT THE WRITTEN PERMISSION OF THE ENGINEER OF RECORD SHALL BE AT THE USER'S SOLE RISK AND WITHOUT LIABILITY TO THE ENGINEER OF RECORD. THE ENGINEER OF RECORD SHALL NOT BE RESPONSIBLE FOR ANY DAMAGE TO PERSONS OR PROPERTY CAUSED BY THE USE OF THIS DRAWING. THE USER SHALL BE RESPONSIBLE FOR OBTAINING ALL NECESSARY PERMITS AND APPROVALS FROM THE APPROPRIATE AGENCIES. THE ENGINEER OF RECORD SHALL NOT BE RESPONSIBLE FOR ANY DAMAGE TO PERSONS OR PROPERTY CAUSED BY THE USE OF THIS DRAWING. THE USER SHALL BE RESPONSIBLE FOR OBTAINING ALL NECESSARY PERMITS AND APPROVALS FROM THE APPROPRIATE AGENCIES.

Order Plans @ www.LDILine.com