

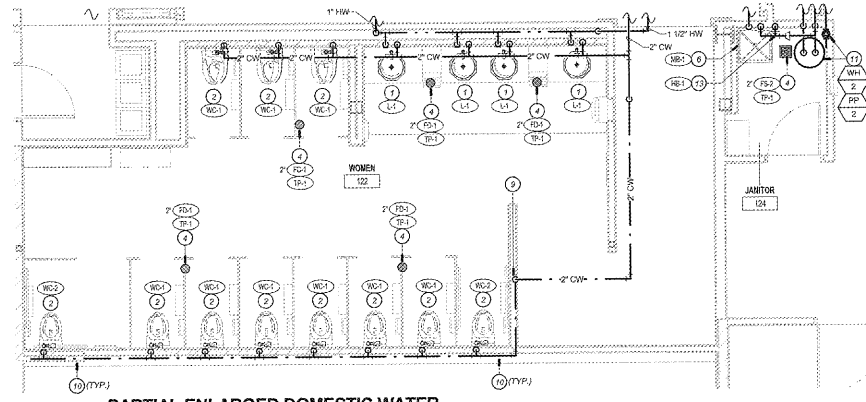



PARTIAL ENLARGED DOMESTIC WATER PLUMBING PLAN - PATRON USE MENS AND FAMILY RESTROOMS

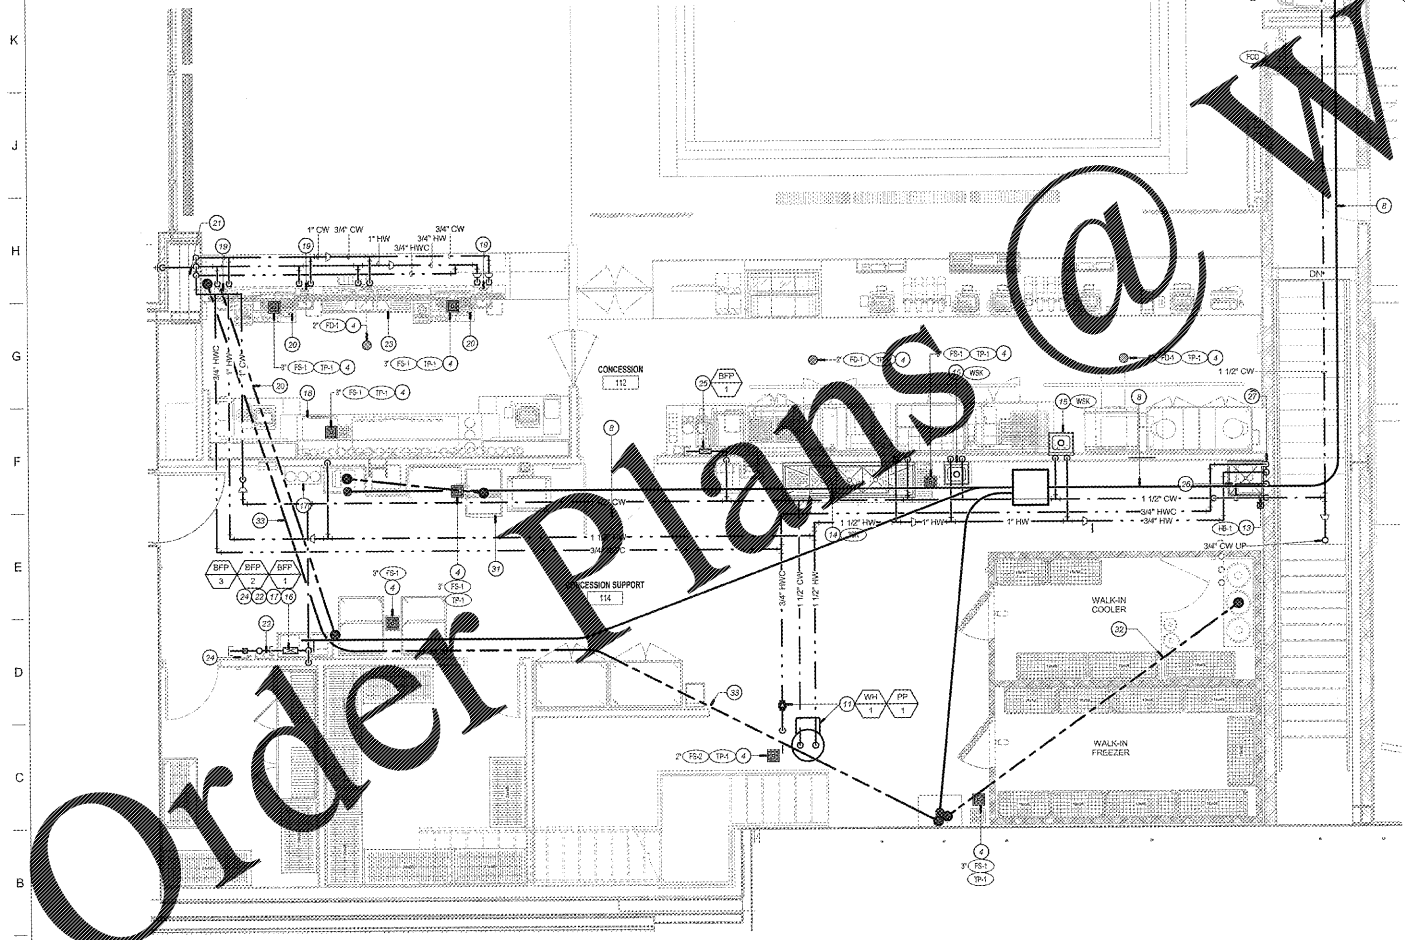

PARTIAL ENLARGED DOMESTIC WATER PLUMBING PLAN - PATRON USE WOMENS RESTROOMS

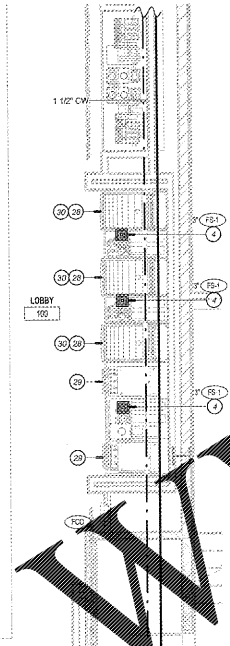

PARTIAL ENLARGED DOMESTIC WATER PLUMBING PLAN - MACGUFFINS, CONCESSION, CONCESSION SUPPORT

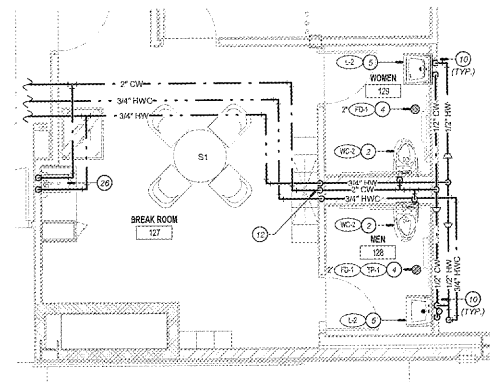

PARTIAL ENLARGED DOMESTIC WATER PLUMBING PLAN - EMPLOYEE USE RESTROOMS

PLUMBING GENERAL NOTES

- 1. INSTALL NEW FAUCET ON NEW LAVATORY BASIN. INSTALL 800-1 ON HW SUPPLY TO FAUCET. ROUTE THE HW DOWN INSIDE WALL BEHIND LAVATORIES AT THE STOP VALVE ELEVATION. CONNECT TO NEW HW PIPE ABOVE WALL FOR LAVATORIES. CONNECT CW AND WASTE PIPING TO NEW PLUMBING CONNECTIONS AT WALL. PROVIDE NEW STOP VALVES AT WALL. MOUNT PIPING FOR NEW ARRANGEMENT.

PLUMBING PLAN NOTES

- 1. INSTALL NEW LAVATORY WITH 12" HW AND 12" CW. CONNECT TO NEW HW AND CW CONNECTIONS AT WALL. INSTALL 800-1 ON HW SUPPLY TO FAUCET.



ENGINEERING  
T.M.L. SCOTT  
Professional Engineer  
No. 10000  
State of Georgia

SHEET LEGEND table with columns for symbol and description.

MADISON YARDS 8  
AMC NEW BUILD  
905 MEMORIAL DRIVE SE  
ATLANTA, GA 30316



Table with columns: No., Date, Description.



SHEET TITLE  
ENLARGED PLUMBING FLOOR PLANS  
SHEET NUMBER  
P402

Order Plans @

WWW.LDILLING.COM

THIS DRAWING IS A SINGLE PART OF AN UNLIMITED SERIES OF DRAWINGS FOR THE PROJECT. THE USER SHALL BE RESPONSIBLE FOR OBTAINING ALL NECESSARY PERMITS AND APPROVALS FROM THE LOCAL BUILDING DEPARTMENT AND ALL OTHER AGENCIES INVOLVED IN THE PROJECT. THE USER SHALL BE RESPONSIBLE FOR OBTAINING ALL NECESSARY PERMITS AND APPROVALS FROM THE LOCAL BUILDING DEPARTMENT AND ALL OTHER AGENCIES INVOLVED IN THE PROJECT. THE USER SHALL BE RESPONSIBLE FOR OBTAINING ALL NECESSARY PERMITS AND APPROVALS FROM THE LOCAL BUILDING DEPARTMENT AND ALL OTHER AGENCIES INVOLVED IN THE PROJECT.