


AMC - Madison Yards 8


ITEM	QTY	DESCRIPTION	PROVIDED BY
41	1	DESK SHELL 30" X 60" X 28" H. (34 MODESTY PANEL)	OFFICE FURN. VENDOR
42	1	DESK SHELL 30" X 72" X 28" H. (34 MODESTY PANEL)	OFFICE FURN. VENDOR
43	1	DESK SHELL 30" X 120" X 28" H. (34 MODESTY PANEL)	OFFICE FURN. VENDOR
44	1	DESK SHELL 30" X 120" X 28" H. (34 MODESTY PANEL)	OFFICE FURN. VENDOR
45	1	DESK SHELL 30" X 120" X 28" H. (34 MODESTY PANEL)	OFFICE FURN. VENDOR
100	1	DESK SHELL 30" X 120" X 28" H. (34 MODESTY PANEL)	OFFICE FURN. VENDOR

OFFICE EQUIPMENT SCHEDULE


ITEM	QTY	DESCRIPTION	NAME	MODEL	GENERAL NOTES	TYPE	VOLTS	PH	KW	AMPS	W/REQ	CONC. HT.	REMARKS
101	1	STANDARD LAMINATE COUNTER TOP	UNIVERSAL	CUSTOM	RELI. IS. GRABETS APPROX. EVENLY SPACED ACROSS SURFACE. NEAR WALL. PROVIDE 1X NAILER AT WALL. PROVIDE AM BRACKETS OR EQUAL FOR INTERMEDIATE SUPPORTS AT 36" MAX SPACING EACH WAY. PROVIDE CROMMETS FOR FIELD INSTALLATION.	DR	120	1	15				RE ELECTRICAL PLANS. SEE ESBY 4P
102	1	STANDARD LAMINATE COUNTER TOP	UNIVERSAL	CUSTOM	RELI. IS. GRABETS APPROX. EVENLY SPACED ACROSS SURFACE. NEAR WALL. PROVIDE 1X NAILER AT WALL. PROVIDE AM BRACKETS OR EQUAL FOR INTERMEDIATE SUPPORTS AT 36" MAX SPACING EACH WAY. PROVIDE CROMMETS FOR FIELD INSTALLATION.	DR	120	1	15				RE ELECTRICAL PLANS. SEE ESBY 4P
103	1	STANDARD LAMINATE COUNTER TOP	UNIVERSAL	CUSTOM	RELI. IS. GRABETS APPROX. EVENLY SPACED ACROSS SURFACE. NEAR WALL. PROVIDE 1X NAILER AT WALL. PROVIDE AM BRACKETS OR EQUAL FOR INTERMEDIATE SUPPORTS AT 36" MAX SPACING EACH WAY. PROVIDE CROMMETS FOR FIELD INSTALLATION.	DR	120	1	15				RE ELECTRICAL PLANS. SEE ESBY 4P
104	1	STANDARD LAMINATE COUNTER TOP	UNIVERSAL	CUSTOM	RELI. IS. GRABETS APPROX. EVENLY SPACED ACROSS SURFACE. NEAR WALL. PROVIDE 1X NAILER AT WALL. PROVIDE AM BRACKETS OR EQUAL FOR INTERMEDIATE SUPPORTS AT 36" MAX SPACING EACH WAY. PROVIDE CROMMETS FOR FIELD INSTALLATION.	DR	120	1	15				RE ELECTRICAL PLANS. SEE ESBY 4P
105	1	STANDARD LAMINATE COUNTER TOP	UNIVERSAL	CUSTOM	RELI. IS. GRABETS APPROX. EVENLY SPACED ACROSS SURFACE. NEAR WALL. PROVIDE 1X NAILER AT WALL. PROVIDE AM BRACKETS OR EQUAL FOR INTERMEDIATE SUPPORTS AT 36" MAX SPACING EACH WAY. PROVIDE CROMMETS FOR FIELD INSTALLATION.	DR	120	1	15				RE ELECTRICAL PLANS. SEE ESBY 4P
106	1	STANDARD LAMINATE COUNTER TOP	UNIVERSAL	CUSTOM	RELI. IS. GRABETS APPROX. EVENLY SPACED ACROSS SURFACE. NEAR WALL. PROVIDE 1X NAILER AT WALL. PROVIDE AM BRACKETS OR EQUAL FOR INTERMEDIATE SUPPORTS AT 36" MAX SPACING EACH WAY. PROVIDE CROMMETS FOR FIELD INSTALLATION.	DR	120	1	15				RE ELECTRICAL PLANS. SEE ESBY 4P
107	1	STANDARD LAMINATE COUNTER TOP	UNIVERSAL	CUSTOM	RELI. IS. GRABETS APPROX. EVENLY SPACED ACROSS SURFACE. NEAR WALL. PROVIDE 1X NAILER AT WALL. PROVIDE AM BRACKETS OR EQUAL FOR INTERMEDIATE SUPPORTS AT 36" MAX SPACING EACH WAY. PROVIDE CROMMETS FOR FIELD INSTALLATION.	DR	120	1	15				RE ELECTRICAL PLANS. SEE ESBY 4P
108	1	STANDARD LAMINATE COUNTER TOP	UNIVERSAL	CUSTOM	RELI. IS. GRABETS APPROX. EVENLY SPACED ACROSS SURFACE. NEAR WALL. PROVIDE 1X NAILER AT WALL. PROVIDE AM BRACKETS OR EQUAL FOR INTERMEDIATE SUPPORTS AT 36" MAX SPACING EACH WAY. PROVIDE CROMMETS FOR FIELD INSTALLATION.	DR	120	1	15				RE ELECTRICAL PLANS. SEE ESBY 4P
109	1	STANDARD LAMINATE COUNTER TOP	UNIVERSAL	CUSTOM	RELI. IS. GRABETS APPROX. EVENLY SPACED ACROSS SURFACE. NEAR WALL. PROVIDE 1X NAILER AT WALL. PROVIDE AM BRACKETS OR EQUAL FOR INTERMEDIATE SUPPORTS AT 36" MAX SPACING EACH WAY. PROVIDE CROMMETS FOR FIELD INSTALLATION.	DR	120	1	15				RE ELECTRICAL PLANS. SEE ESBY 4P
110	1	STANDARD LAMINATE COUNTER TOP	UNIVERSAL	CUSTOM	RELI. IS. GRABETS APPROX. EVENLY SPACED ACROSS SURFACE. NEAR WALL. PROVIDE 1X NAILER AT WALL. PROVIDE AM BRACKETS OR EQUAL FOR INTERMEDIATE SUPPORTS AT 36" MAX SPACING EACH WAY. PROVIDE CROMMETS FOR FIELD INSTALLATION.	DR	120	1	15				RE ELECTRICAL PLANS. SEE ESBY 4P

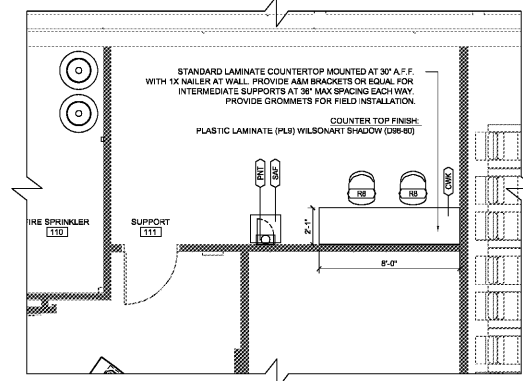


5 BOX OFFICE SUPPORT ROOM FURNITURE & OFFICE EQUIPMENT PLAN SCALE: 1/4" = 1'-0"

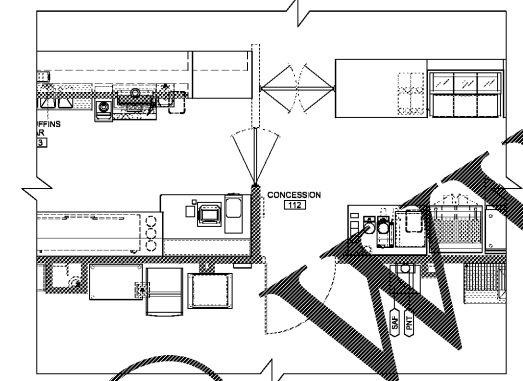


4 CONCESSION SUPPORT ROOM FURNITURE & OFFICE EQUIPMENT PLAN SCALE: 1/4" = 1'-0"

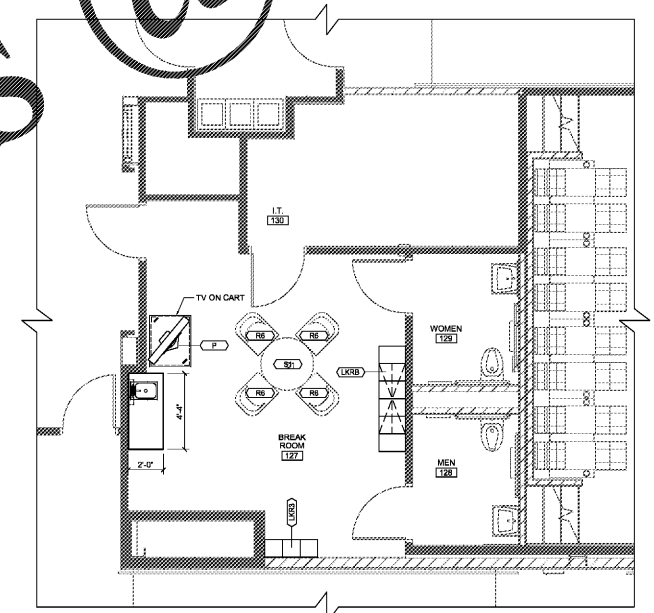

2 BREAK ROOM FURNITURE PLAN SCALE: 1/4" = 1'-0"

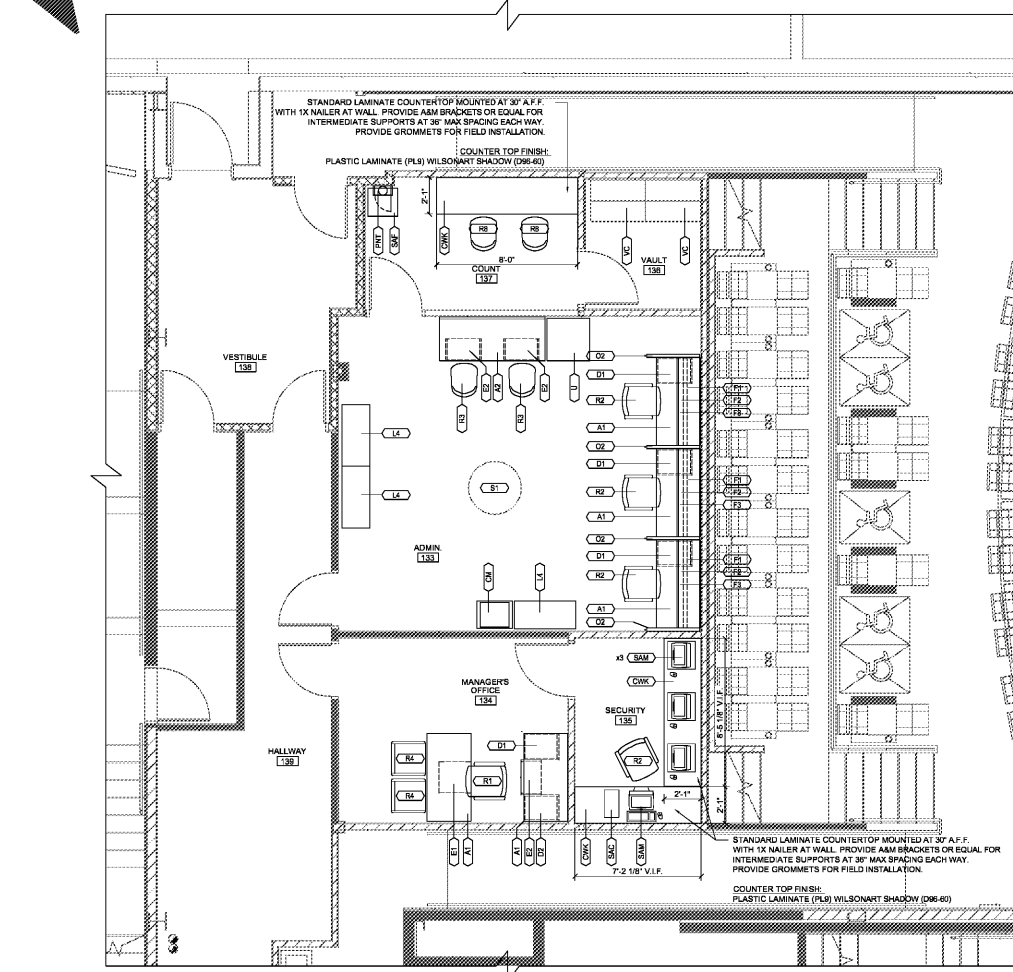

1 ADMIN., COUNT, VAULT, SECURITY ROOM & MANAGER'S OFFICE FURNITURE PLAN SCALE: 1/4" = 1'-0"

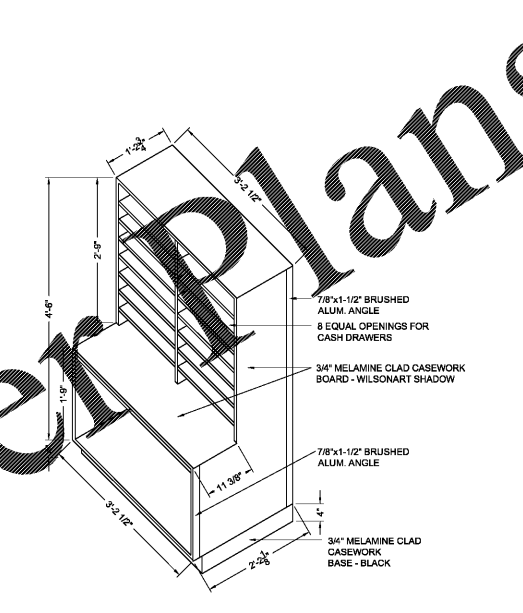

3 VAULT CASEWORK DETAIL SCALE: 3/4" = 1'-0"

Order Plans

environmentics inc

3000 SHELBY DRIVE, SUITE 100  
NORTH KENNESAW, GA 30144  
PH: (770) 422-7400 FAX: (770) 422-7401

SHEET LEGEND

AMC MADISON YARDS 8

AMC NEW BUILD  
905 MEMORIAL DRIVE SE  
ATLANTA, GA 30316

American Multi-Cinema, Inc.  
One AMC Way  
11500 Ash Street  
Leawood, KS 66211

REV DATE DESCRIPTION

KEY PLAN:

SHEET TITLE:  
OFFICE FURNITURE PLANS

SHEET NUMBER:  
FS150