


Auditorium #1
Partial Axonometric View

PLF Sheet Index

Architectural	Structural	Mechanical, Electrical, Plumbing
PLFG0 Specifications	PLFS0.1 General Notes	PLFME1 Symbols Legend & Specifications
PLFA0 Exiting Plans	PLFS0.2 Typical Details	PLFME2 Mechanical & Electrical Symbols Legend & Specifications
PLFA1 Floor Plan	PLFS0.3 Typical Details	PLFM1 Booth Mechanical Plan Schedules & Details
PLFA2 Reflected Ceiling Plan	PLFS0.4 Typical Details	PLFM2 Auditorium Mechanical Plan Booth Electrical Plans Schedules & Details
PLFA3 Projection Booth Plans & WHC Locations	PLFS0.5 Typical Details	PLFE1 Auditorium Power Plan
PLFA4 Sections	PLFS1.1 Auditorium Plan View	PLFE2 Auditorium Electrical Ceiling Grid Plan
PLFA5 Elevations	PLFS4.1 Screen Structure Front Isometric	PLFE3 Auditorium Electrical Ceiling Grid Plan
PLFA6 Speaker Blocking & Cove Lighting	PLFS4.2 Screen Structure Back Isometric	PLFE4 Auditorium & Entry Lighting Plan
PLFA7 Entry Portal Plans & Elevations	PLFS4.3 Screen Structure Support Details	
PLFA8 Entry Portal Details	PLFS4.4 Screen Structure Isometric Details	
PLFA9 Auditorium Details	PLFS4.5 Screen Speaker Mounting Details	
PLFA10 Auditorium Details	PLFS4.6 Screen Structure Shaker Details	
PLFA11 Seat Numbering Plan		
PLFA12 Finish Plans		

Annotations and Symbols

Detail Number	Graphic Symbol
Sheet Number	Name
Detail Number	Elevation
Detail Number	Door Number
Detail Number	Room Number
Detail Number	Room Name
Detail Number	Room Number
Detail Number	Revision Reference
Detail Number	Ceiling Height
Detail Number	Wall Type Tag
Detail Number	North Arrow
Detail Number	Scale
Detail Number	View Title

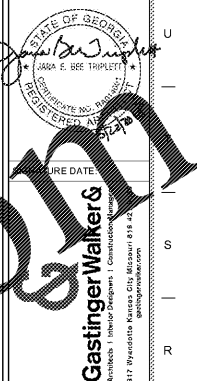

SHEET LEGEND

0000 GENERAL INFORMATION & SCOPE OF WORK
 1000 EXISTING AS-BUILT PLANS & DETAILS
 1001 FLOOR PLANS & CEILING PLANS
 1002 EXTERIOR & INTERIOR ELEVATIONS
 1003 BUILDING SECTIONS
 1004 ENLARGED PLANS
 1005 EXTERIOR & INTERIOR DETAILS
 1006 FLOOR SCHEDULES, ROOF DETAILS
 1007 HIGH SCHOOL SCHEDULES
 1008 AUDITORIUM BEST LINE SECTIONS

0100 STRUCTURAL
 0200 MECHANICAL
 0300 ELECTRICAL
 0400 WAITING AREAS
 0500 CASEWORK & EQUIPMENT
 0600 PLF AUDITORIUM

AMC MADISON YARDS 8

AMC NEW BUILD
 905 MEMORIAL DR SE
 ATLANTA, GA 30316



Project Issue Date: 05/23/2018


No.	Date	Description

KEY PLAN:

1	2	3	4	5
6	7	8	9	10
11	12	13	14	15
16	17	18	19	20

SHEET TITLE:
Auditorium #1
Exiting Plans

SHEET NUMBER:
PLFA0

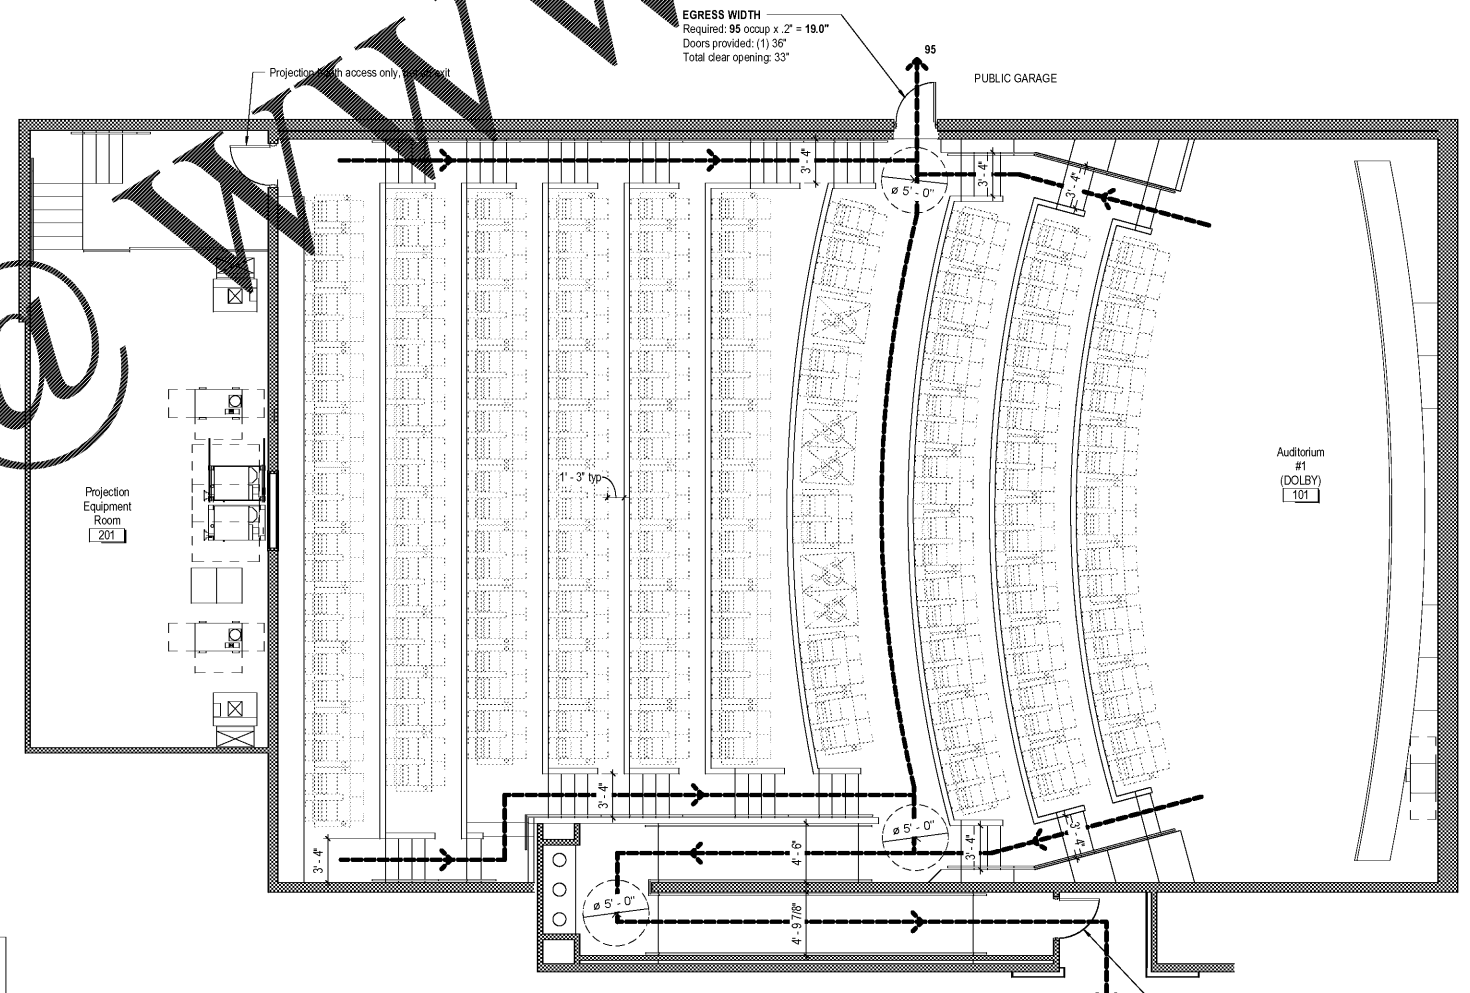

New Seat Count

Fixed	185
Accessible	5
Total	190

A7 Auditorium #1 - Exiting Plan
 3/16" = 1'-0"
 6 1/4" 26' 5 1/4"

Order Plans @ WWW.LDMLINE.COM