


STATE OF GEORGIA
JAMES P. TRIPLETT, JR.
LICENSE NO. 12426
REGISTERED PROFESSIONAL ENGINEER
CIVIL
EXPIRES 12/31/2019


SHEET LEGEND

GENERAL INFORMATION & SCOPE OF WORK
 N001: EXISTING AREA PLANS & DETAILS
 A1001: FLOOR PLANS & CEILING PLANS
 A2001: EXTERIOR & INTERIOR ELEVATIONS
 A3001: BUILDING SECTIONS
 A4001: RELATED PLANS
 A5001: EXTERIOR & INTERIOR DETAILS
 A6001: ROOF SCHEDULES, ROOF DETAILS
 A7001: MECHANICAL ROOM PLANS
 A8001: AUDITORIUM SEATING SECTIONS


SYMBOLS:
 ST: STRUCTURAL
 ME: MECHANICAL
 PL: PLUMBING
 EL: ELECTRICAL
 WT: WAITING ROOMS
 PE: CASEWORK & EQUIPMENT
 PLF: PLF AUDITORIUM

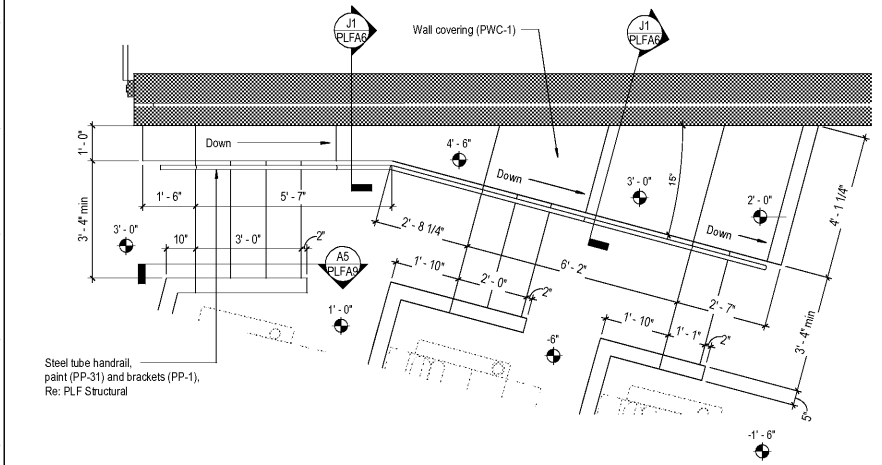

P1 Auditorium #1 - Buildout @ Front Steps
 PLFA1 1/2" = 1'-0"

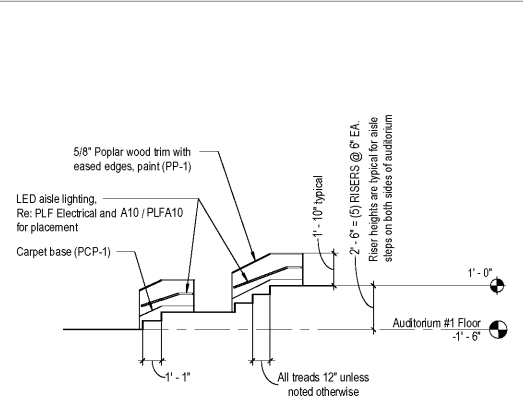


J4 Auditorium #1 - Section @ Aisle Stairs
 PA1 1/4" = 1'-0"

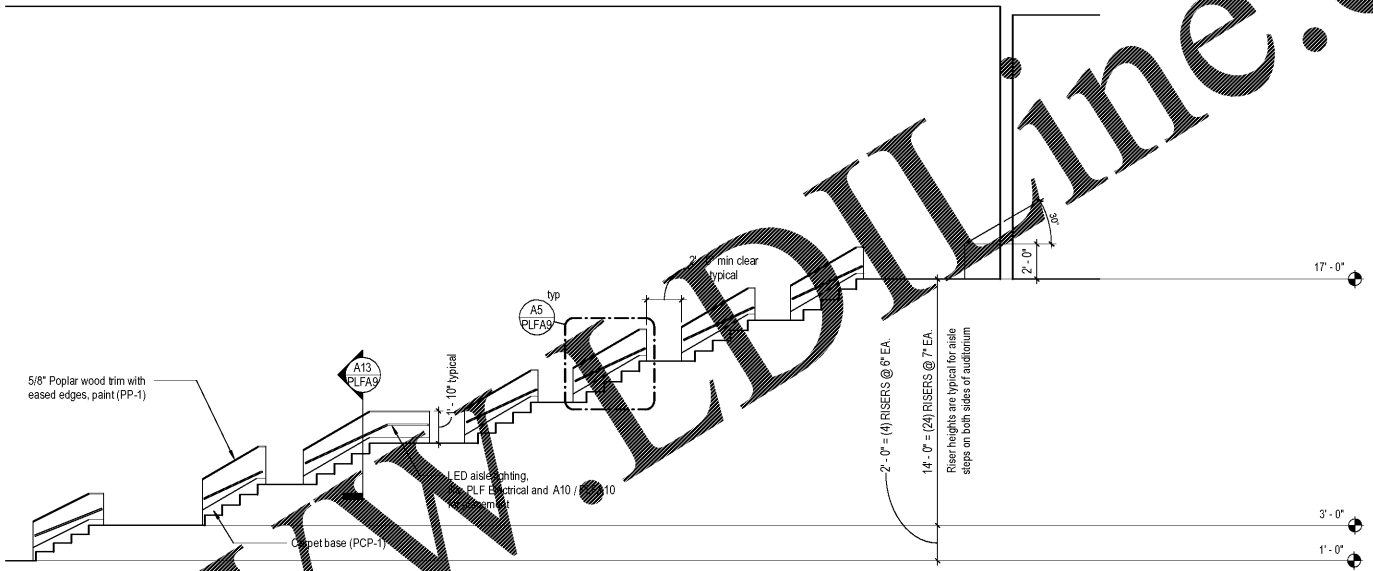

J8 Auditorium #1 - Section @ Aisle Stairs
 PA1 1/4" = 1'-0"

Confirm Projection/Port Windows with AMC prior to framing rough openings. Window layout shown received from Dolby titled: "2018-0403 0-DC AMC MADISON YARD 8 - PLAN SECTION-PRELIM" received 3 April 2018.
 Confirm ATMOS Design with AMC prior to installing & aiming speakers. ATMOS layout shown received from Dolby titled: "2018-0403 0-DC AMC MADISON YARD 8 - ATMOS LAYOUT-PRELIM" received 3 April 2018.

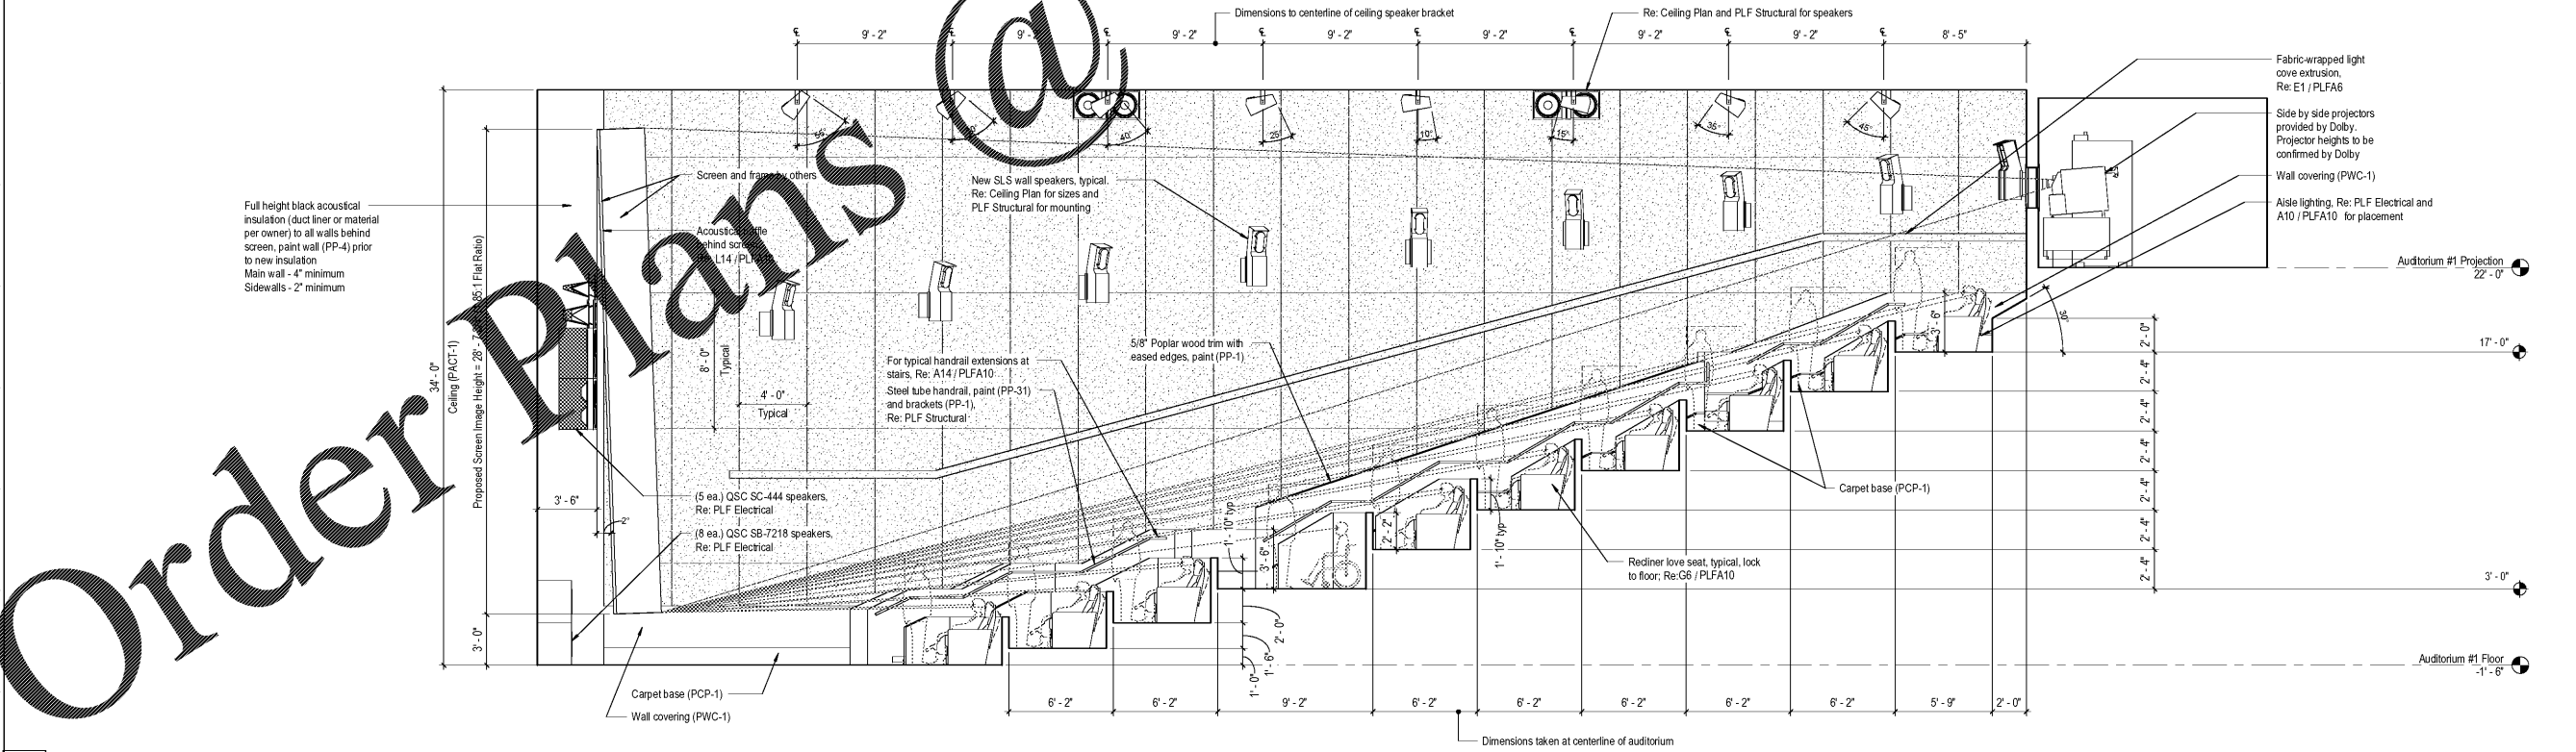

A1 Auditorium #1 - Section @ Centerline
 PA1 1/4" = 1'-0"

AMC MADISON YARDS 8

AMC NEW BUILD
 905 MEMORIAL DR SE
 ATLANTA, GA 30316

American Multi-Cinema, Inc.
 One AMC Way
 11500 Ash Street
 Lenexa, KS 66211
 © Copyright 2018 American Multi-Cinema, Inc.

No.	Date	Description

Project Issue Date: 05/22/2018

KEY PLAN:

1	2	3	4	5
6	7	8	9	10
11	12	13	14	15
16	17	18	19	20

SHEET TITLE:
 Auditorium #1 Sections

SHEET NUMBER:
 PLFA4

Order Plans @

WWW.LEDLINE.COM