


GENERAL NOTES:
 A. REFER TO SHEET PLFM FOR GENERAL NOTES.

PLAN NOTES:

1. PROVIDE CLEAR FLEXIBLE CALLOUS COMPOND BY DWP BETWEEN ALL DIFFUSERS AND GRILLES AND CEILING GRID TO PREVENT LOW FREQUENCY VIBRATION. CALK SHALL BE CONTINUOUS ALONG THE FOUR (4) EDGES OF THE DIFFUSER OR GRILLE. ALL EXCESS CALK SHALL BE REMOVED.
2. REFER TO DOMESTIC DEVELOPMENT SHEET M03 FOR CONTINUATION.
3. REFER TO DOMESTIC DEVELOPMENT SHEET M03 FOR GRILLE REGISTER 4 DIFFUSER SCHEDULE.
4. RETURN DUCT - PROVIDE 18x8 RETURN DUCT DOWN TO FLOOR BELOW. BOTTOM OF RETURN DUCT SHALL BE AT 6" AFF. PROVIDE 18x8 PERFORATED GRILLE ON FACE OF DUCT BELOW SCREEN. REFER TO DOMESTIC DEVELOPMENT SHEETS FOR RETURN GRILLE HOODS, IN OTHER AUDITORIUMS.

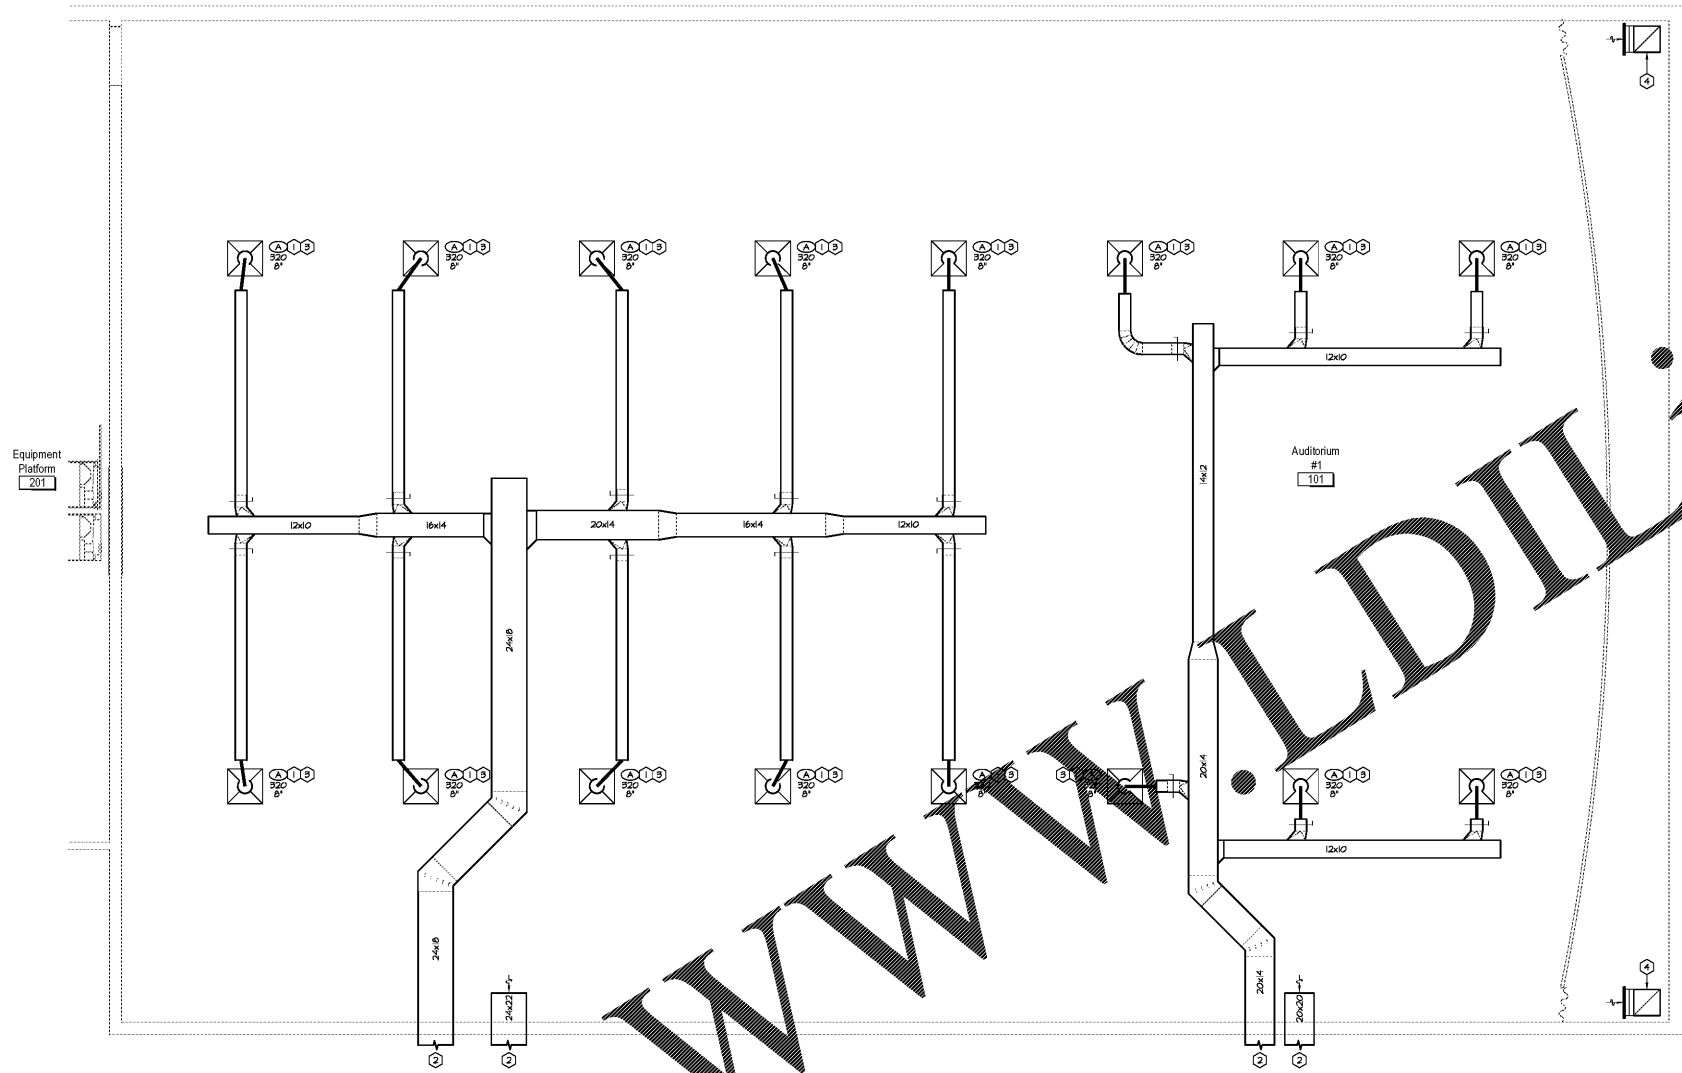

1 Auditorium New Work
 Mechanical Ceiling Plan
 Scale: 1/4" = 1'-0"



DATE: 06/25/2018
 MECHANICAL ENGINEER
ROSS & BROWN
 205 West 79th Street
 Leawood, Kansas 66214
 (913) 622-0900 phone
 mjb@rb-engineers.com
 H&B Project Number: 172018
 CRW & Project Number: 2017671
 Copyright: 2018
 DRAWN BY: B.B.
 CHECKED BY: M.B.T.


SHEET LEGEND

0000 GENERAL INFORMATION & SCOPE OF WORK
 1000 EXISTING AND NEW & DETAIL

A100 FLOOR PLANS & CEILING PLANS
 A200 EXTERIOR & INTERIOR ELEVATIONS
 A300 BUILDING SECTIONS
 A400 FINISHED PLANS
 A500 EXTERIOR WINDOW DETAILS
 A600 DOOR SCHEDULE DOOR DETAILS
 A700 FINISH SCHEDULE FINISH FRAME
 A800 AUDITORIUM LIGHT LINE SECTION


EX STRUCTURAL
 ME MECHANICAL
 PE PLUMBING
 EE ELECTRICAL
 HW HEAVYWORKS DETAILS
 PE-C CARRIAGES & EQUIPMENT
 PLF-A AUDITORIUM

AMC MADISON YARDS 8
 AMC NEW BUILD
 605 MEMORIAL DR SE
 ATLANTA, GA 30316

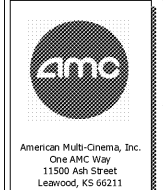

REV	DATE	DESCRIPTION

Project Issue Date: 06/25/2018

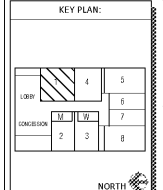

SHEET TITLE:
AUDITORIUM MECHANICAL PLAN

SHEET NUMBER:
PLFM2

Order Plans @

WWW.LDILine.com