

GENERAL NOTES:
 A. REFER TO SHEET PLFM FOR GENERAL NOTES.

PLAN NOTES:

1. PROVIDE CLEAR FLEXIBLE CALLOUS COMPOND BY DWP BETWEEN ALL DIFFUSERS AND GRILLES AND CEILING GRID TO PREVENT LOW FREQUENCY VIBRATION. CALK SHALL BE CONTINUOUS ALONG THE FOUR (4) EDGES OF THE DIFFUSER OR GRILLE. ALL EXCESS CALK SHALL BE REMOVED.
2. REFER TO DOMESTIC DEVELOPMENT SHEET M203 FOR CONTINUATION.
3. REFER TO DOMESTIC DEVELOPMENT SHEET M201 FOR GRILLE REGISTER 4 DIFFUSER SCHEDULE.
4. RETURN DUCT - PROVIDE 18x18 RETURN DUCT DOWN TO FLOOR BELOW. BOTTOM OF RETURN DUCT SHALL BE AT 6" AFF. PROVIDE 18x18 PERFORATED GRILLE ON FACE OF DUCT BELOW SCREEN. REFER TO DOMESTIC DEVELOPMENT SHEETS FOR RETURN GRILLE HOODS, IN OTHER AUDITORIUMS.



DATE: 06/25/2018
 MECHANICAL
ROSS & BROWN
 205 West 79th Street
 Lawrence, Kansas 66214
 (785) 843-2000 phone
 mross@rb.com
 H&S Project Number: 172018
 CW & Project Number: 2017671
 Copyright: 2018
 DRAWN BY: B.S.
 CHECKED BY: M8T


SHEET LEGEND

0000 GENERAL INFORMATION & SCOPE OF WORK
 1000 EXISTING AND NEW & DETAIL

A100 FLOOR PLANS & CEILING PLANS
 A200 EXTERIOR & INTERIOR ELEVATIONS
 A300 BUILDING SECTIONS
 A400 FINISHED PLANS
 A500 EXTERIOR WINDOW DETAILS
 A600 DOOR SCHEDULE DOOR DETAILS
 A700 FINISHED FRAME DETAILS
 A800 AUDITORIUM LIGHT LINE SECTION

EX STRUCTURAL
 ME MECHANICAL
 PE PLUMBING
 EE ELECTRICAL
 HW HEAVYWORKS DETAILS
 PE-C CARRIAGES & EQUIPMENT
 PLF-A AUDITORIUM

AMC MADISON YARDS 8
 AMC NEW BUILD
 605 MEMORIAL DR SE
 ATLANTA, GA 30316

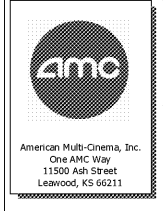

REV	DATE	DESCRIPTION


Project Issue Date: 06/25/2018

KEY PLAN:

NORTH

SHEET TITLE:
AUDITORIUM MECHANICAL PLAN

SHEET NUMBER:
PLFM2

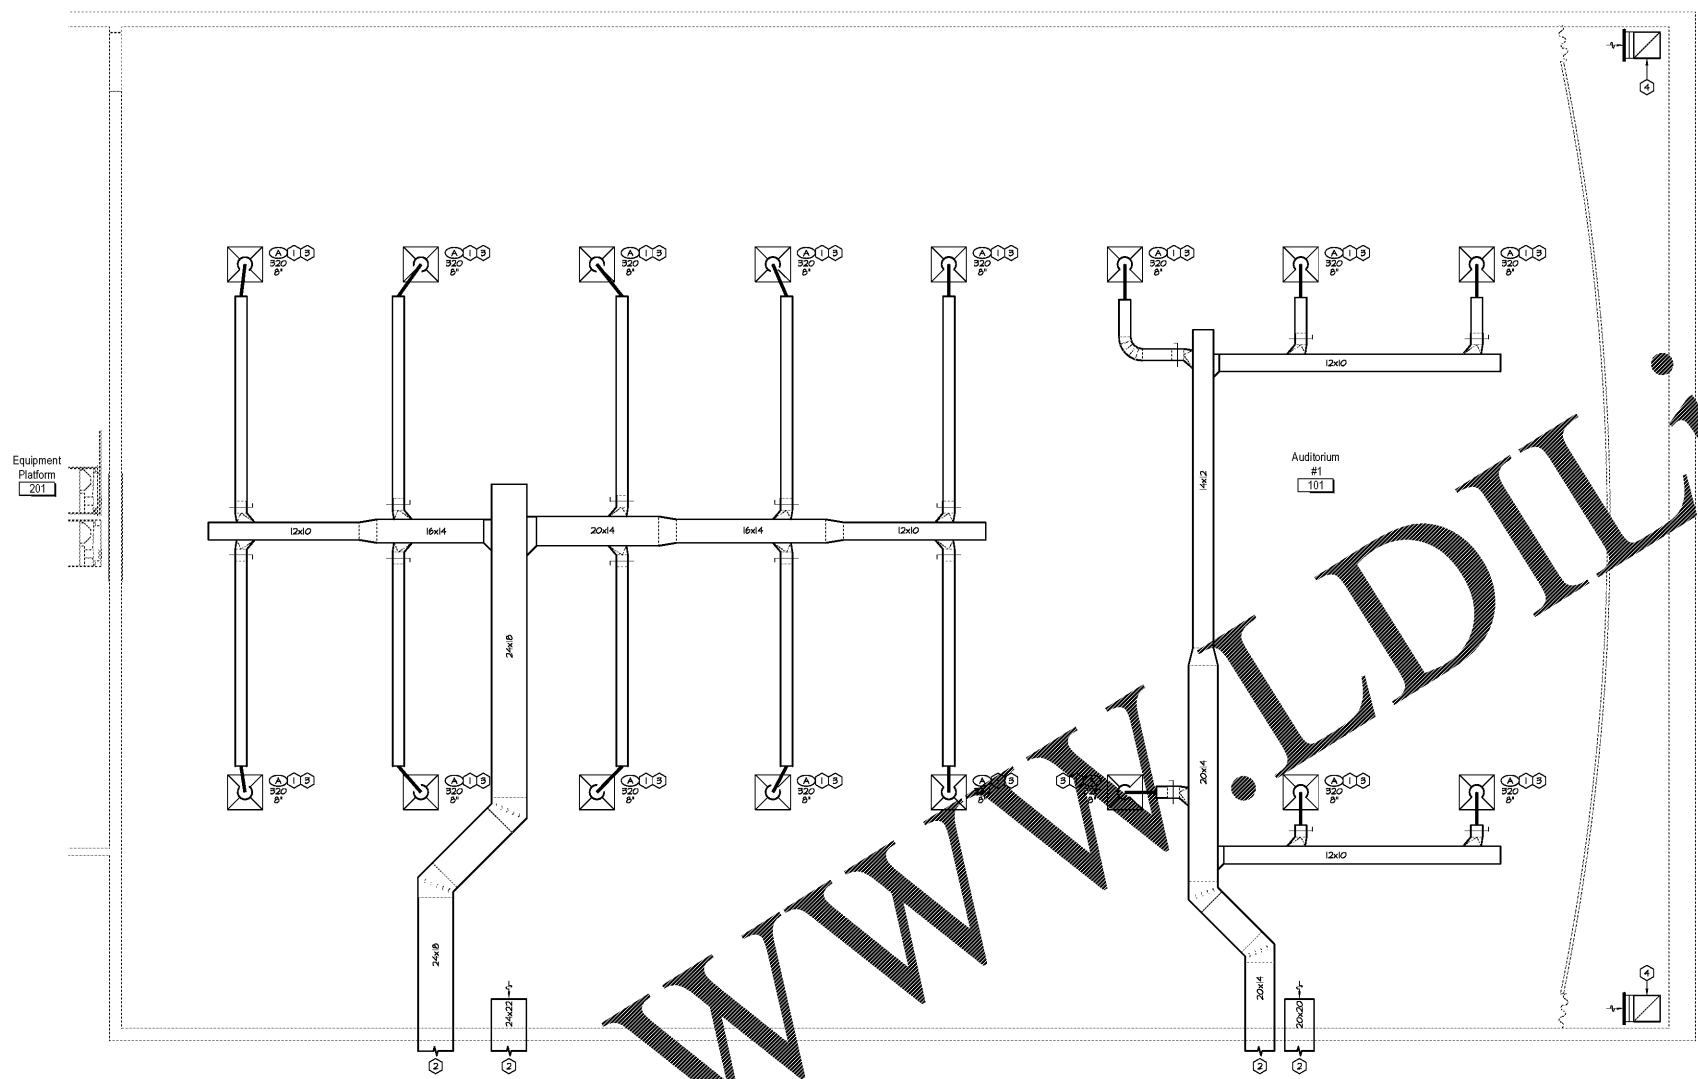

1 Auditorium New Work Mechanical Ceiling Plan
 Scale: 1/4" = 1'-0"

Order Plans @

WWWLDIline.com