

COPYRIGHT NOTICE
This drawing is the property of the above named professional and is not to be used for any purpose other than the specific project and site named herein, without the written permission from the professional.

ISSUE RECORD

DATE	REV.	DESCRIPTION	PERMIT SUBMISSION SET
03/28/2017			



PROFESSIONAL SEAL



PROFESSIONAL IN CHARGE
SUSAN NELSON KOUGIAS

PROJECT MANAGER
JOHN HANSEN

QUALITY CONTROL
CHRIS CERBO

DRAWN BY
SAMUEL VANDORA

PROJECT NAME
MURPHY USA

MURPHY OIL CONVENIENCE STORE
508 SC - 72

GREENWOOD, SC 29646

FREY MOSS STRUCTURE

1801 Rockdale Industrial Blvd.
Coryers, Georgia 30012
Voice: (800) 366-6385
Fax: (770) 483-6037
PFS JOB NUMBER: G18M00025
PFS MODEL NUMBER: XXXXXX

PROJECT NUMBER
20170844.0


SHEET TITLE

EXTERIOR ELEVATIONS

SHEET NUMBER

E2

PROTO VS.0 01/03/2017

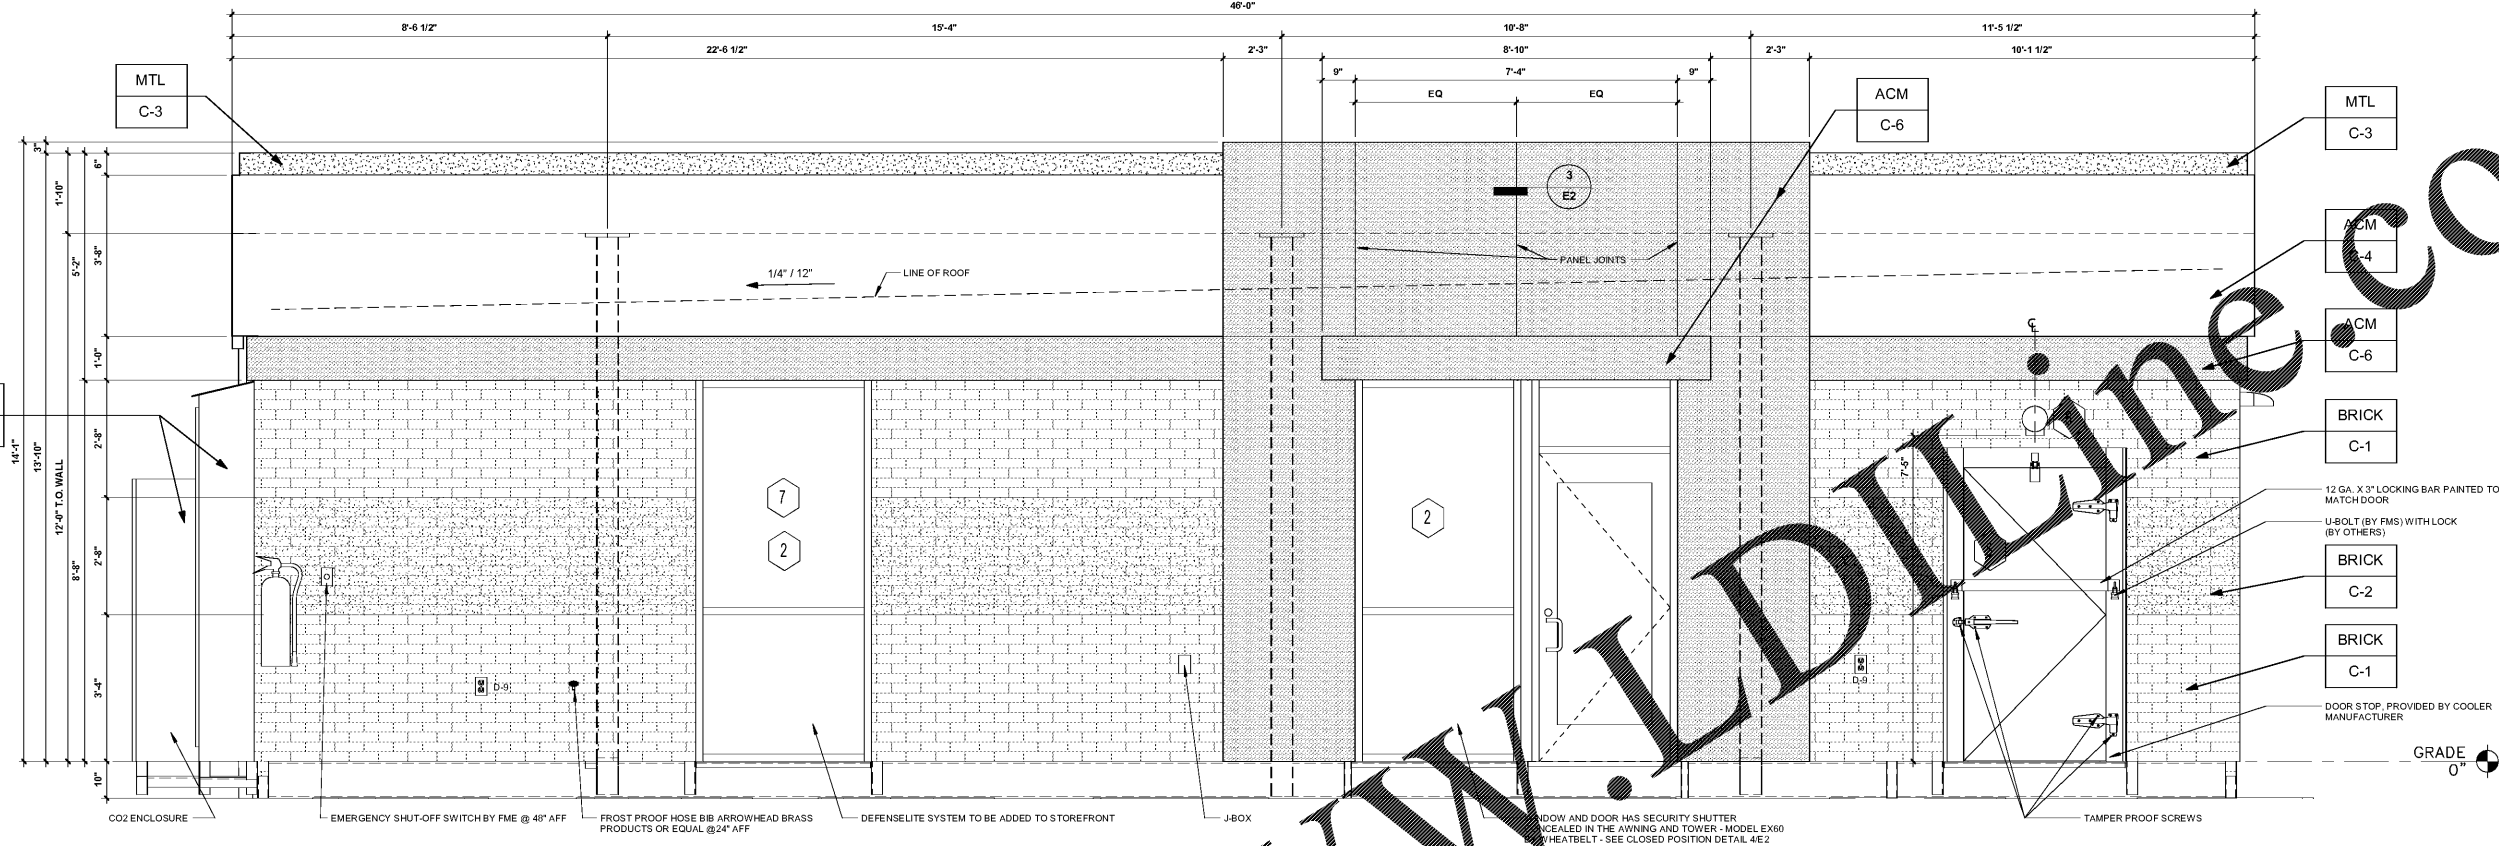

1 LEFT ELEVATION (EAST)
1/2" = 1'-0"

KEYED NOTES:


- 1 SIGNAGE (IF REQUIRED) BY SIGN CONTRACTOR
- 2 CLEAR ANODIZED ALUMINUM STOREFRONT SYSTEM KAWNEER, YKK OR EQUAL C-7
- 3 EXTERIOR LIGHTING, REFER TO LIGHTING PLAN SHEET EL2
- 4 4" x 4" PAINTED METAL DOWNSPOUTS C-3
- 5 DOORS (EXTERIOR SIDE) AND DOOR FRAMES PAINTED C-3
- 6 LITHONIA REMOTE EMERGENCY HEAD HELA SHEET EL2
- 7 DEFENSELITE SYSTEM TO BE INSTALLED BY CORNELL AT FMS SHEET E3

EXTERIOR FINISHES:


ACM	ACM (3MM THICKNESS)	BY FMS
BRICK	THIN BRICK	BY FMS
MTL	20 GA. SHEET METAL (UNLESS NOTED OTHERWISE)	BY FMS

EXTERIOR PAINT/COLORS:


C-1	THIN BRICK VENEER - LIGHT SANDSTONE VELOUR BY ENDICOTT (WIRE CUT FINISH)	BY FMS
C-2	THIN BRICK VENEER - EMPIRE IVORY VELOUR BY CERCOLINA CERAMICS (WIRE CUT FINISH)	BY FMS
C-3	DORMER BROWN SW #7521	BY FMS
C-4	REYNOLDBOND #4 NATURAL BRUSHED ALUMINUM	BY FMS
C-5	OPEN	BY FMS
C-6	PROGRAM RED	BY FMS
C-7	CLEAR ANODIZED ALUMINUM STOREFRONT	BY FMS

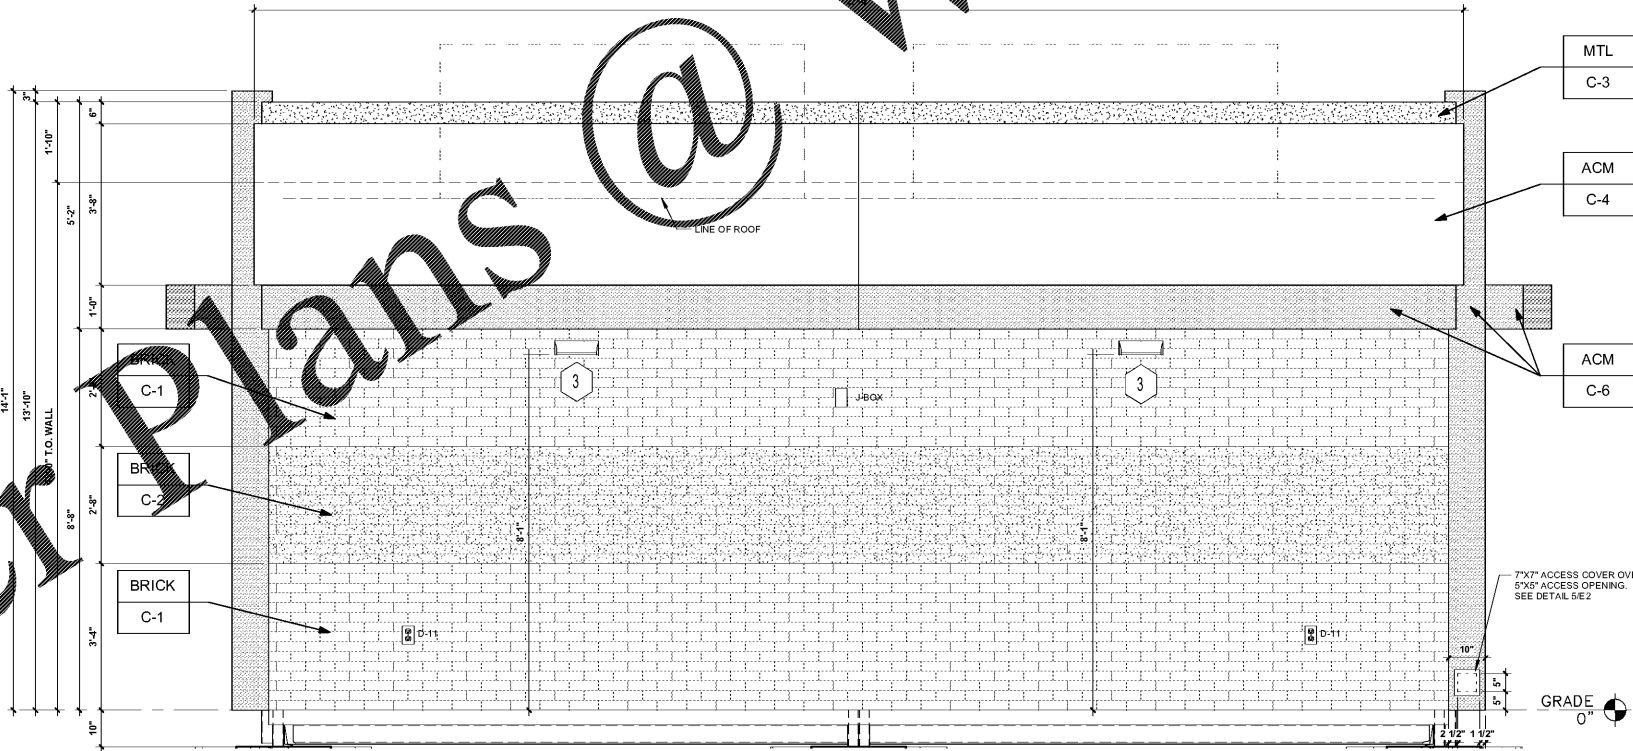


2 FRONT ELEVATION (NORTH)
1/2" = 1'-0"

 

3 ACM JOINT DETAIL
N.T.S.

 

5 ACCESS PANEL
N.T.S.

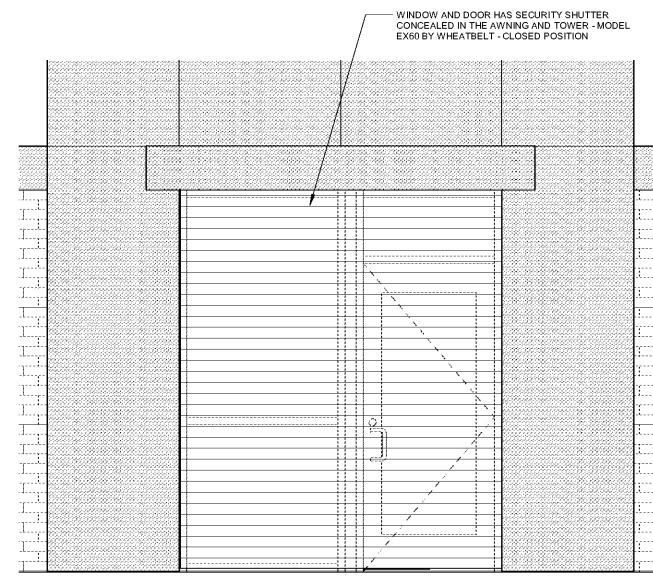

4 SECURITY SHUTTER @ ENTRY DOOR
1/2" = 1'-0"

WWW.LDLINE.COM

Order Plans @