 


COPYRIGHT NOTICE
This drawing is the property of the above referenced professional and is not to be used for any purpose other than the specific project and site named herein, without the express written permission from the professional.

ISSUE RECORD		
DATE	REV.	DESCRIPTION
03/20/18		PERMIT SUBMISSION SET



PROFESSIONAL SEAL



Signature
No. 31307
03/29/2018

PROFESSIONAL IN CHARGE

ONDRE MAYUGA

PROJECT MANAGER

ONDRE MAYUGA

QUALITY CONTROL

ONDRE MAYUGA

DRAWN BY

GERRARD DUPLAN

PROJECT NAME

MURPHY USA

MURPHY OIL CONVENIENCE STORE
508 SC - 72

GREENWOOD, SC 29646

FREY MOSS STRUCTURE

1801 Rockdale Industrial Blvd.
Conyers, Georgia 30012
Voice: (800) 366-6385
Fax: (770) 483-6037
PMS JOB NUMBER
G18MU00025
PMS MODEL NUMBER
XXXXXX

PROJECT NUMBER
20170844.0


SHEET TITLE

LIGHTING PLAN

SHEET NUMBER

EL2

PROTO V3.0 01/03/2017

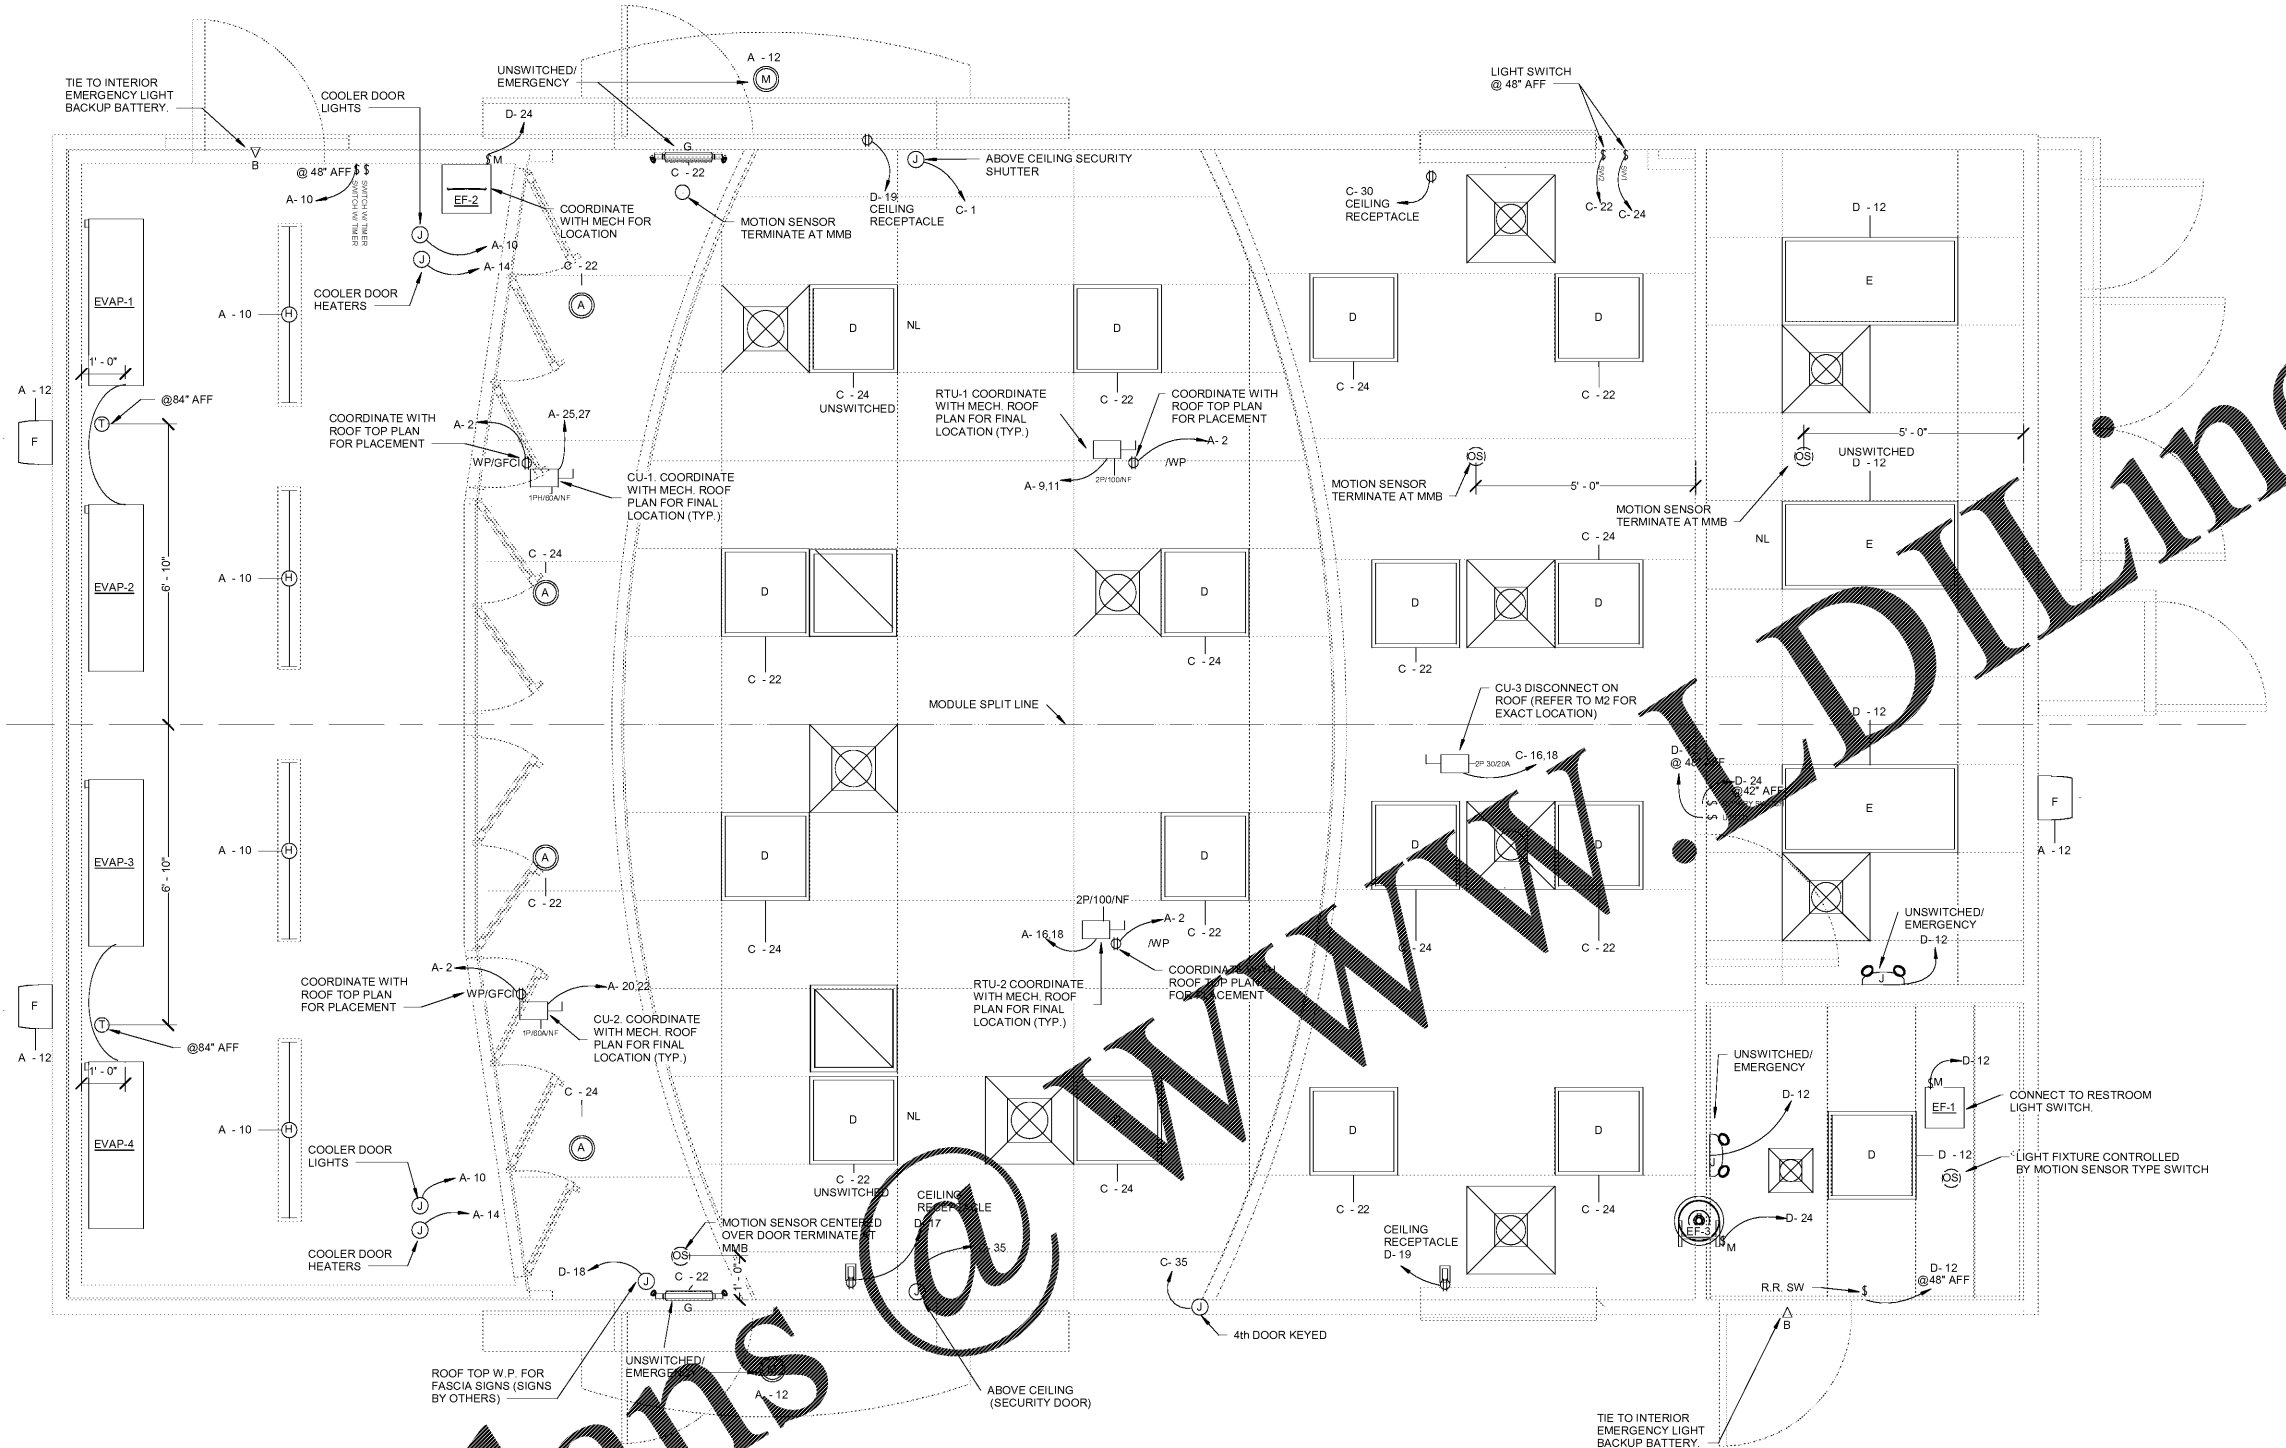


Lighting SCHEDULE					
Mark	Type	Description	Catalog Number	Wattage	Count
A	LR6-18L 6" LED DOWNLIGHT, GU24 BASE, 1,800 LUMENS, 120V, 3500K COLOR TEMPERATURE, DEEP RECESS - 20" SHIELD DIMMABLE TO 5%, DIFFUSE ANODIZED FINISH TRIM.	HOUSING CATALOG: # RC6-12W-GU24	LR6-18L-35K-120V-A-DR W/LT6A	20 W	4
B	REMOTE EXTERIOR EMERGENCY LIGHT	LED < 3 WATTS			2
D	CR22 2' X 2' LED TROFFER, 3,200 LUMENS, UNIVERSAL 120-277V, 4,000K COLOR TEMPERATURE, 0-10V DIMMING 5%		ZR22-32L-40K-10V	35 W	17
E	CR24 2' X 4' LED TROFFER - 4,000 LUMENS, UNIVERSAL 120-277V, 4,000K COLOR TEMPERATURE, 0-10V DIMMING 5%		ZR24-40L-40K-10V	44 W	3
F	XSP WALL MOUNT LUMINAIRE, TYPE III OPTIC DISTRIBUTION, 5,700K COLOR TEMPERATURE, UNIVERSAL 120-277V, BRONZE FINISH WITH MULTI LEVEL SENSOR	LED WALL PACK WITH MULTI LEVEL SENSOR	XSPWAO3MCUS-UZK	42 W	3
G	EMERGENCY EXIT COMBO UNIT WITH BATTERY BACKUP		E-XCL2GW	4 W	2
H	4" LED WET LOCATION LINEAR LUMINAIRE		WS4-47L-40K-10V-FD	50 W	4
J	STANDARD EMERGENCY LIGHT WITH TWO ADJUSTABLE HEADS		E-XYAD1106W	5 W	2
M	LR6-18L 6" LED DOWNLIGHT, GU24 BASE, 1,800 LUMENS, 120V, 3500K COLOR TEMPERATURE, DEEP RECESS - 20" SHIELD DIMMABLE TO 5%, DIFFUSE ANODIZED FINISH TRIM	HOUSING CATALOG: # RC6-12W-GU24	LR6-18L-35K-120V-A-DR W/LT6A	20 W	2

1 Electrical Lighting Plan
1/2" = 1'-0"

- ELECTRICAL LEGEND**
- 60A 3Ø NEMA 3R NON-FUSED GENERAL DISCOUNT
 - 30A 3Ø NEMA 3R NON-FUSED GENERAL DISCOUNT
 - JUNCTION BOX OR OUTLET BOX CONCEALED ABOVE CEILING
 - SIMPLE 15A-125V LOCKING ISOLATED GROUND RECEPTACLE IGS4716
 - DUPLEX 250V 25V RECEPTACLE
 - DOUBLE END
 - QUAD DUPLEX
 - DUPLEX 15A 125V ISOLATED GND. RECEPTACLE IGS5262
 - WALL MOUNTED TELEPHONE OUTLET
 - NUMBER REFERS TO EQUIPMENT OR WIRING NOTES ON THE DRAWING ON WHICH THE SYMBOL APPEARS
 - W/P WEATHERPROOF
 - A.F.F. ABOVE FINISHED FLOOR (C OF BOX)
 - G.F.C.I. GROUND FAULT CIRCUIT INTERRUPTER TYPE OUTLET
 - NL NIGHT LIGHT
 - OS OCCUPANCY SENSOR

GENERAL ELECTRICAL NOTES

- ALL FULL DIMENSIONS ARE TAKEN FROM OUTSIDE OF THE STEEL BASE FRAME OF THE BUILDING
- ALL CROSS-OVER WIRES ARE TO BE LABELED FOR SITE ELECTRICIAN
- ALL EMERGENCY AND EXIT SIGNS TO HAVE 90 MIN. BATTERY BACKUP AND TO BE CONNECTED AHEAD OF ANY CONTROL DEVICE
- LIGHTING FIXTURE, MARKED M, SHALL BE PROVIDED WITH BACK UP BATTERY (DUAL LITE LG-125VA/110W-T) TO PROVIDE EGRESS ILLUMINATION TO BE MOUNTED INSIDE STORE USING TBMK T-GRAD MOUNTING KIT. CAT 5 CABLES NOT REQUIRED FOR THERMOSTATS
- MOTION SENSOR CENTERED OVER DOOR TERMINATE AT MMB
- MOTION SENSOR FOR WALL PACK SET FOR OCCUPANCY SENSING AND LOW AMBIENT MODE (OSLA).

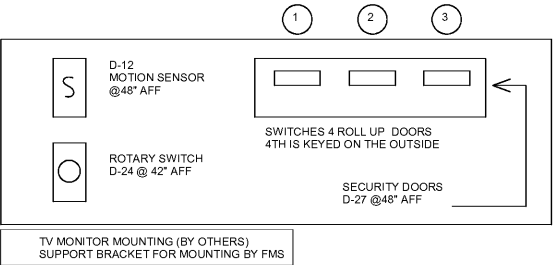

2 SUPPORT BRACKET FOR MOUNTING
EL2 NOT TO SCALE

Order Plans @ WWW.IDIline.com