


COPYRIGHT NOTICE
This drawing is the property of the above referenced professional and is not to be used for any purpose other than the specific project and site named herein, without the express written permission from the professional.

ISSUE RECORD

DATE	REV.	DESCRIPTION
03/29/2018		PERMIT SUBMISSION SET

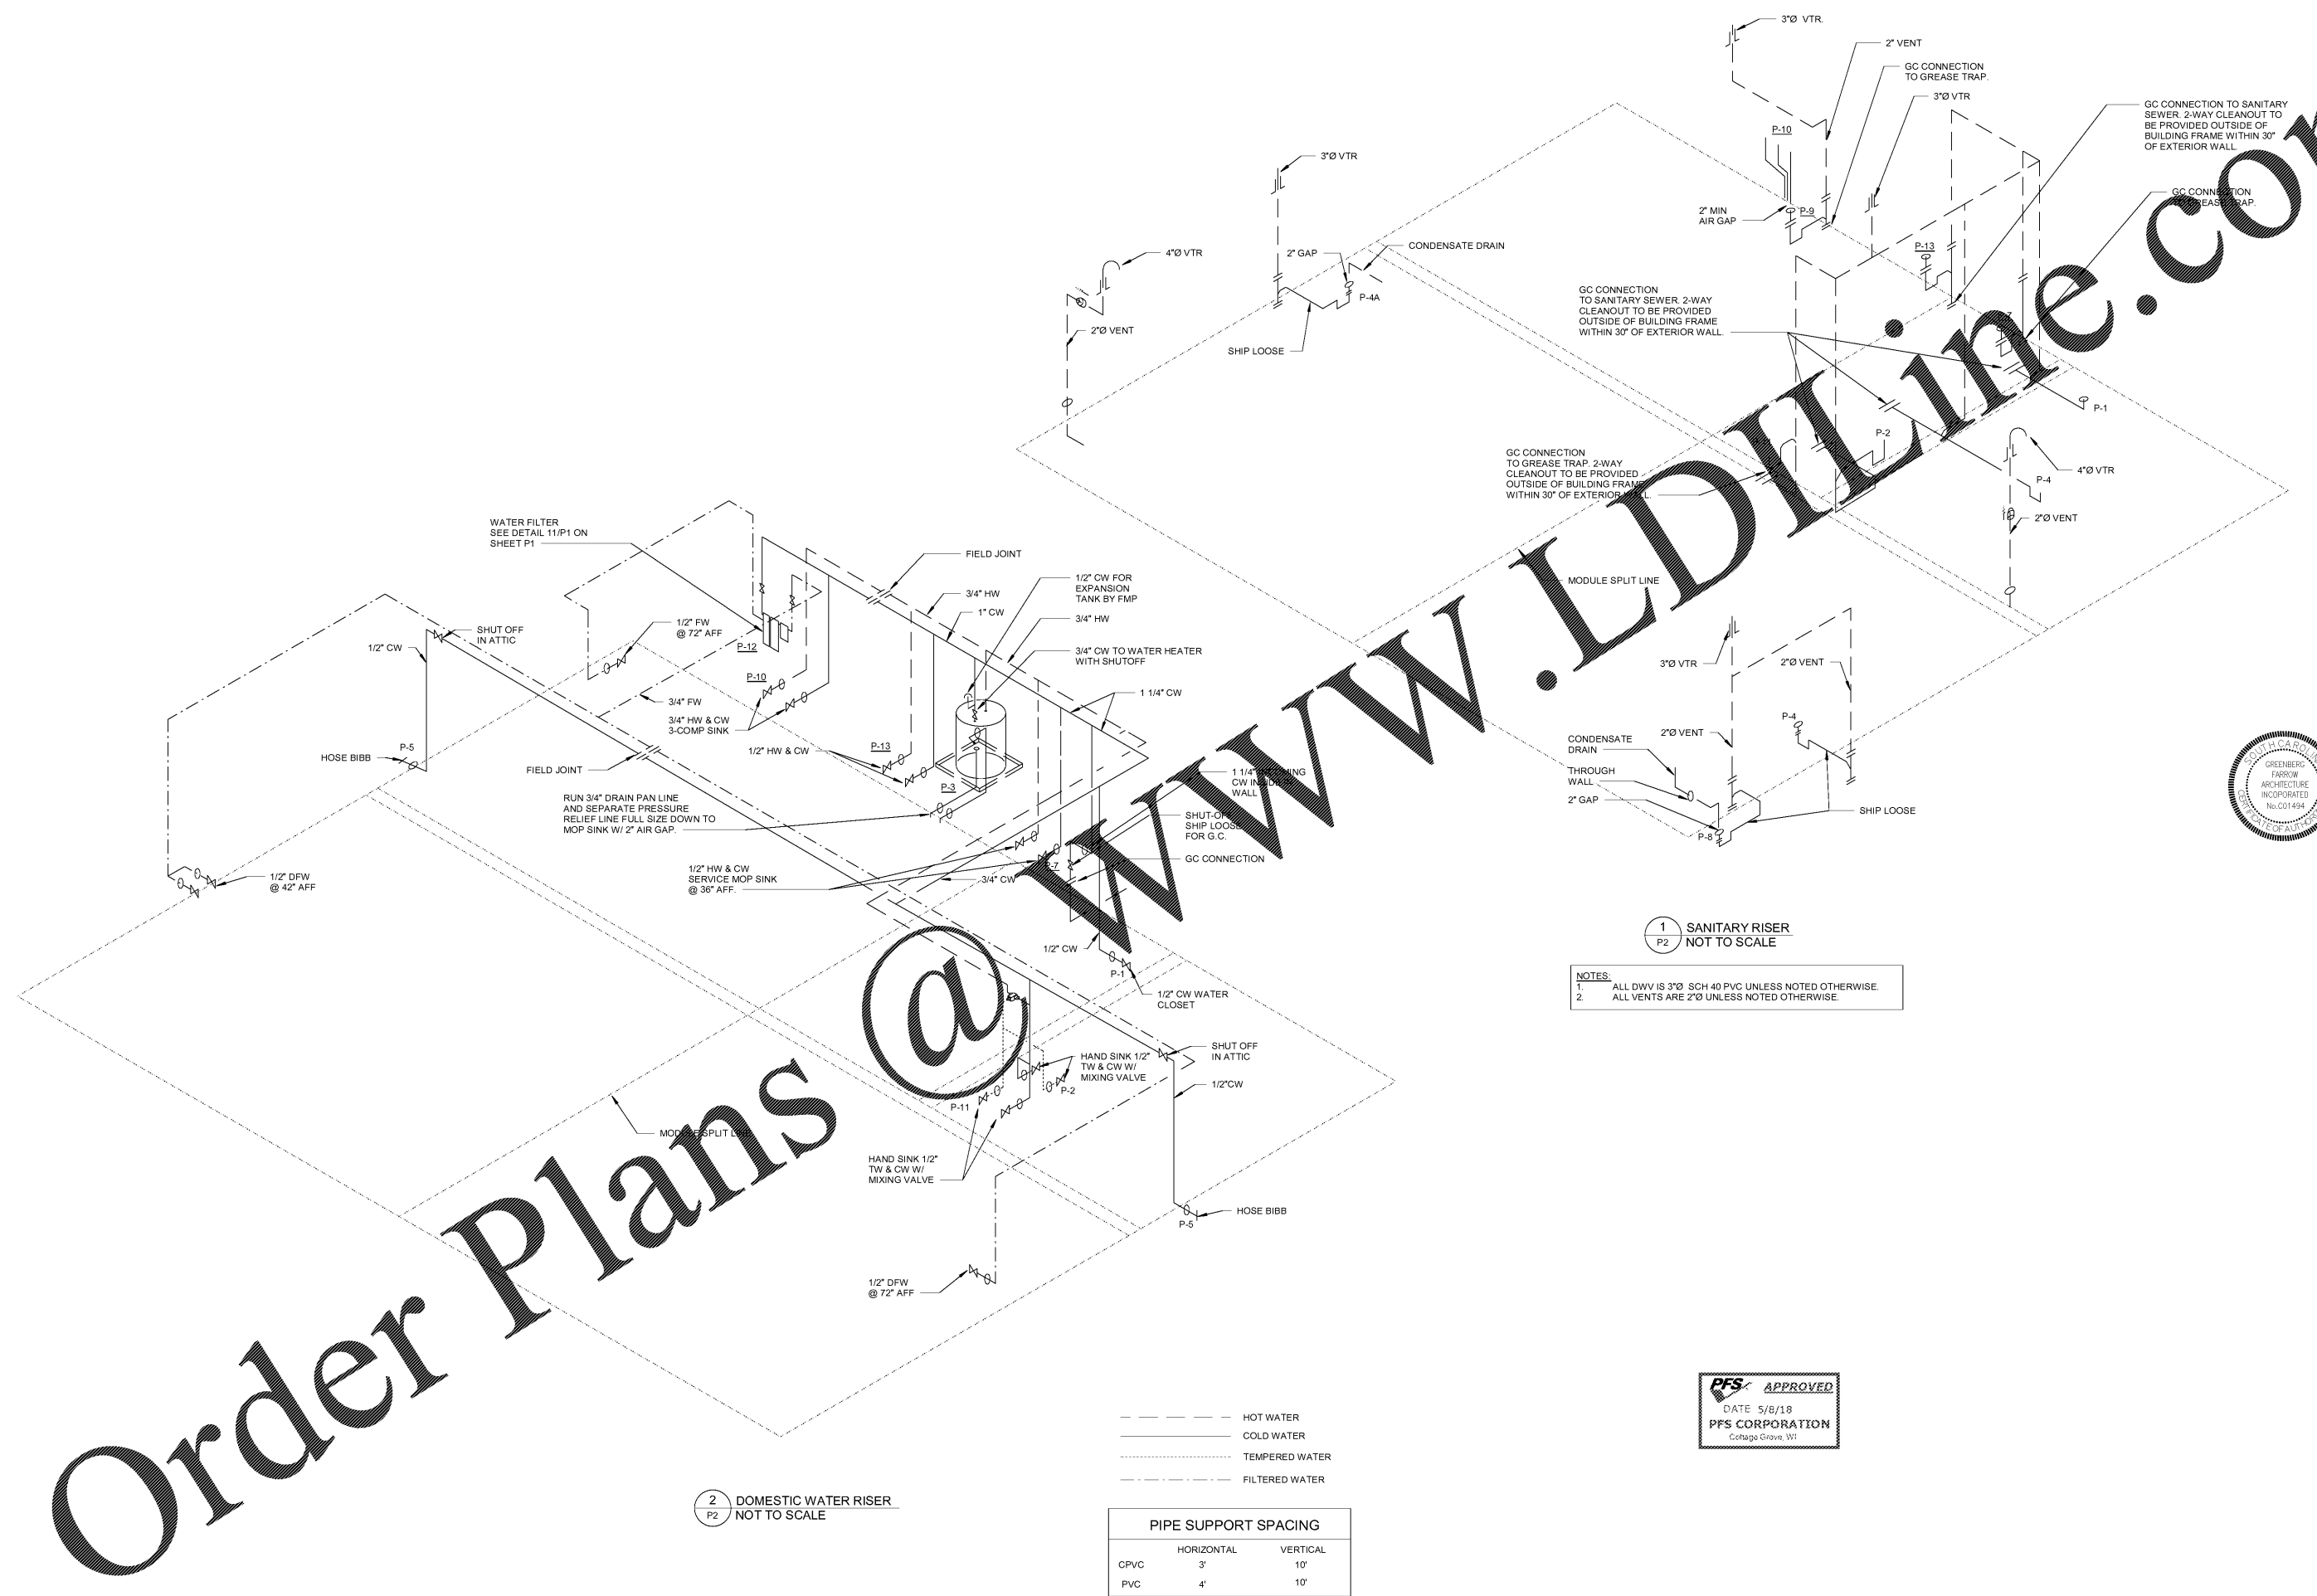

1 SANITARY RISER
P2 NOT TO SCALE

NOTES:
1. ALL DWV IS 3" SCH 40 PVC UNLESS NOTED OTHERWISE.
2. ALL VENTS ARE 2" UNLESS NOTED OTHERWISE.



--- HOT WATER
--- COLD WATER
--- TEMPERED WATER
--- FILTERED WATER

PIPE SUPPORT SPACING		
	HORIZONTAL	VERTICAL
CPVC	3'	10'
PVC	4'	10'

2 DOMESTIC WATER RISER
P2 NOT TO SCALE

Order Plans



PROFESSIONAL SEAL
ERIC WOLF
03/29/2018

PROFESSIONAL IN CHARGE
ERIC WOLF

PROJECT MANAGER
ERIC WONG

QUALITY CONTROL
ERIC WONG

DRAWN BY
AVERY LANE

PROJECT NAME
MURPHY USA
MURPHY OIL CONVENIENCE STORE
508 SC - 72

GREENWOOD, SC 29646



1801 Rockdale Industrial Blvd.
Conyers, Georgia 30012
Voice: (800) 366-6385
Fax: (770) 483-6037

PROJECT NUMBER
20170844.0

SHEET TITLE

PLUMBING RISER

SHEET NUMBER

P2