


COPYRIGHT NOTICE
This drawing is the property of the above referenced professional and is not to be used for any purpose other than the specific project and site named herein, without the express written permission from the professional.

ISSUE RECORD

DATE	REV.	DESCRIPTION
03/29/2018		PERMIT SUBMISSION SET

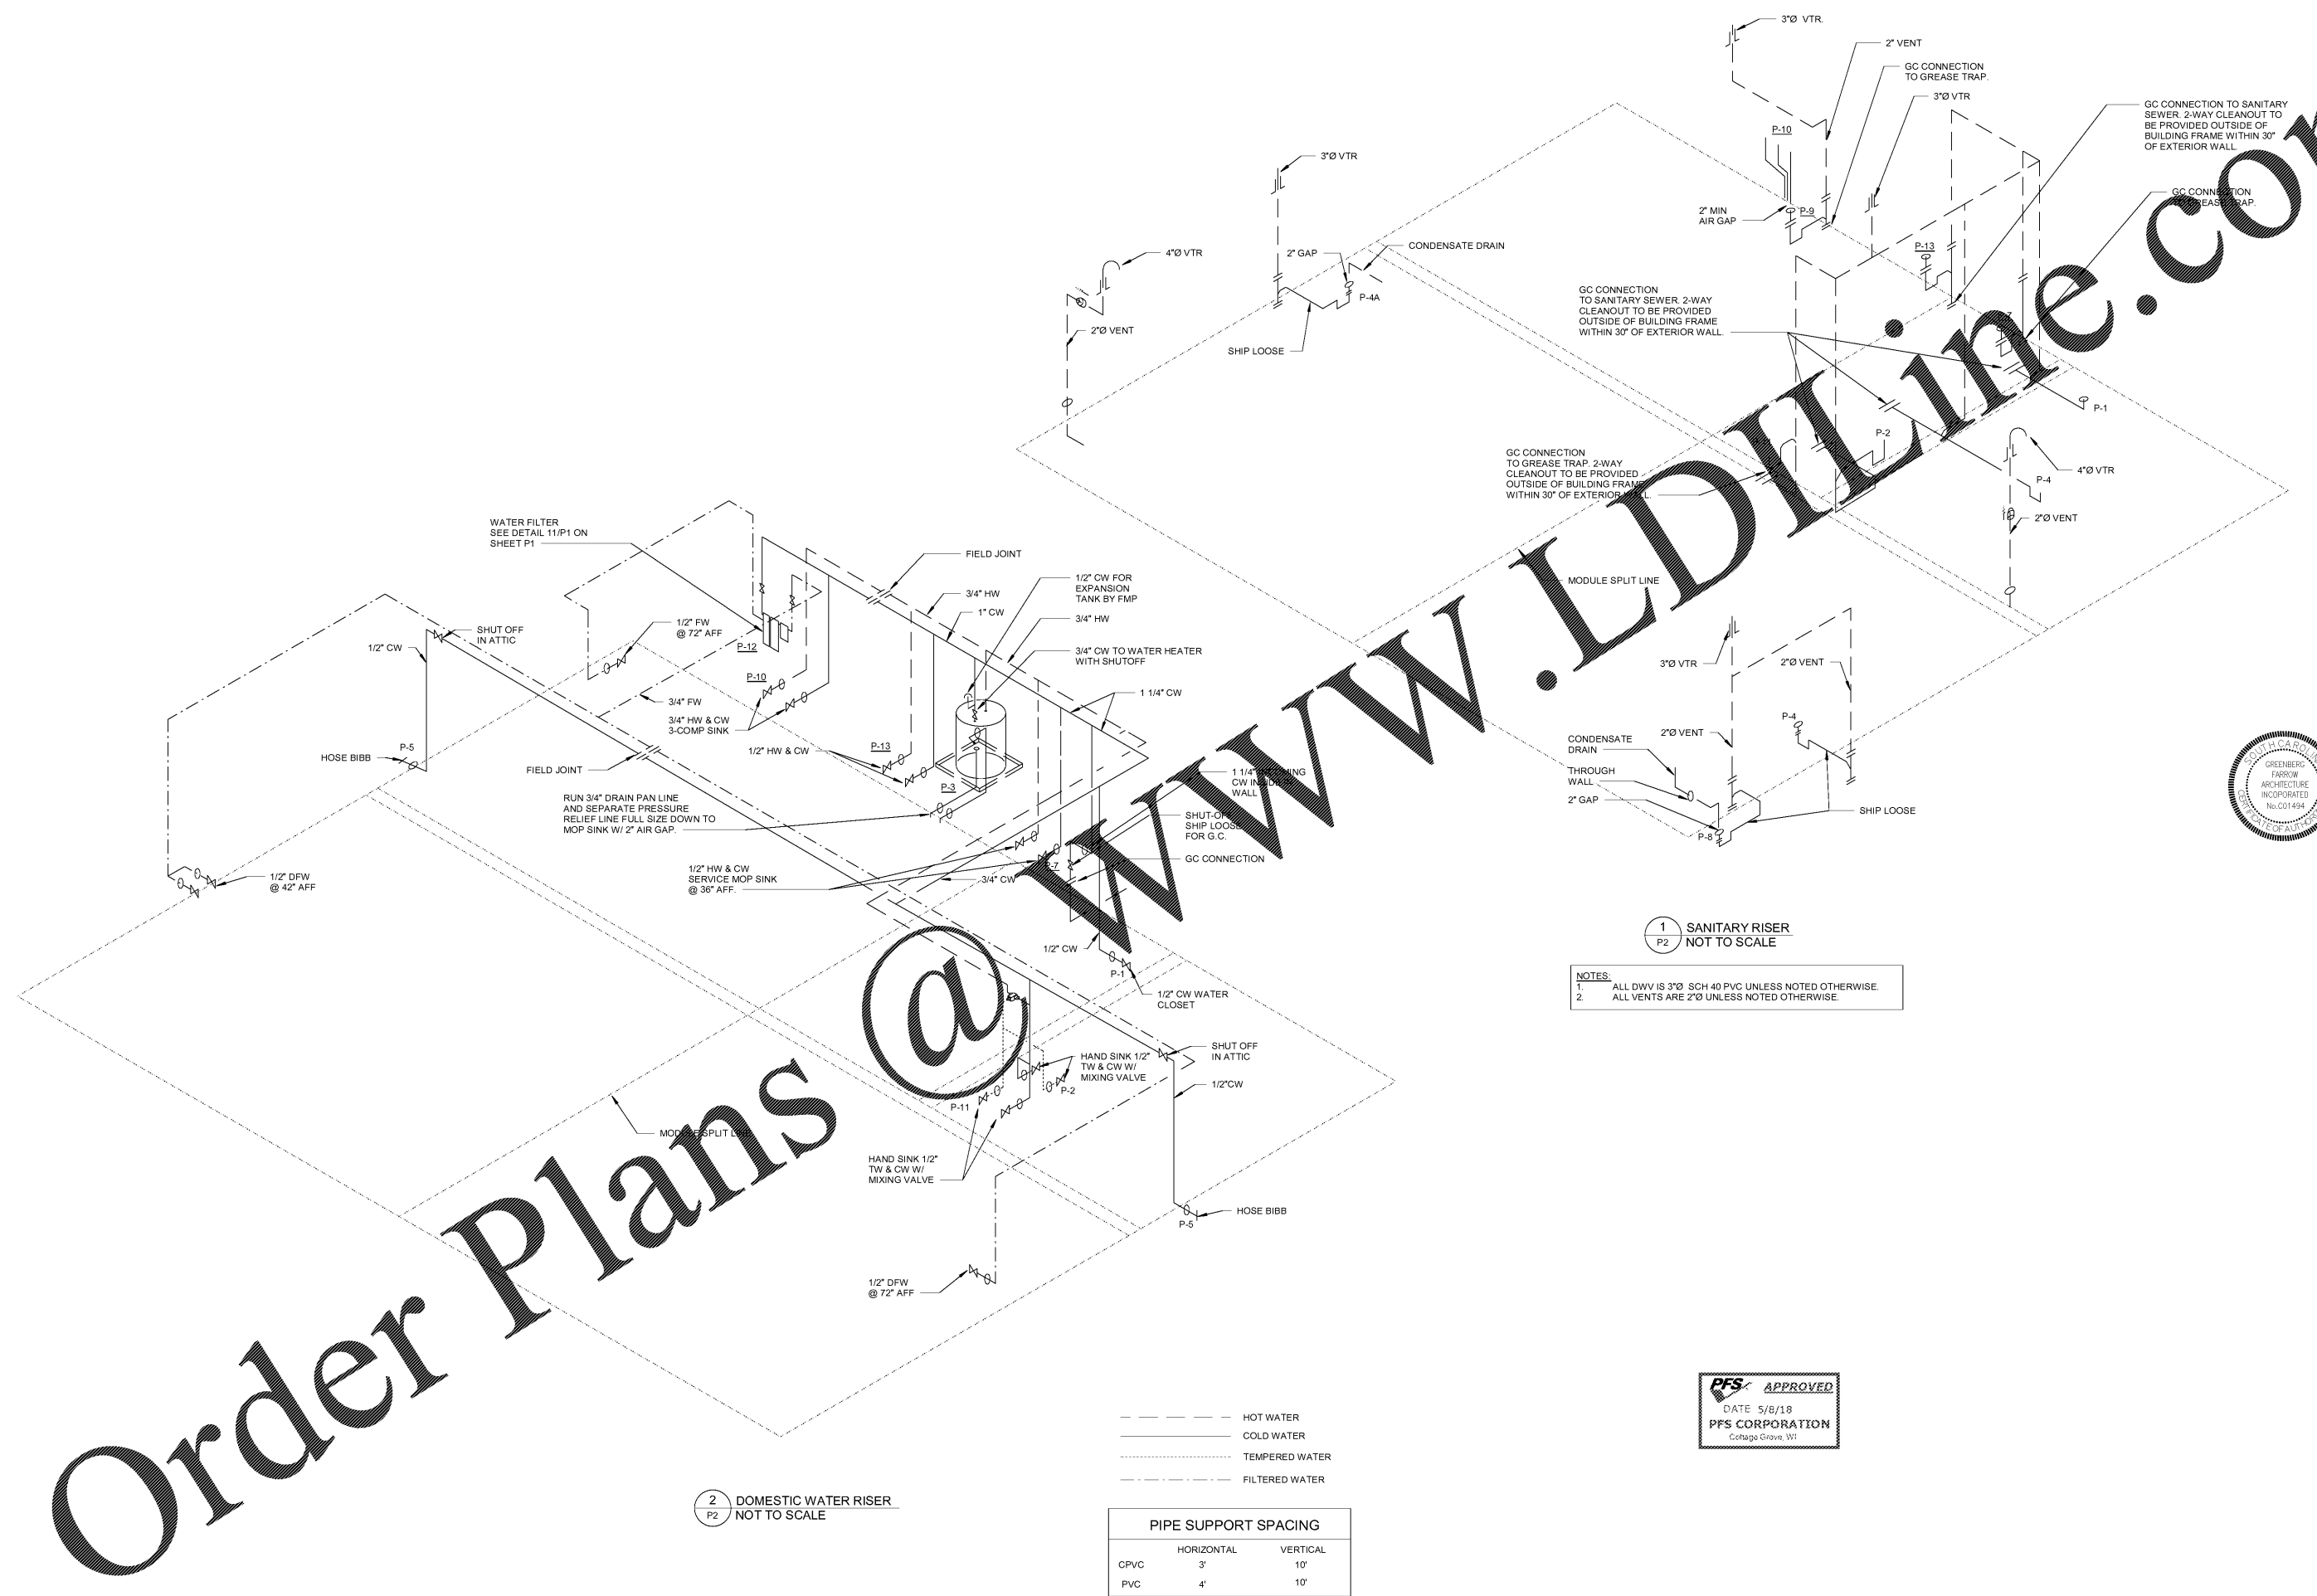

1 SANITARY RISER
P2 NOT TO SCALE

NOTES:
1. ALL DWV IS 3" SCH 40 PVC UNLESS NOTED OTHERWISE.
2. ALL VENTS ARE 2" UNLESS NOTED OTHERWISE.



--- HOT WATER
--- COLD WATER
--- TEMPERED WATER
--- FILTERED WATER

PIPE SUPPORT SPACING		
	HORIZONTAL	VERTICAL
CPVC	3'	10'
PVC	4'	10'

2 DOMESTIC WATER RISER
P2 NOT TO SCALE

Order Plans



PROFESSIONAL SEAL



03/29/2018

PROFESSIONAL IN CHARGE
ERIC WOLF

PROJECT MANAGER
ERIC WONG

QUALITY CONTROL
ERIC WONG

DRAWN BY
AVERY LANE

PROJECT NAME

MURPHY USA

MURPHY OIL CONVENIENCE STORE
508 SC - 72

GREENWOOD, SC 29646

FREY MOSS STRUCTURE

1801 Rockdale Industrial Blvd.
Conyers, Georgia 30012
Voice: (800) 366-6385
Fax: (770) 483-6037
FMS JOB NUMBER
G18MU0025
FMS MODEL NUMBER
XXXXXX

PROJECT NUMBER
20170844.0

SHEET TITLE

PLUMBING RISER

SHEET NUMBER

P2