



COPYRIGHT NOTICE
This drawing is the property of the above referenced professional and is not to be used for any purpose other than the specific project and site named herein, without the express written permission from the professional.

ISSUE RECORD		
DATE	REV.	DESCRIPTION
03/29/2018		PERMIT SUBMISSION SET


- GENERAL NOTES:**
1. INSTALLATION OF HVAC BY FMS SITE HOOK UP BY G.C.
 2. HVAC REGISTERS TO BE STEP DOWN TYPE.
 3. ALL MECHANICAL EQUIPMENT SHALL BE SCREENED FROM THE RIGHT-OF-WAY.

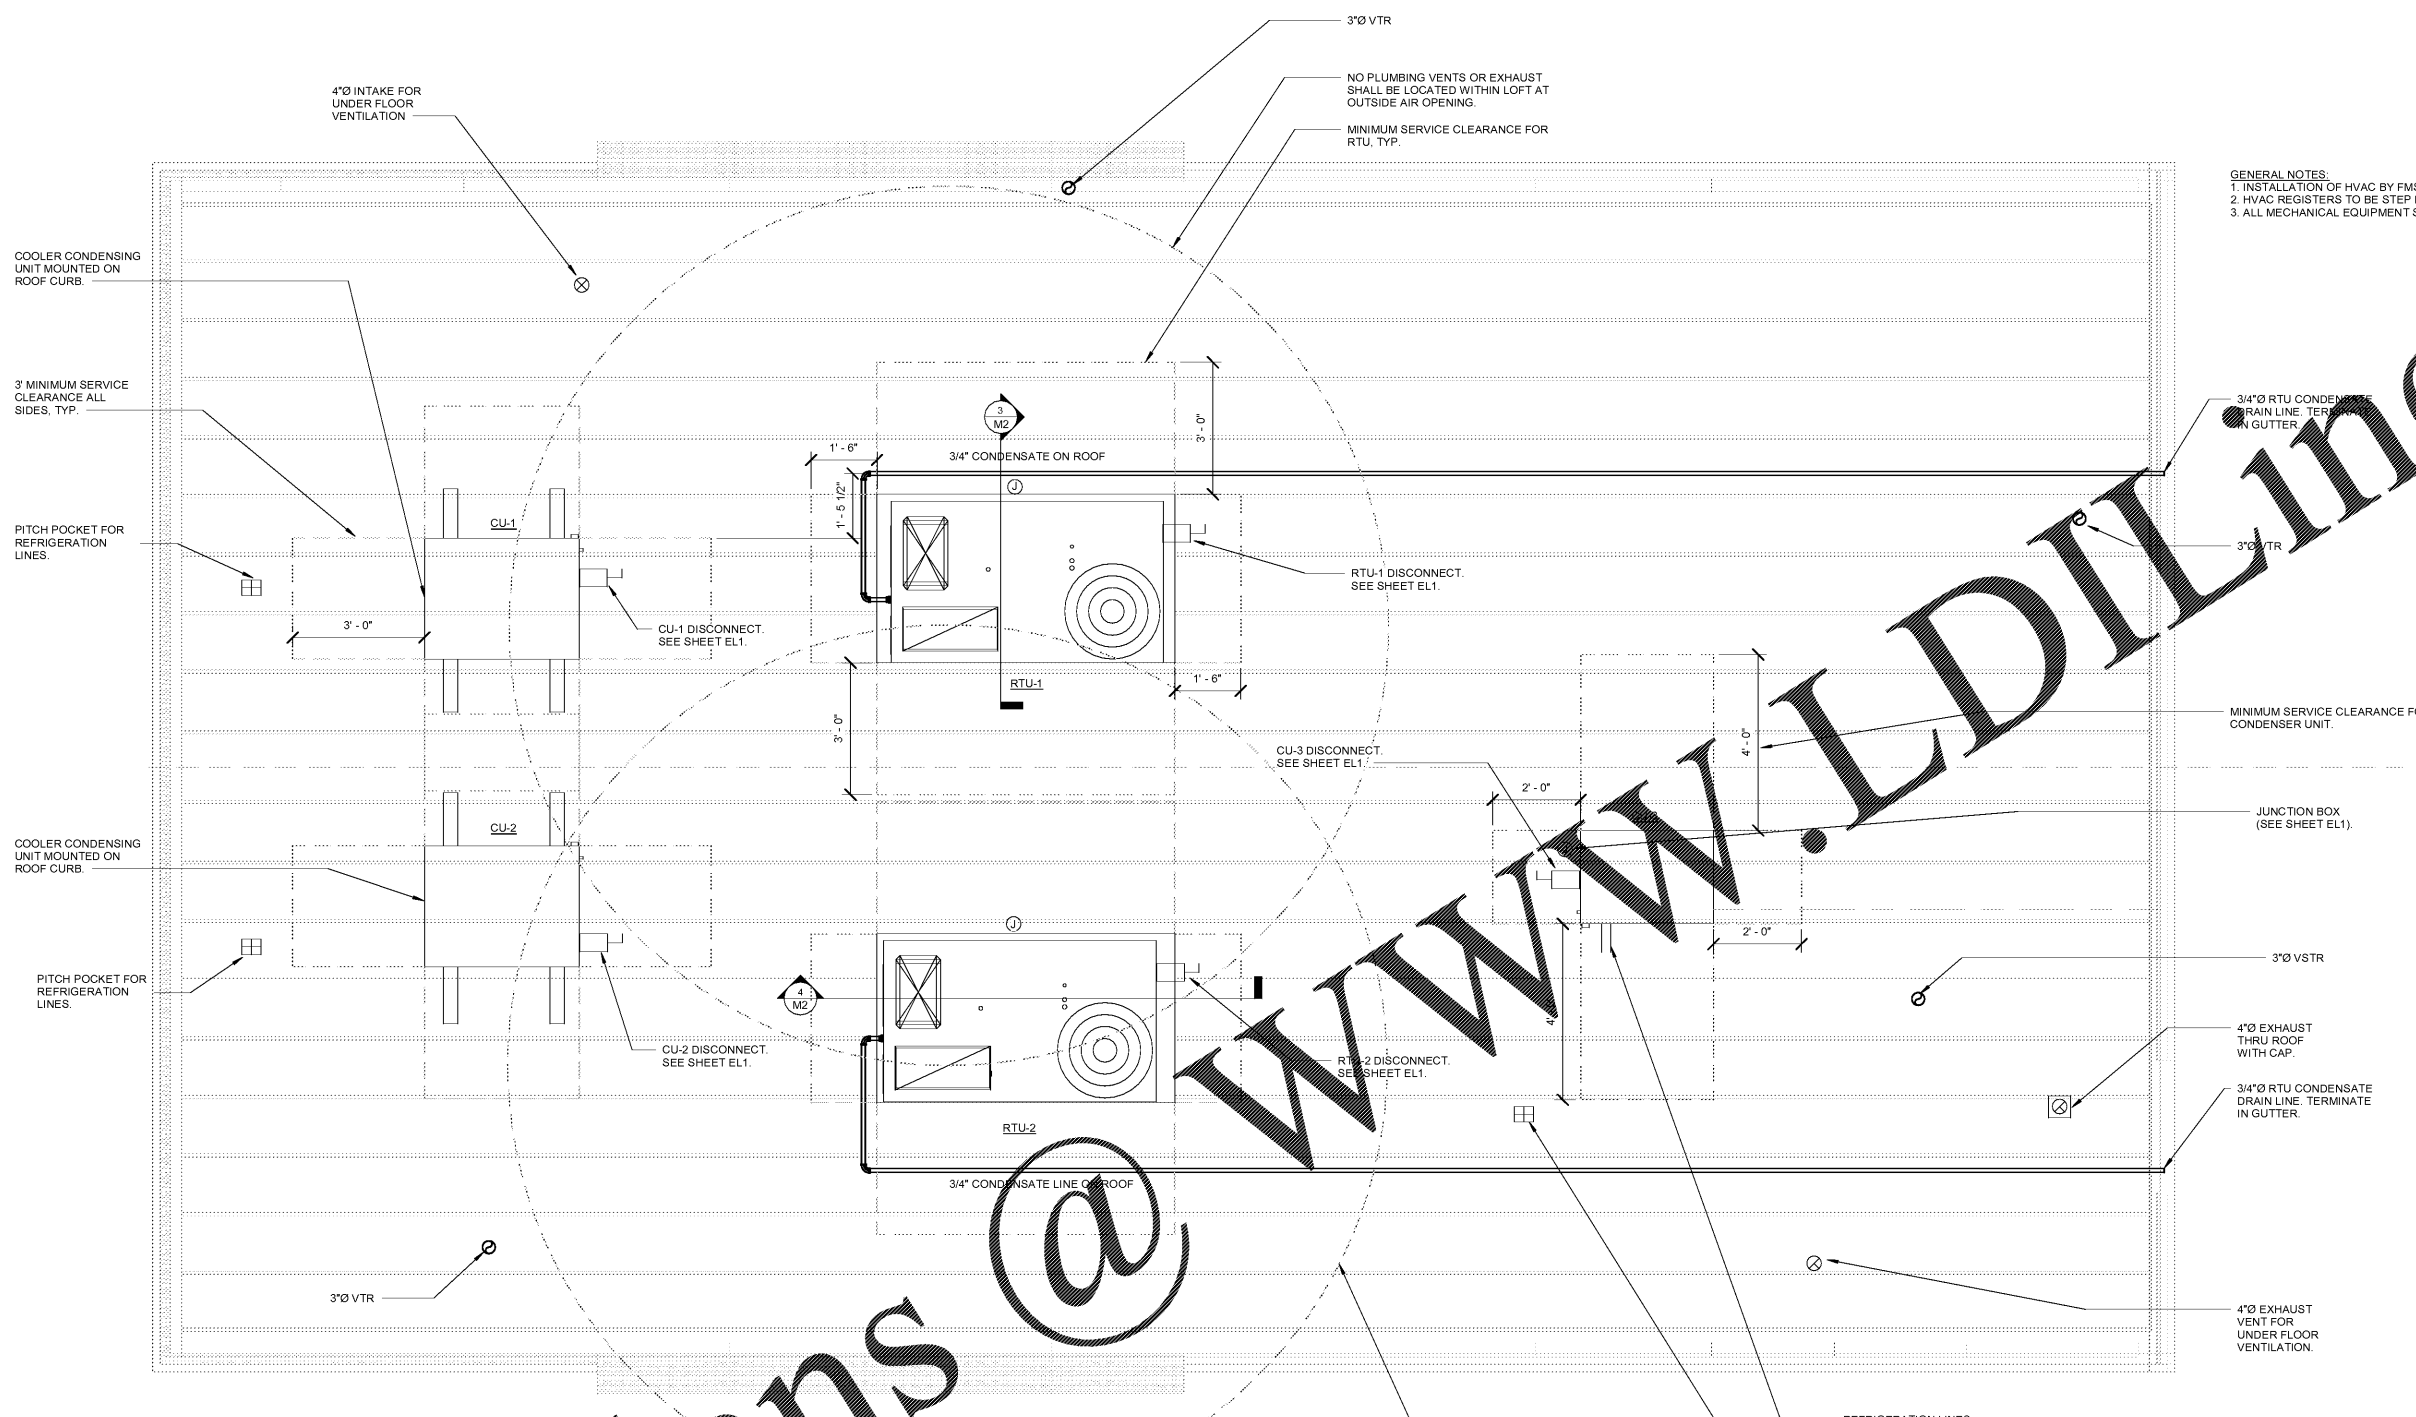


1 ROOF EQUIPMENT PLAN
M2
1/2" = 1'-0"

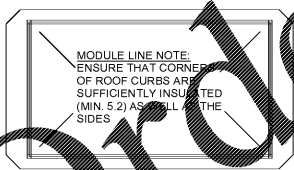


ROOF CURB INSULATION PLAN VIEW
M2

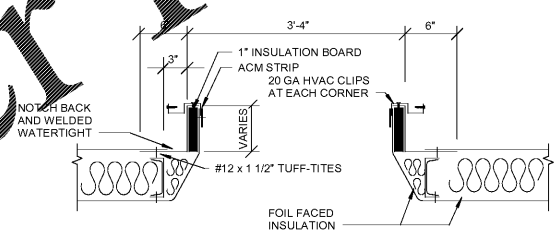


3 ROOF CURB DETAIL
M2
N.T.S.

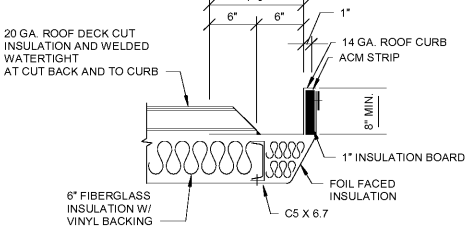

4 ROOF CURB DETAIL - PARTIAL
M2
N.T.S.

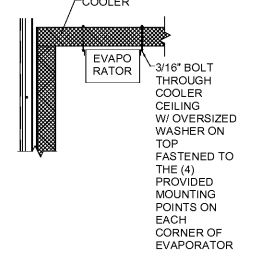

7 EVAPORATOR UNIT MOUNTING
M2
3/4" = 1'-0"

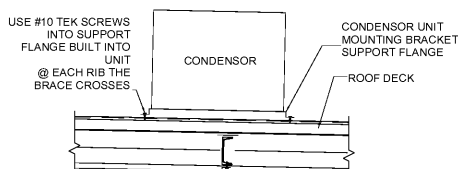

6 CONDENSER UNIT MOUNTING DETAIL
M2
3/4" = 1'-0"

NOTE: ALL MECHANICAL EQUIPMENT WILL BE SCREENED FROM THE RIGHT-OF-WAY.

NOTE: INSTALLATION OF HVAC BY FMS SITE HOOK UP BY G.C.



PROFESSIONAL SEAL



03/29/2018

PROFESSIONAL IN CHARGE

ERIC WOLF

PROJECT MANAGER

ERIC WONG

QUALITY CONTROL

ERIC WONG

DRAWN BY

AVERY LANE

PROJECT NAME

MURPHY USA

MURPHY OIL CONVENIENCE STORE
508 SC - 72

GREENWOOD, SC 29646

FREY MOSS STRUCTURE

1801 Rockdale Industrial Blvd.
Conyers, Georgia 30012
Voice: (800) 366-6385
Fax: (770) 483-6037
PFS JOB NUMBER: G18MU0025
FMS MODEL NUMBER: XXXXXX

PROJECT NUMBER
20170844.0

SHEET TITLE

MECHANICAL ROOF PLAN

SHEET NUMBER

M2

Order Plans @ www.LDIDline.com