


COPYRIGHT NOTICE
This drawing is the property of the above referenced professional and is not to be used for any purpose other than the specific project and site named herein. It cannot be reproduced in any manner without the express written permission from GreenbergFarrow.

ISSUE RECORD		
DATE	REV.	DESCRIPTION
02/07/2018		PERMIT SUBMISSION SET

**SOUTH CAROLINA
STATE BY-PASS NW 72**

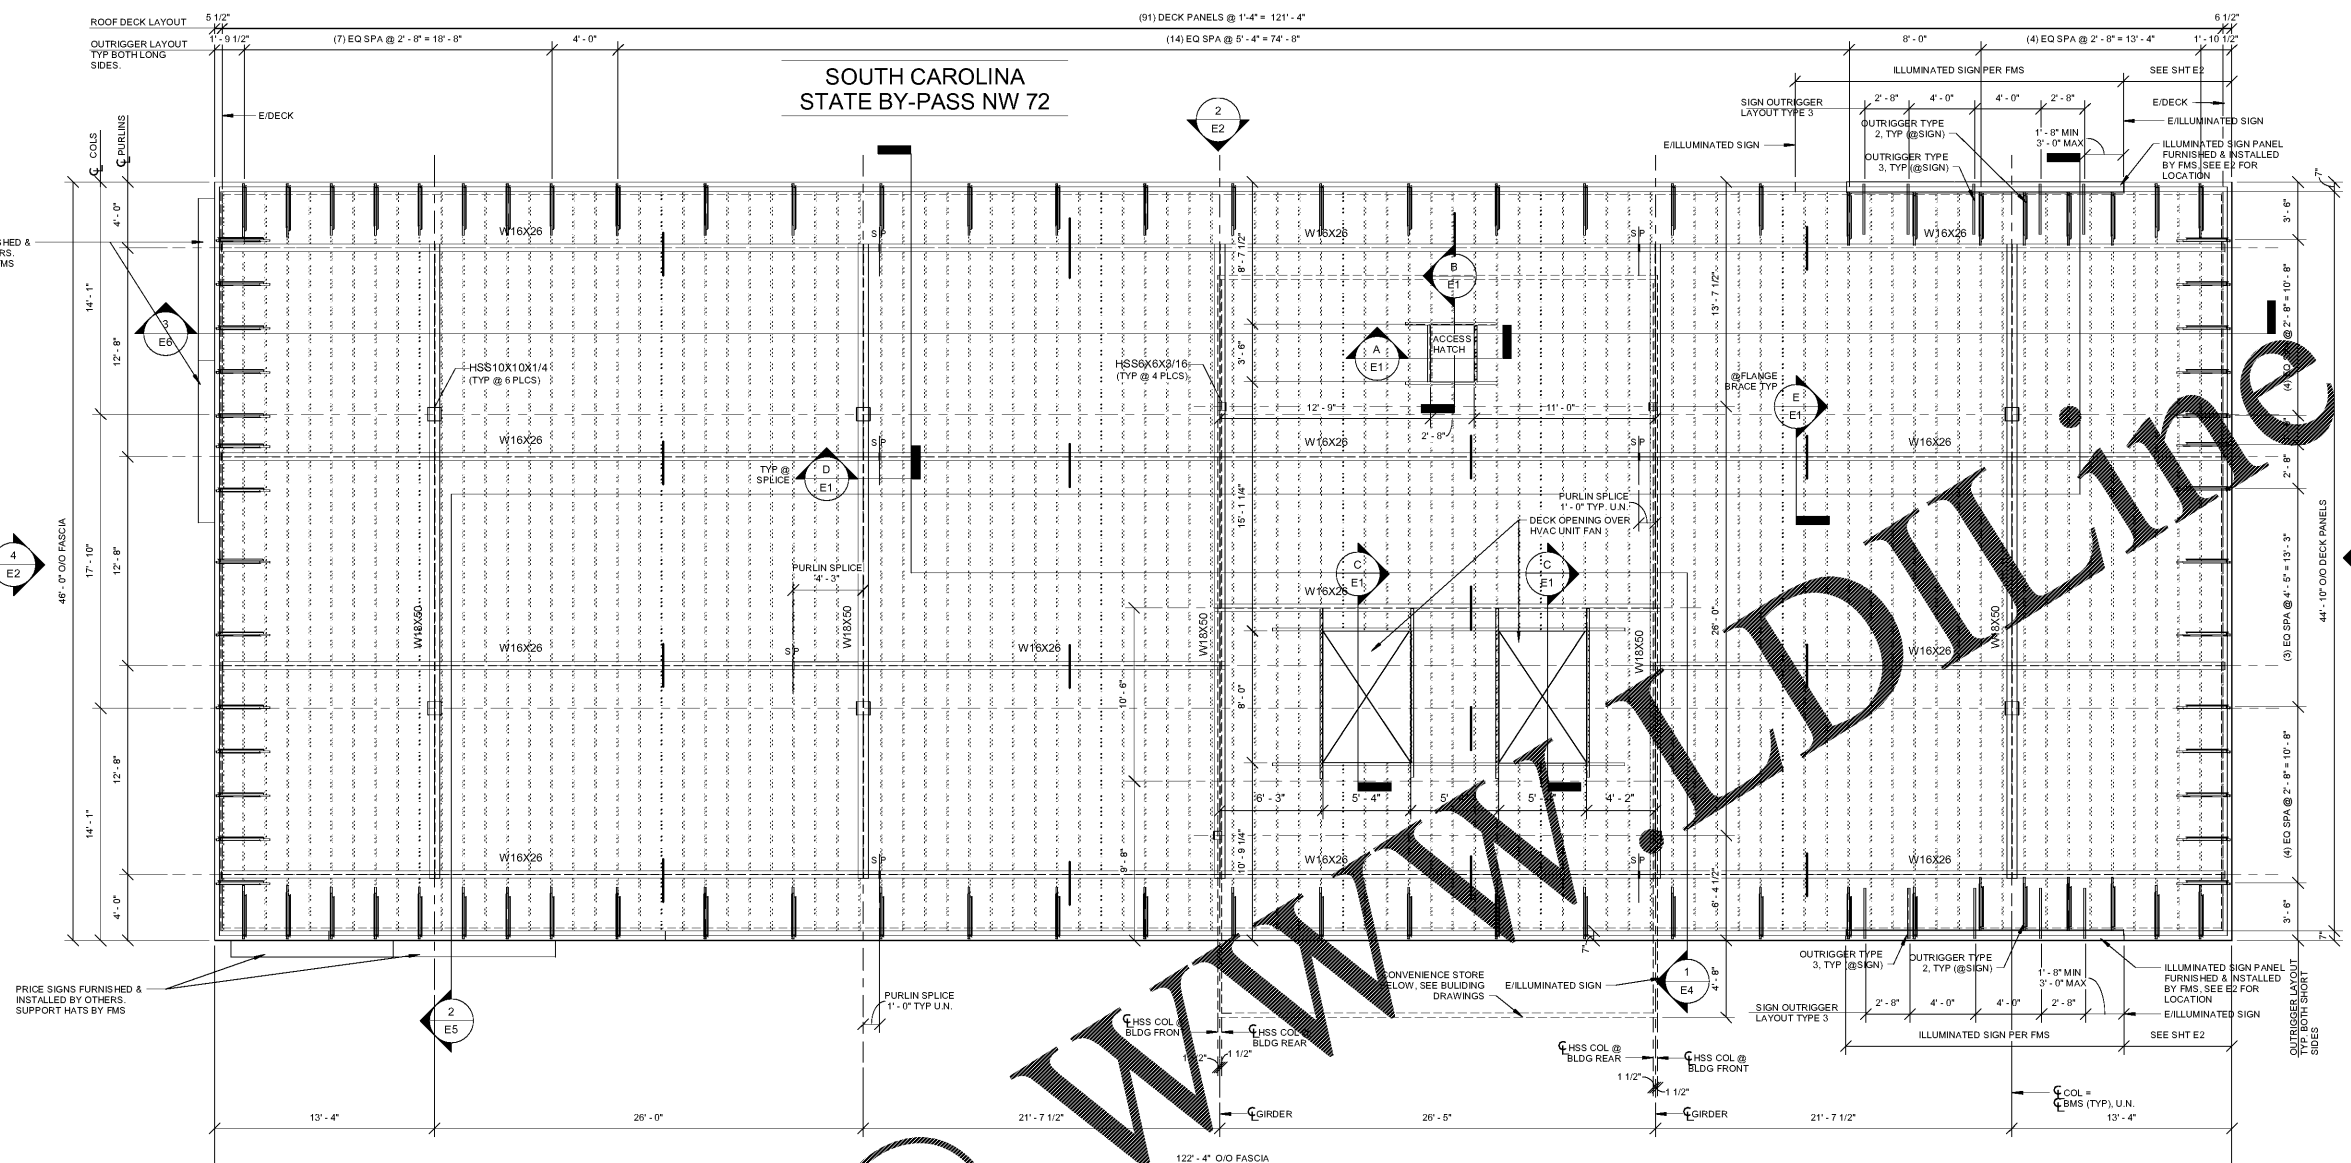


1 FRAMING PLAN
E1 3/16" = 1'-0"

FRAMING PLAN NOTES:
1. SEE SHEET S1 FOR STRUCTURAL GENERAL NOTES.
2. ALL ELEVATIONS REFERENCED FROM FINISH FLOOR ELEVATION OF 0'-0" FOR REFERENCE ONLY. SEE CIVIL FOR ACTUAL FINISH FLOOR ELEVATION.
3. S.P. INDICATES BEAM SPLICE. SEE SECTION D.E.1.
4. ROOF DECK SHALL BE 3"x16"x20" GA. ROLLED EMBOSSED WHITE ACRYLIC.
5. COORDINATE SIGN LOCATIONS WITH SHEET E2.
6. COORDINATE ILLUMINATED SIGN OUTRIGGER LOCATION AND REQUIREMENTS WITH FMS.

ERECTOR'S SCOPE OF WORK:
1. INSTALL STEEL COLUMNS, BEAMS AND PURLINS
2. INSTALL CANOPY CEILING DECK AND LIGHTS
3. INSTALL COLUMN TRIM
4. INSTALL SCUPPER, & OVERFLOWS (IF APPLICABLE) WHERE SHOWN ON E3
5. INSTALL OUTRIGGERS AND FASCIA PANELS
6. CLEAN & TOUCH UP ALL PRE-FINISHED MATERIAL (CAULK JOINTS PER SPECIFICATIONS BELOW)
7. REMOVE ALL FMS DEBRIS FROM JOB SITE

CAULKING SPECIFICATIONS:
1. CAULK THE FOLLOWING W/DOW CORNING #999-A WHITE SILICONE
1.1. COLUMN TRIMS TO DECK & COLUMN
1.2. ALL WHITE MATERIAL JOINTS
2. CAULK THE FOLLOWING W/OSI SBR-100 RUBBER CAULKING:
2.1. GUTTER FLASHING JOINTS
2.2. COLUMN TRIM TO COLUMN ABOVE DECK
2.3. FLANGE BRACE TO DECK
2.4. DECK PENETRATIONS

ITEMS NOT BY FMS:
1. ELECTRICAL
2. CONCRETE WORK
3. PERMITS
4. FURNISH LIGHTS
5. FURNISH PRICE SIGNS

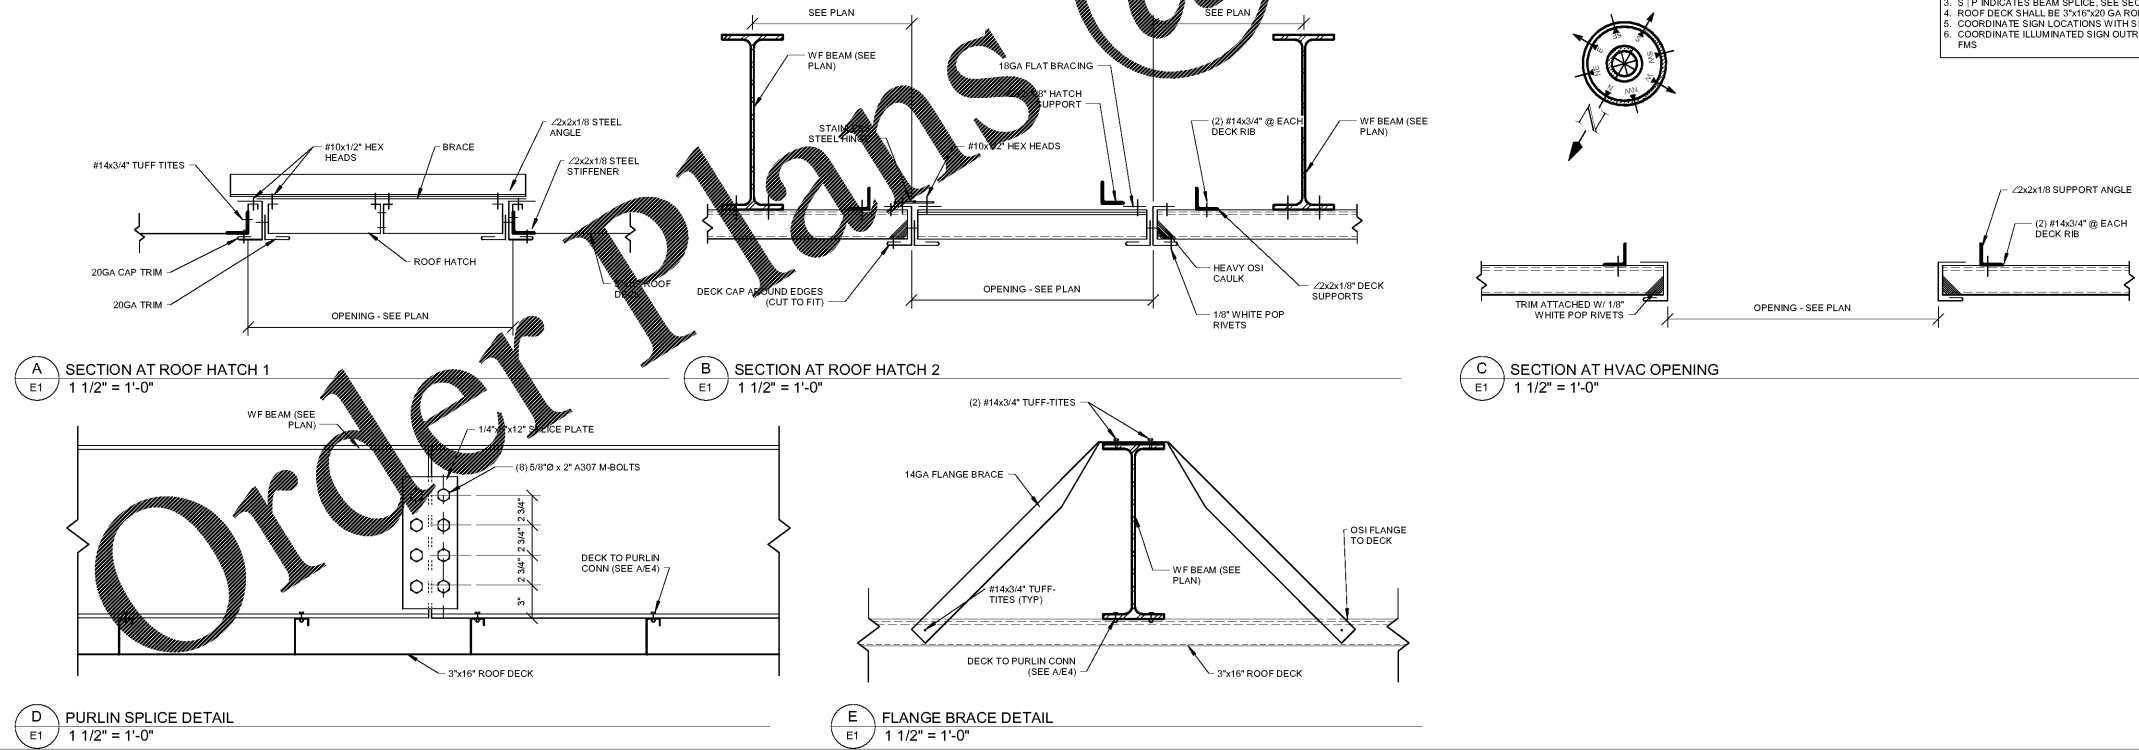

A SECTION AT ROOF HATCH 1
E1 1 1/2" = 1'-0"

B SECTION AT ROOF HATCH 2
E1 1 1/2" = 1'-0"

C SECTION AT HVAC OPENING
E1 1 1/2" = 1'-0"


D PURLIN SPLICE DETAIL
E1 1 1/2" = 1'-0"

E FLANGE BRACE DETAIL
E1 1 1/2" = 1'-0"

Order Plans @

**BAKER, INGRAM, & ASSOCIATES
STRUCTURAL ENGINEERS**

TWO WHITE HORSE PIKE HADDON HEIGHTS, NJ 08035
(856) 310-1491 fax: (856) 310-1829

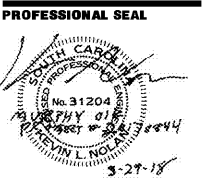

PROFESSIONAL IN CHARGE
K NOLAN
PROJECT MANAGER
M YOUNG
QUALITY CONTROL
B McGLADE
DRAWN BY
D MAHONEY

PROJECT NAME
MURPHY OIL FUEL FACILITY CANOPY
508 SC - 72

GREENWOOD, SC 29646



1801 Rockdale Industrial Blvd.
Conyers, Georgia 30012
Voice: (800) 366-6385
Fax: (770) 483-6037
FMS JOB NUMBER
G13XJL000026
FMS MODEL NUMBER
XXXXXX
PROJECT NUMBER
20170844.0

SHEET TITLE
FRAMING PLAN

SHEET NUMBER
E1

PROTO V3.0 01/03/2017