

Vaughn & Melton
Consulting Engineers, Inc.

Engineering - Surveying
300 Chastain Center Blvd, Ste 325
Kennesaw, Georgia 30144
TEL: (770) 627-3590 FAX: (770) 627-3594

V&M Contact:
Paul Noel Henmon, PE (770) 639-7797
KENTUCKY NORTH CAROLINA
606-245-6600 828-293-2795
TENNESSEE SOUTH CAROLINA
865-646-6800 864-574-4775
www.vaughnmelon.com
Copyright © 2015
All Rights Reserved

Schroeder Architects

ARCHITECTURE ■ INTERIORS ■ URBAN DESIGN

3118 E Shadowlawn Avenue, NE
Atlanta, Georgia 30305
Tel. 404.733.2828
Email: david@schroeder-architects.com
SAG2015



727 Atlanta Street NW
Atlanta, Georgia 30316
Phone: 404.350.9792


WESTBROOK
ENGINEERING

11300 Johns Creek Pkwy
Johns Creek, Georgia 30097
Phone: 770-753-9059
Email: jwestbrook@westbrookengineering.us

AH&P
CONSULTING
ENGINEERS

ANDREWS, HAMMOCK & POWELL, INC.
205 Dunwoody Lane
Suite 100
Macon, Georgia 31210
MACON (478) 495-4301
FAX (478) 405-8210
WWW.AHPENGR.COM

COPYRIGHT © 2015 BY SCHROEDER ARCHITECTS
ALL RIGHTS RESERVED. THESE DOCUMENTS AS
INSTRUMENTS OF SERVICE REMAIN THE PROPERTY
OF THE ARCHITECT AND NO PART MAY BE USED OR
REPRODUCED WITHOUT WRITTEN PERMISSION OF
THE COPYRIGHT OWNER.

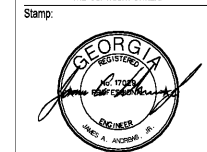

Project Name:
WISE AVENUE PARK
WISE AVENUE
MACON, GEORGIA 31201
Project Number: 180402
Drawn By: dew Ckd By: EDM
Date: 02/07/2018 Scale: AS SHOWN


Rev.	Description	Date
1	Issued For Permit	03/01/2018

Sheet Title:
**ELECTRICAL FLOOR
PLANS**


Sheet Number:
E101

NOTES: (THIS SHEET ONLY)

- ① PROVIDE JUNCTION BOX RATED FOR CEILING FAN APPLICATION. "SAFE OFF" CIRCUIT PROVISIONS & PROVIDE COVER.
- ② THIS FIXTURE SHALL BE UNSWITCHED.
- ③ SWITCH FANS ON ONE SWITCH & LIGHTS ON THE OTHER SWITCH (SET "MGR" FOR 1 HOUR).
- ④ SET SWITCH "OFF DELAY" FOR 20 MINUTES, TYPICAL OF (3).
- ⑤ ROUTE EF-1, EF-2 AND EF-3 THRU SPEED CONTROL, BY MECHANICAL.

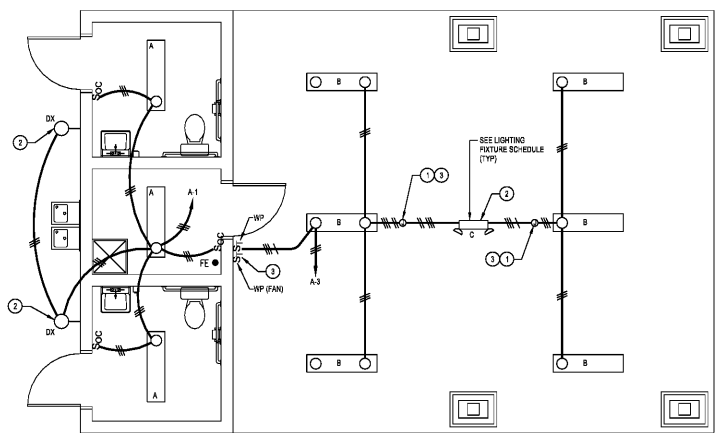

ELECTRICAL LIGHTING FLOOR PLAN
SCALE: 1/4"=1'-0"

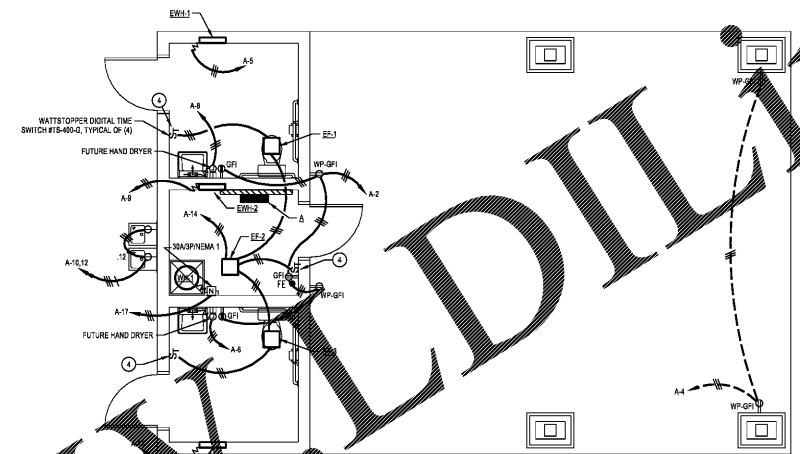

ELECTRICAL POWER FLOOR PLAN
SCALE: 1/4"=1'-0"

Order Plans @ www.LDILine.com