




PROJECT TITLE  
 CITY OF BIRMINGHAM  
 PARKS & RECREATION  
 PRE-FABRICATED  
 BUILDINGS PACKAGE  
 SITE  
 A.G. GASTON PARK  
 916 WASHINGTON AVENUE  
 BIRMINGHAM, AL 35211

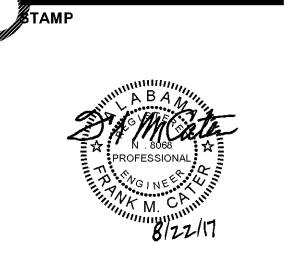



STAMP  
 1721 4TH AVENUE  
 NORTH, SUITE 101  
 BIRMINGHAM, AL 35203  
 www.studio2hd.com  
 OFFICE: 205-264-9988  
 FAX: 205-264-9992

NOT FOR CONSTRUCTION   
 RELEASED FOR CONSTRUCTION   
 DATE: AUGUST 23, 2017  
 DRAWN BY: JLB  
 REVIEWED BY: OWP

REUSE OF DOCUMENTS  
 THIS DOCUMENT, THE IDEAS AND DESIGNS INCORPORATED HEREIN, IS AN INSTRUMENT OF STUDIO 2H DESIGN, LLC AND MUST NOT BE USED IN WHOLE OR IN PART, FOR ANY OTHER PROJECT WITHOUT THE WRITTEN AUTHORIZATION OF STUDIO 2H DESIGN, LLC  
 NOLANDA HATCHER & CREIG HOSKINS

REVISIONS

Revision	Date	Description

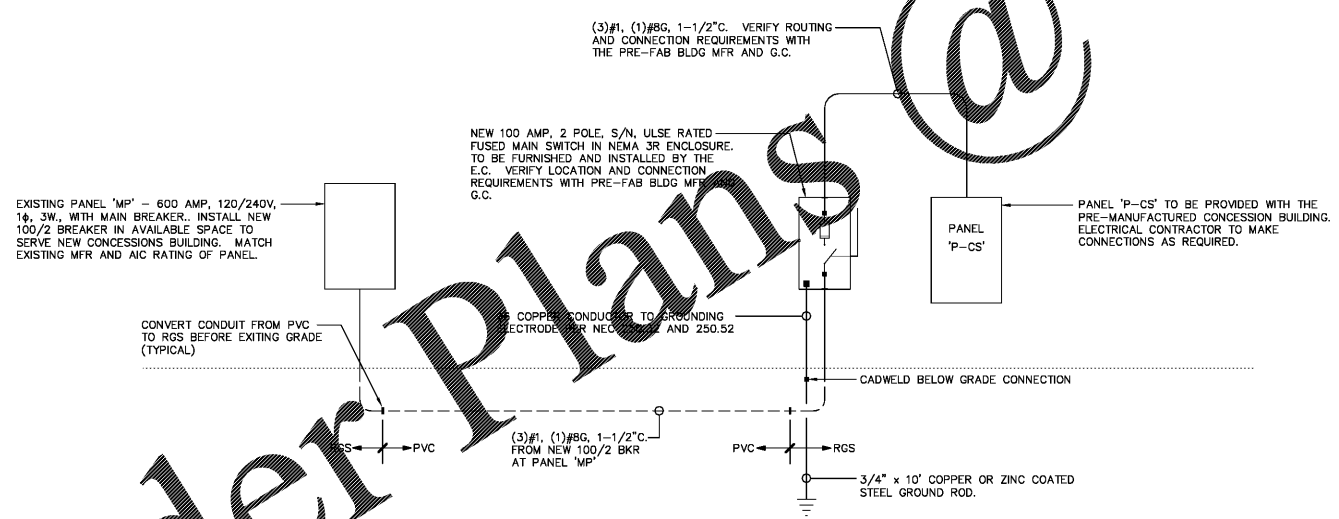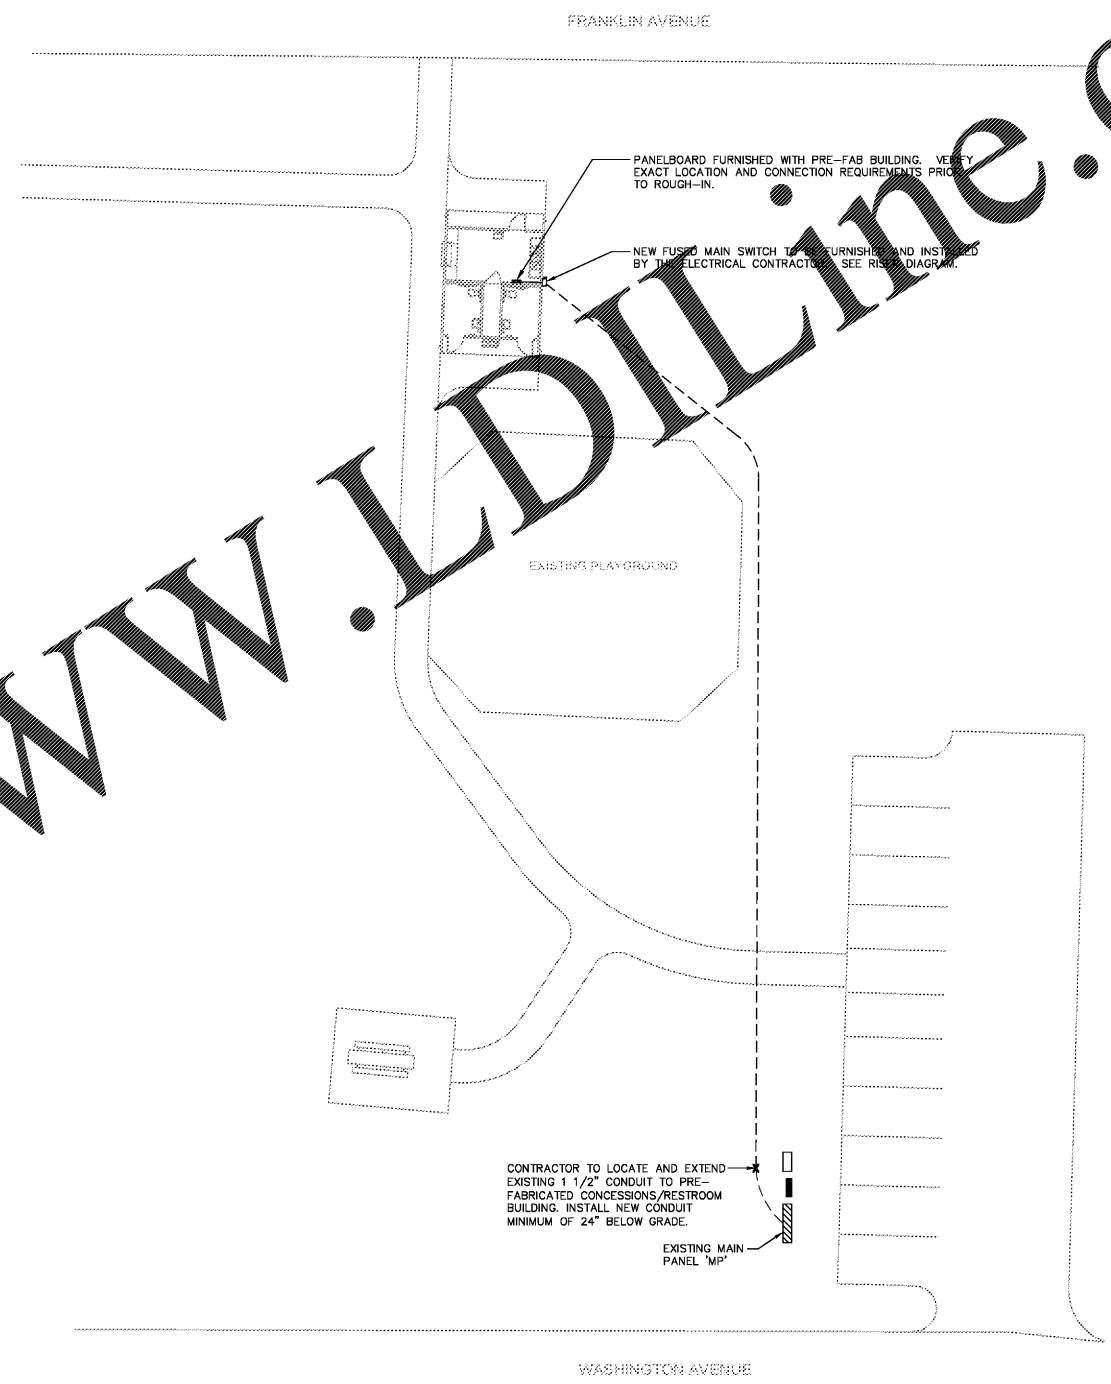

ELECTRICAL RISER DIAGRAM  
 SCALE: NONE

A.G. GASTON  
 SITE PLAN - ELECTRICAL  
 SCALE: 1/16" = 1'-0"

SHEET TITLE  
 A.G. GASTON SITE  
 PLAN - ELECTRICAL  
 DRAWING NUMBER  
**E1.1**  
 PROJECT NUMBER  
 201628

Order Plans @ www.LDLine.com