

PROJECT TITLE
 CITY OF BIRMINGHAM
 PARKS & RECREATION
 PRE-FABRICATED
 BUILDINGS PACKAGE
 SITE 1
 COB PUBLIC WORKS
 860 GOLDEN FLAKE DR.
 BIRMINGHAM AL 35205

**CONSULTING
 CONSTRUCTION
 ENGINEERING, LLC**
 110 12th Street North
 Birmingham, Alabama 35203
 Phone: (205) 352-2500 Web: www.cce-eng.com
 CCE No. 1752-03 Date: Aug 22, 2017
 File: ES-04 GOLDEN FLAKE.dwg Time: 4:14:16 pm

STAMP


STUDIO 2H
 DESIGN
 1721 4TH AVENUE
 NORTH, SUITE 101
 BIRMINGHAM, AL 35203
 www.studio2hd.com
 OFFICE: 205-264-9988
 FAX: 205-264-9992


NOT FOR CONSTRUCTION
 RELEASED FOR CONSTRUCTION
 DATE: AUGUST 23, 2017
 DRAWN BY: JLB
 REVIEWED BY: OWP

REUSE OF DOCUMENTS
 THIS DOCUMENT, THE IDEAS AND DESIGNS INCORPORATED HEREIN, IS AN INSTRUMENT OF STUDIO 2H DESIGN, LLC AND MUST NOT BE USED IN WHOLE OR IN PART, FOR ANY OTHER PROJECT WITHOUT THE WRITTEN AUTHORIZATION OF STUDIO 2H DESIGN, LLC
 NOLANDA HATCHER & CREIG HOSKINS


REVISIONS

| Revision | Date | Description |
|----------|------|-------------|
| | | |
| | | |
SHEET TITLE
**GOLDEN FLAKE SITE
 PLAN - ELECTRICAL**
 DRAWING NUMBER
E1.5
 PROJECT NUMBER
201628

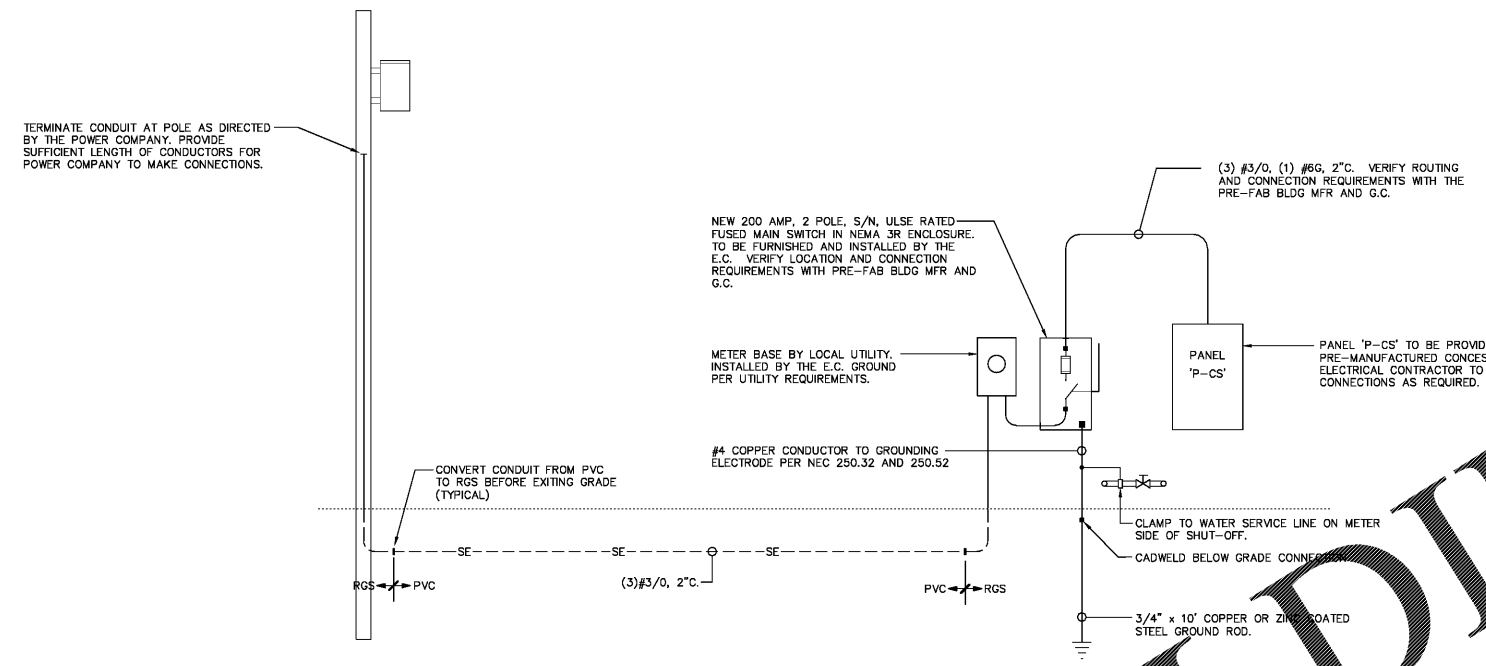

ELECTRICAL RISER DIAGRAM
 SCALE: NONE

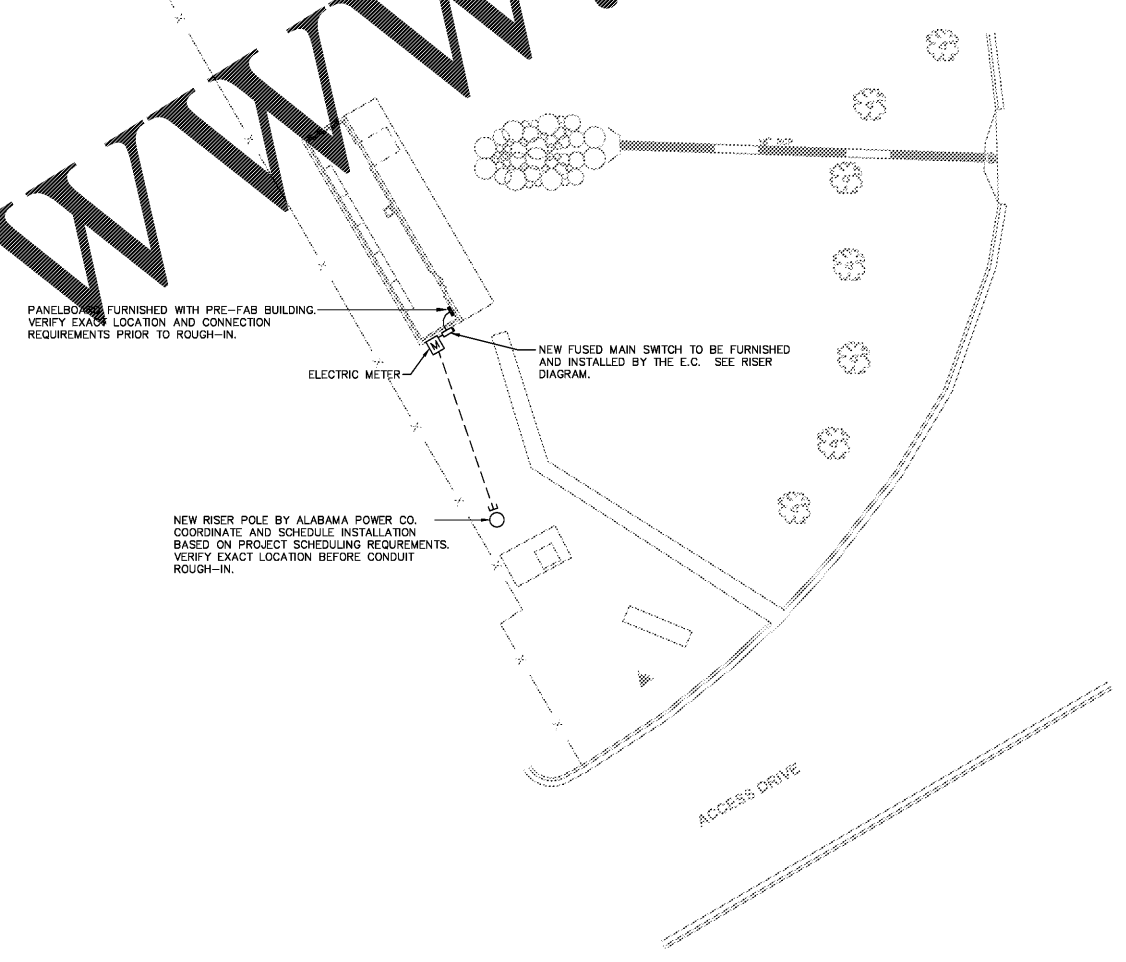

 **GOLDEN FLAKE
 SITE PLAN - ELECTRICAL**
 SCALE: 1/16" = 1'-0"

Order Plans @

WWW.LDILine.com