

PROJECT TITLE  
 CITY OF BIRMINGHAM  
 PARKS & RECREATION  
 PRE-FABRICATED  
 BUILDINGS PACKAGE  
 SITE  
 COB PUBLIC WORKS  
 866 GOLDEN FLAKE DR.  
 BIRMINGHAM AL 35205

**CONSULTING  
 ENGINEERING, LLC**  
 110 12th Street North  
 Birmingham, Alabama 35203  
 Phone: (205) 352-2500 Web: www.cce-eng.com  
 CCE No. 1752-03 Date: Aug 22, 2017  
 File: ES-04 GOLDEN FLAKE.dwg Time: 4:14:16 pm



**2H DESIGN**  
 1721 4TH AVENUE  
 NORTH, SUITE 101  
 BIRMINGHAM, AL 35203  
 www.studio2hd.com  
 OFFICE: 205-264-9988  
 FAX: 205-264-9992


NOT FOR CONSTRUCTION   
 RELEASED FOR CONSTRUCTION   
 DATE: AUGUST 23, 2017  
 DRAWN BY: JLB  
 REVIEWED BY: OWP

**REUSE OF DOCUMENTS**  
 THIS DOCUMENT, THE IDEAS AND DESIGNS INCORPORATED HEREIN, IS AN INSTRUMENT OF STUDIO 2H DESIGN, LLC AND MUST NOT BE USED IN WHOLE OR IN PART, FOR ANY OTHER PROJECT WITHOUT THE WRITTEN AUTHORIZATION OF STUDIO 2H DESIGN, LLC  
 NOLANDA HATCHER & CREIG HOSKINS


**REVISIONS**

Revision	Date	Description

SHEET TITLE  
**GOLDEN FLAKE SITE  
 PLAN - ELECTRICAL**  
 DRAWING NUMBER  
**E1.5**  
 PROJECT NUMBER  
**201628**

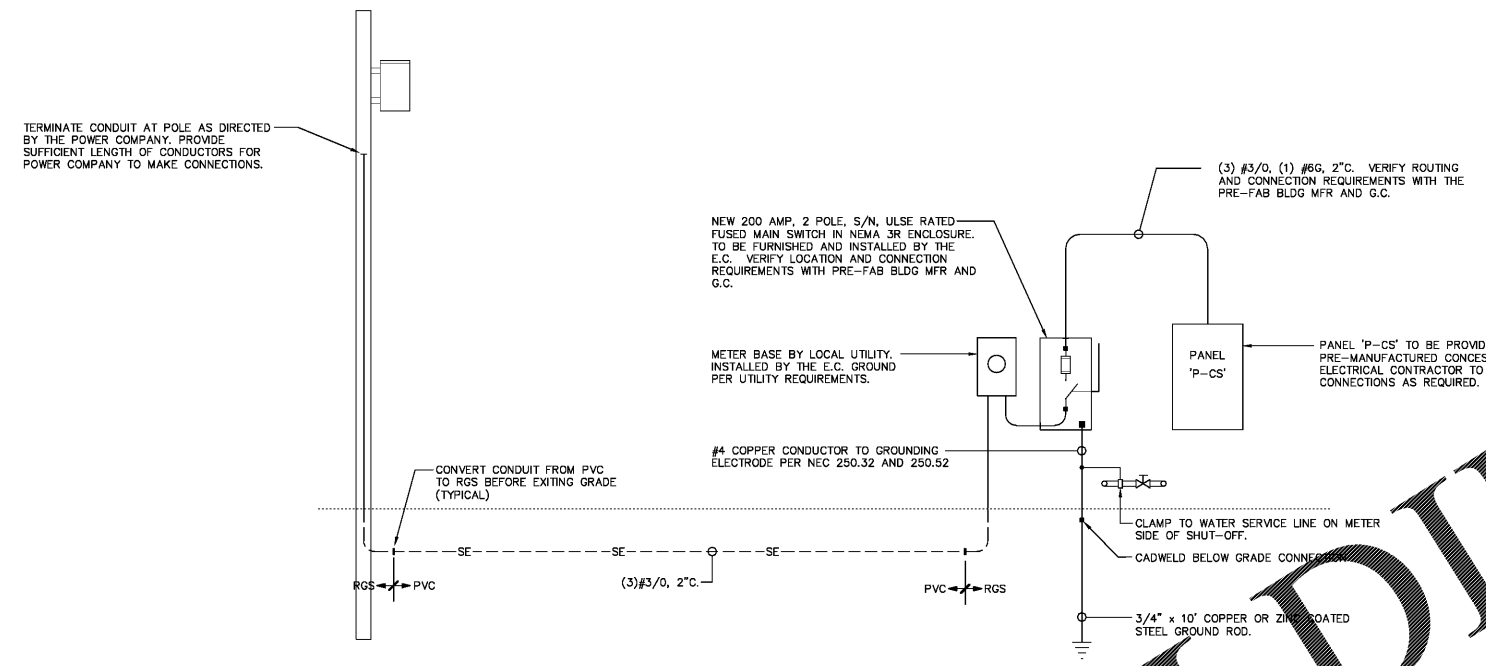

**ELECTRICAL RISER DIAGRAM**  
 SCALE: NONE

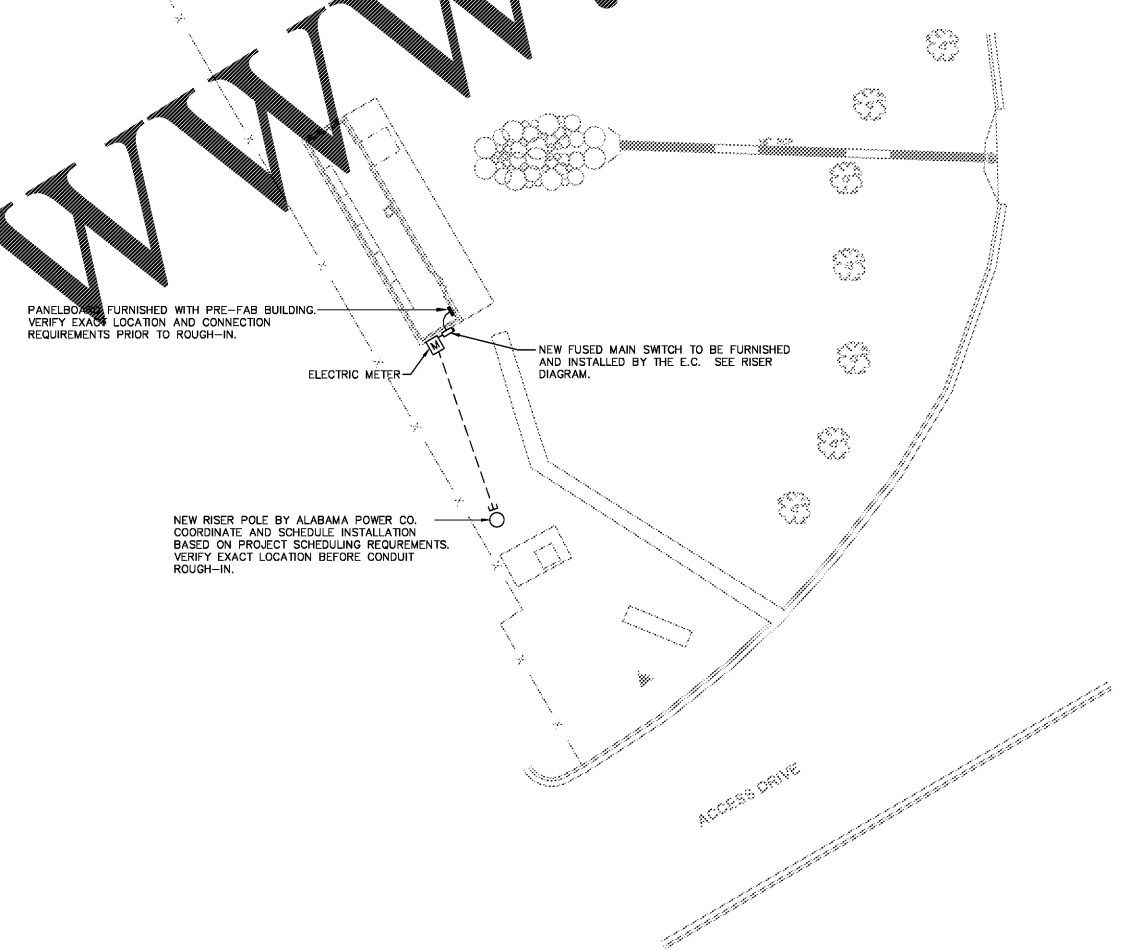

**GOLDEN FLAKE  
 SITE PLAN - ELECTRICAL**  
 SCALE: 1/16" = 1'-0"

Order Plans @

WWW.LDILine.com