

FLOOR TROUGH DETAIL
1" = 1'-0"

FLOOR PLAN LEGEND

- GENERAL NOTES**
- A. SEE PLUMBING PLANS FOR IN-SLAB PLUMBING ROUGH-IN LOCATIONS.
 - B. SEE REFLECTED CEILING PLAN FOR SOFFIT DESIGN EXTENTS.
 - C. SEE EXTERIOR ELEVATIONS FOR ADDITIONAL STOREFRONT LOCATIONS.
 - D. ALL DOORS TO BE LOCATED 6" OFF ADJACENT WALL UNLESS DIMENSIONED OTHERWISE.
- INTERIOR PARTITION NOTES**
- IP-1. ALL WALLS SHOWN TO BE 8" CMU BLOCK INSTALLED TO A MINIMUM OF 2" ABOVE FINISHED CEILING (A MAXIMUM OF 8" ABOVE FINISHED CEILING, UNLESS NOTED OTHERWISE. REFER TO INTERIOR PARTITION WALL TYPE AND CONSTRUCTION LEGEND FOR ADDITIONAL WALL TYPES.
 - IP-2. REFER TO STRUCT. DWGS. FOR LOCATIONS & EXTENT OF REINFORCED CMU WALLS AND BRACING TO STRUCTURE.
 - IP-3. FOR 1 HOUR FIRE RATED WALLS WITH EXPOSED STRUCTURES ON 1 SIDE, START GYPSUM BOARD A MIN. OF 8" ABOVE HIGHEST ADJACENT CEILING, UNLESS NOTED OTHERWISE.
- FIRE AND SMOKE PARTITIONS**
- FP-4. PROVIDE A SMOKE TIGHT BARRIER AT ALL CORNER JOINTS TO ROOMS, JANITORS CLOSETS AND STORAGE/UTILITY ROOMS, UNLESS A HIGH FIRE/SMOKE RATING IS DEFINED ON THESE DRAWINGS. SEE REFLECTED CEILING PLAN FOR ADDITION REQUIREMENTS AT THESE AREAS.

INTERIOR PARTITION SCHEDULE

INTERIOR PARTITION WALL CONSTRUCTION LEGEND	DESCRIPTION
1	STAINLESS PARTITION 8" CMU TO 2" MIN. ABOVE FINISHED CEILING
2	8" CMU PARTITION 8" CMU UP TO 2" MIN. ABOVE FINISHED CEILING
3	8" CMU PARTITION 8" CMU (36) OR 12" CMU (26) UP TO 8" ABOVE FINISHED CEILING
4	1 HOUR FIRE RATED PARTITION & SMOKE PARTITION: 8" CMU (42) OR 12" CMU (48) TO 8" ABOVE CEILING, 5/8" GYPSUM BOARD ON SA SIDE OF 8" 2 GA. METAL STUDS @ 24" O.C. TO DECK, SEAL TIGHT TO DECK. SEE SCHEDULE NOTE #2 BELOW. UL DESIGN #A1005 & #A1465.
5	2 HOUR FIRE RATED PARTITION @ FIREWALL: 8" CMU FLUSH TO ROOF DECK, UL DESIGN #1005
6	8" CMU 1 HOUR AND SOUND WALL: 8" CMU FLUSH TO ROOF DECK, SEAL TIGHT TO DECK, FILL ALL VOID CELLS WITH FOAM IN PLACE MASONRY INSULATION, SOUND SEAL ALL PENETRATIONS, UL DESIGN # 1005
7	8" CMU TOILET STALL WALL, 8" CMU UP TO 6'-0" A.F.F. WITH CAST CONCRETE TOP, SEE DETAIL C/A4.1
8	8" CMU TOILET STALL WALL, 8" CMU UP TO 6'-0" A.F.F. WITH CAST CONCRETE TOP, SEE DETAIL C/A4.1
9	8" CMU PARTIAL HEIGHT WALL, 8" CMU UP TO HEIGHT AS INDICATED ON PLAN OR SECTION
10	4" CMU FURNING WALL, 4" CMU UP TO 2" MIN. ABOVE FINISHED CEILING


SCHEDULE NOTES:

- PARTITION TYPES NOT SHOWN ALONG INTERIOR DOOR AND WINDOW HEADERS FOR CLARITY. WHERE APPLICABLE, PARTITION TYPE DEFINED ADJACENT TO HEADERS SHALL CONTINUE OVER SUCH HEADERS, UNLESS NOTED OTHERWISE.
- FOR 1 HOUR FIRE RATED WALLS WITH EXPOSED STRUCTURES ON ANY SIDE, START GYPSUM BOARD A MIN. OF 8" ABOVE HIGHEST ADJACENT CEILING, UNLESS NOTED OTHERWISE.
- WALLS NOT TAGGED WILL BE SAME TYPE AS ADJACENT WALLS UNLESS NOTED OTHERWISE.


FLOOR PLAN SYMBOL LEGEND

SYMBOL	DESCRIPTION
A01	ROOM NAME
A02	ROOM DESIGNATION
AXX	ELEVATION INDICATOR
X	SECTION CUT INDICATOR
ENLARGED FLOOR PLAN	ENLARGED FLOOR PLAN
FP 1	DRAWING NOTE REFERENCE SEE BELOW
AS1	EXTERIOR STOREFRONT WINDOW NUMBER, SEE SHEET A6.1
1	INTERIOR HOLLOW METAL WINDOW NUMBER, SEE SHEET A6.1
A01A1	DOOR NUMBER, SEE DOOR AND SIGN SCHEDULE
S	SIGN TYPE, SEE DOOR AND SIGN SCHEDULE
2	SLAB RECESS, UNLESS NOTED OTHERWISE
FE1	FIRE EXTINGUISHER TYPE 1: A/B/C - DRY CHEMICAL SEMI-RECESSED CABINET SEE DETAIL
FE2	FIRE EXTINGUISHER TYPE 2: K - WET CHEMICAL BRACKET SURFACE MOUNT

- FLOOR PLAN DRAWING NOTES**
- FP 1. 4" BRICK WATER TABLE TO 3'-4" A.F.F. REF. INTERIOR ELEVATION AND SECTION FOR DETAIL.
 - FP 2. 4" BRICK PILLASTER TO 10'-0" A.F.F. REF. INTERIOR ELEVATION AND SECTION FOR DETAIL.
 - FP 3. CMU WALL TO UNDERSIDE OF STRUCTURE OR FLUSH TO DECK, SEAL TIGHT.
 - FP 4. LADDER THROUGH ROOF HATCH TO ROOF, SEE DETAIL A/A1.4.

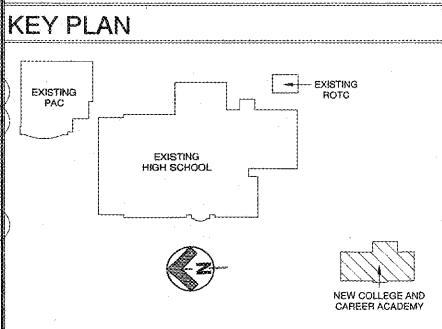

ROBERTSON INDIA ROOF ARCHITECTS ENGINEERS
3460 Preston Ridge Road, Suite 275, Marietta, GA 30065
770.974.2600 / www.rifac.com

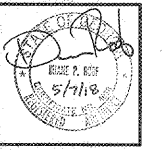

(Facility No. 642-0198)
Dawson County College and Career Academy
Dawsonville, Georgia
Dawson County Schools
Overall Square Footage = 35,800 SF
FFE = 1603
Title = 74 (Existing) + 11 (New) = 85 TUs

REVISIONS


NO.	DESCRIPTION

LOWER LEVEL FLOOR PLAN

DATE: 05-07-2018

PROJECT NUMBER: 17-303

SHEET NUMBER: A1.2a

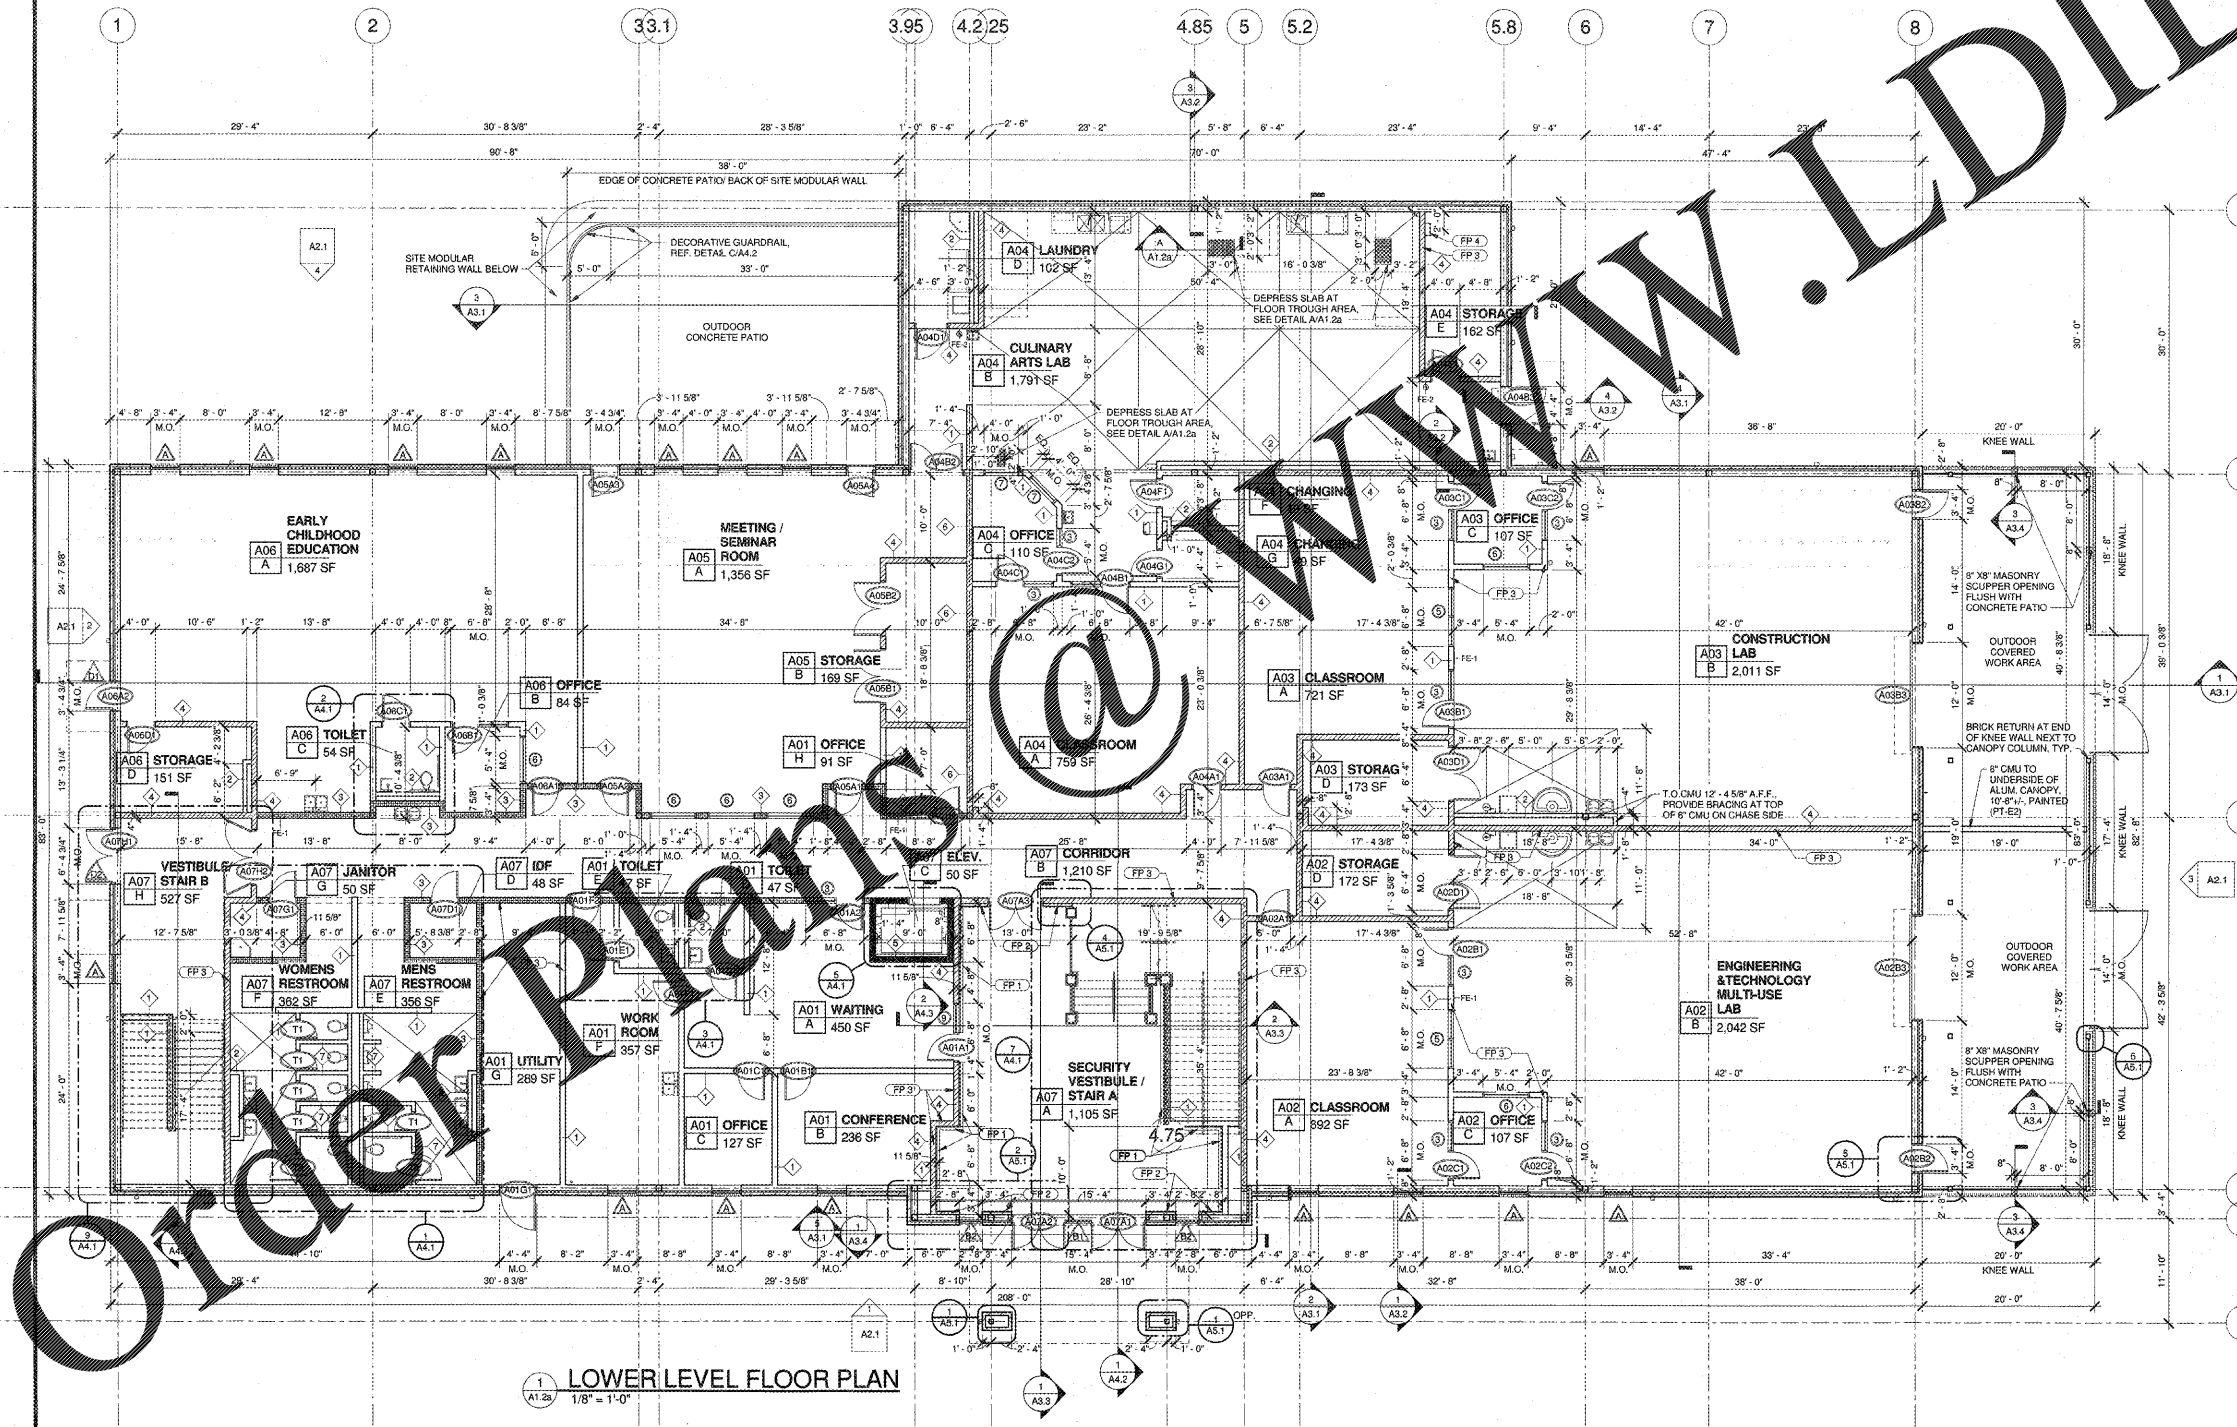

1 LOWER LEVEL FLOOR PLAN
1/8" = 1'-0"