


Order Plans @

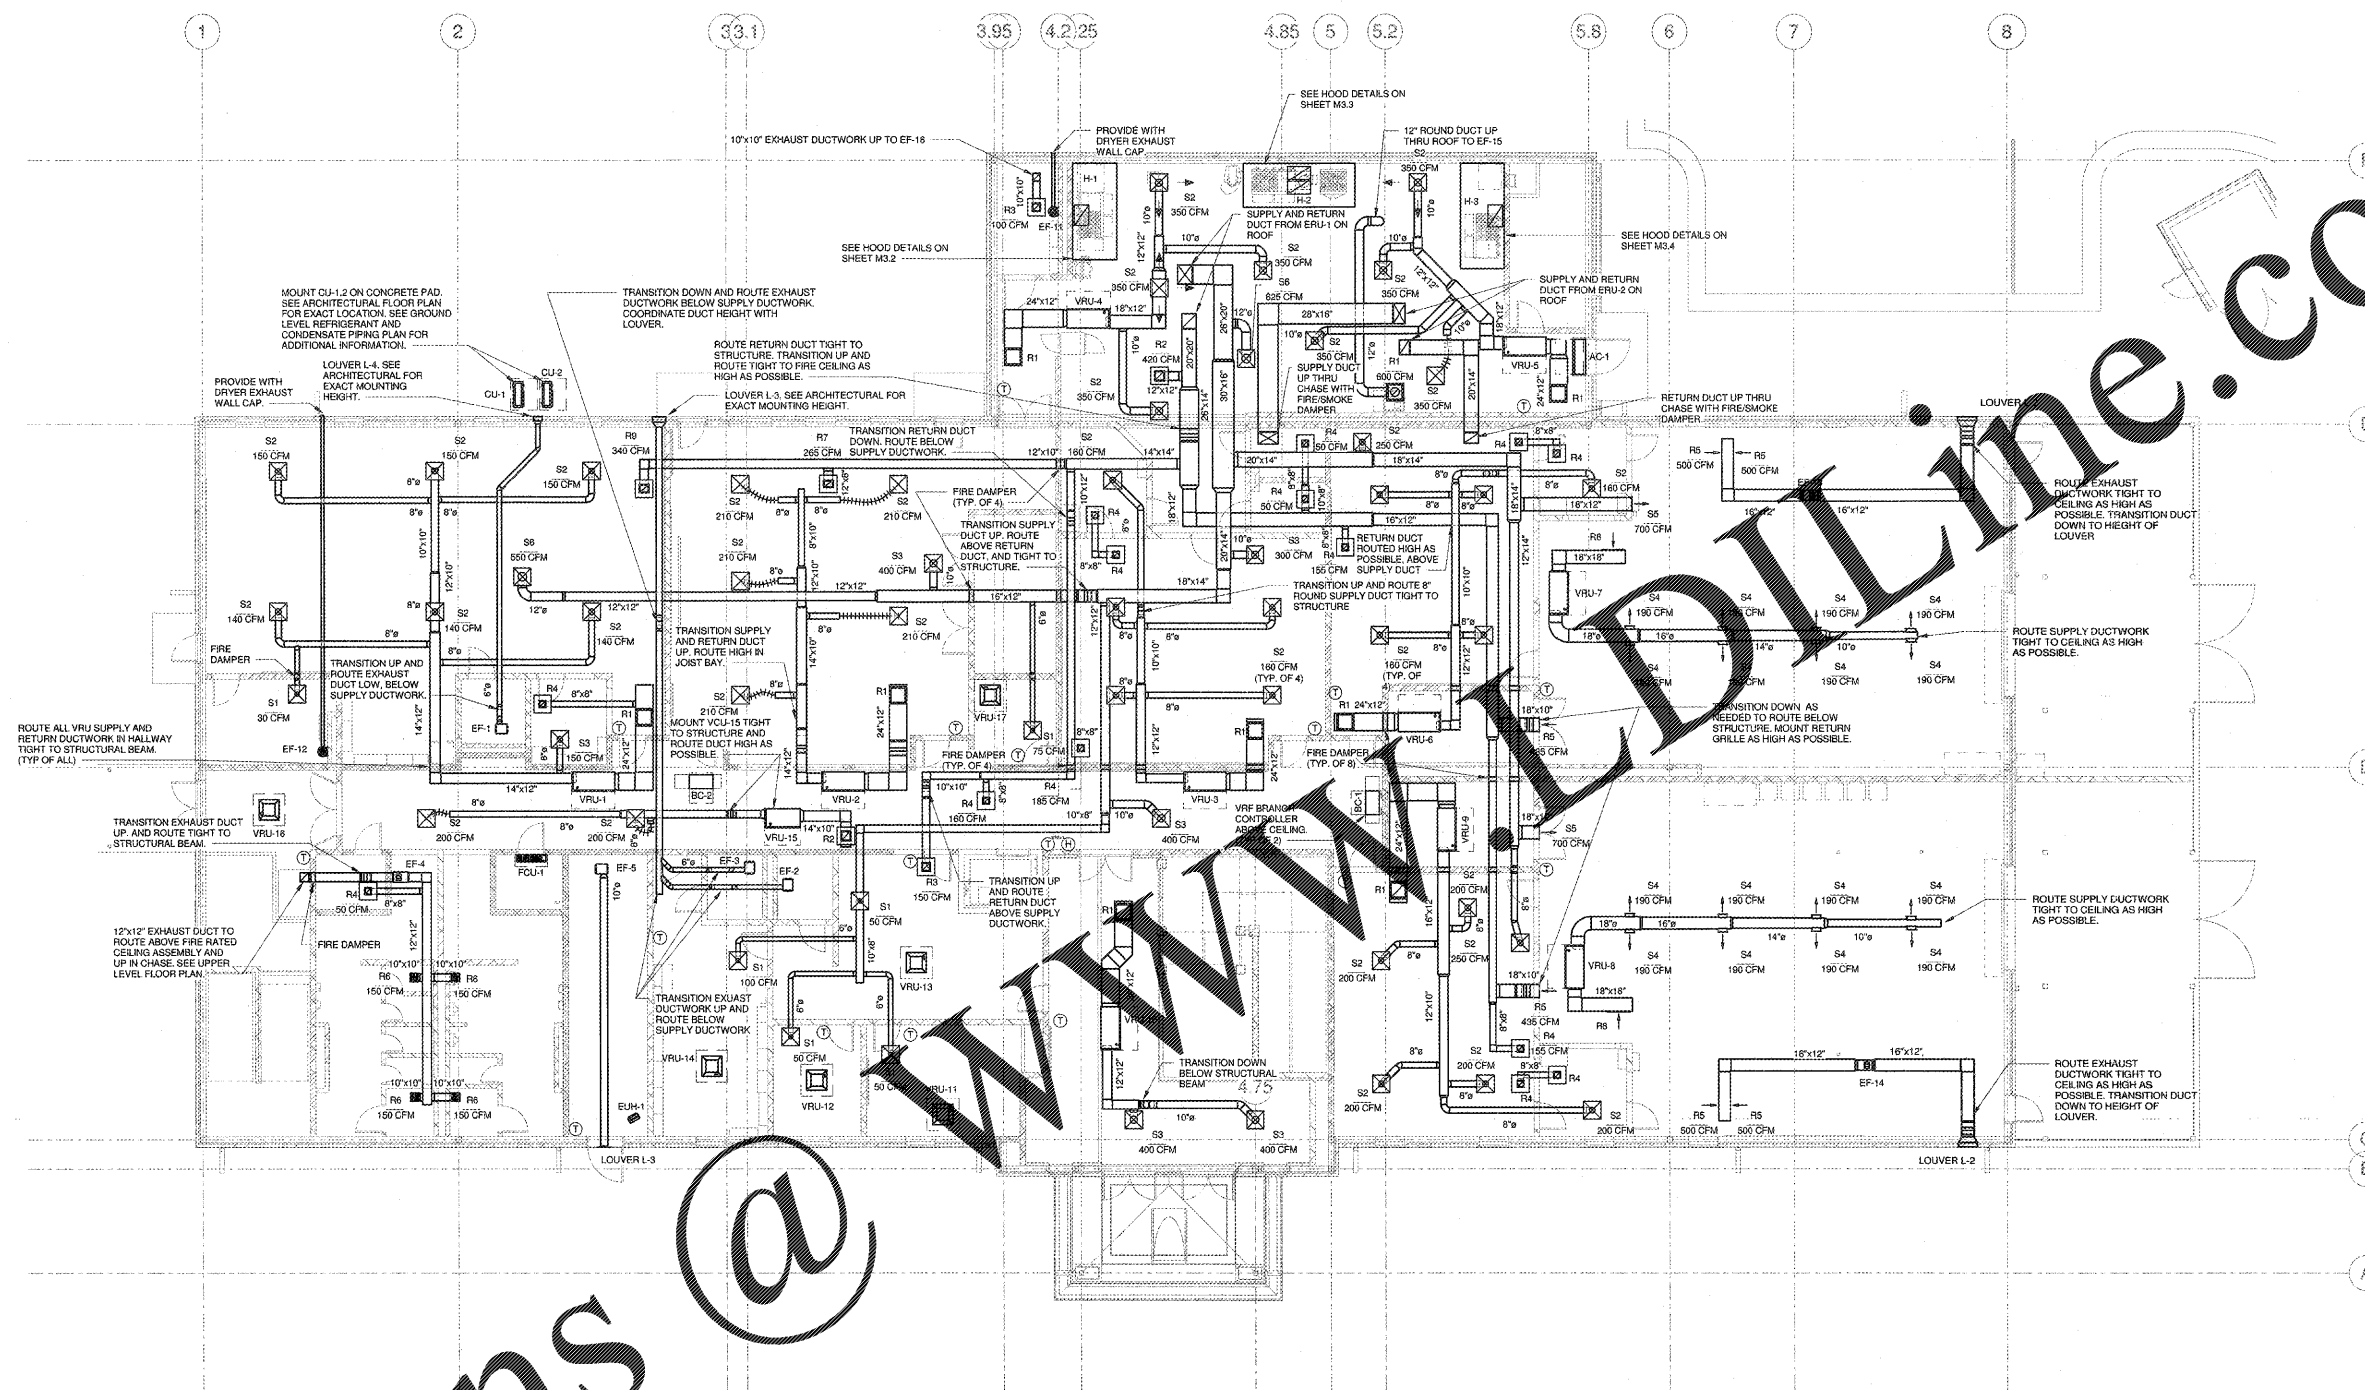

1 HVAC GROUND LEVEL FLOOR PLAN
1/8" = 1'-0"

ROBERSON DIA ROOF ARCHITECTS ENGINEERS
3460 Preston Ridge Road, Suite 275, Marietta, GA 30065
770.674.2600 / www.rdia.com



(Facility No. 642-0196)

Dawson County College and Career Academy
Dawsonville, Georgia
FOR:
Dawson County Schools
Overall Squarefootage = 35,800 SF
FTE = 1625
TUs = 74 (Existing) + 11 (New) = 85 TUs

REVISIONS

NO.	DESCRIPTION

HVAC - LOWER LEVEL FLOOR PLAN

DATE: 05-07-2018

PROJECT NUMBER: 17-303

SHEET NUMBER:

M1.1