



Client	USA
Project	Dawson County HS
Title	Fabric schematic
Author	VRU-1
Check	VRU-1
Date	05/07/2018
Drawn by	

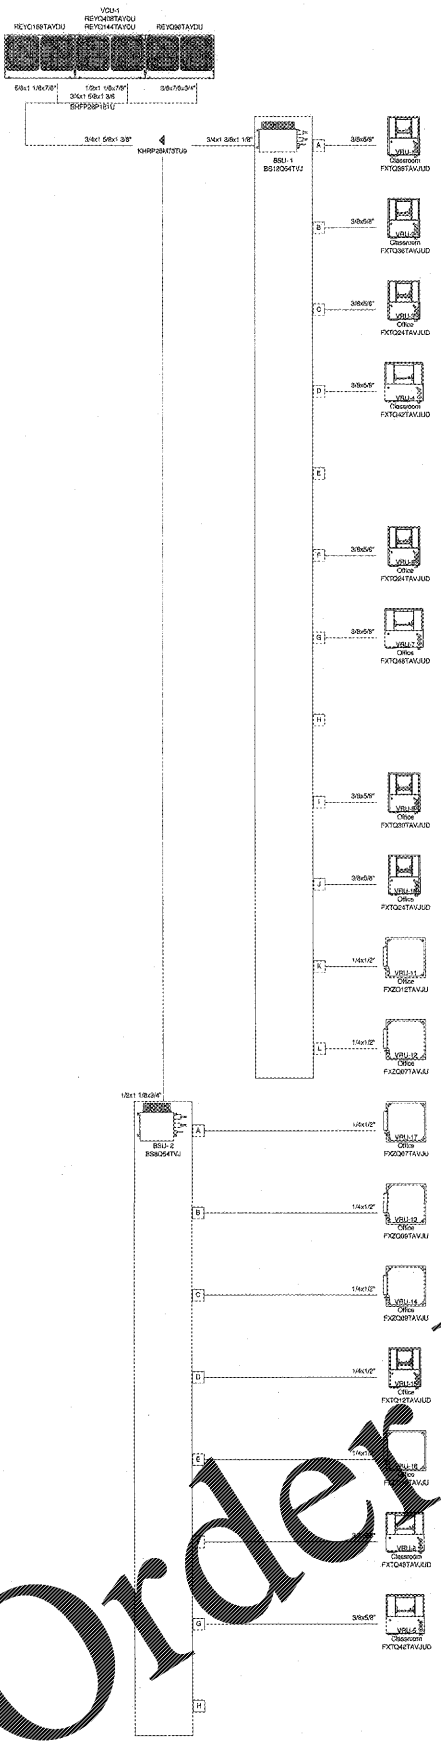

- CONDENSATE NOTES:**
1. ALL CONDENSATE PIPING SHALL BE TYPE "L" COPPER AND ROUTED WITH POSITIVE SLOPE TOWARDS DISCHARGE POINT.
  2. ALL UNIT CONNECTIONS TO BE SIZED AT 3/4" UNLESS INDICATED OTHERWISE.
  3. CONTRACTOR SHALL NOT ROUTE ANY CONDENSATE PIPING OVER ELECTRICAL EQUIPMENT OR PANELS.
  4. CONTRACTOR SHALL PROVIDE SUPPORTS FOR PIPING WITH MAXIMUM SPACING OF 10'-0" ON CENTER ON TOP OF WALLS WHERE PRACTICAL. WHERE SUSPENDED FROM STRUCTURE CONTRACTOR SHALL PROVIDE LATERAL SUPPORT TO PREVENT SWAYING.
  5. PROVIDE CONDENSATE PUMP LITTLE GIANT MODEL TPR OR EQUIVALENT IF REQUIRED TO COORDINATE WITH FIELD CONDITIONS.

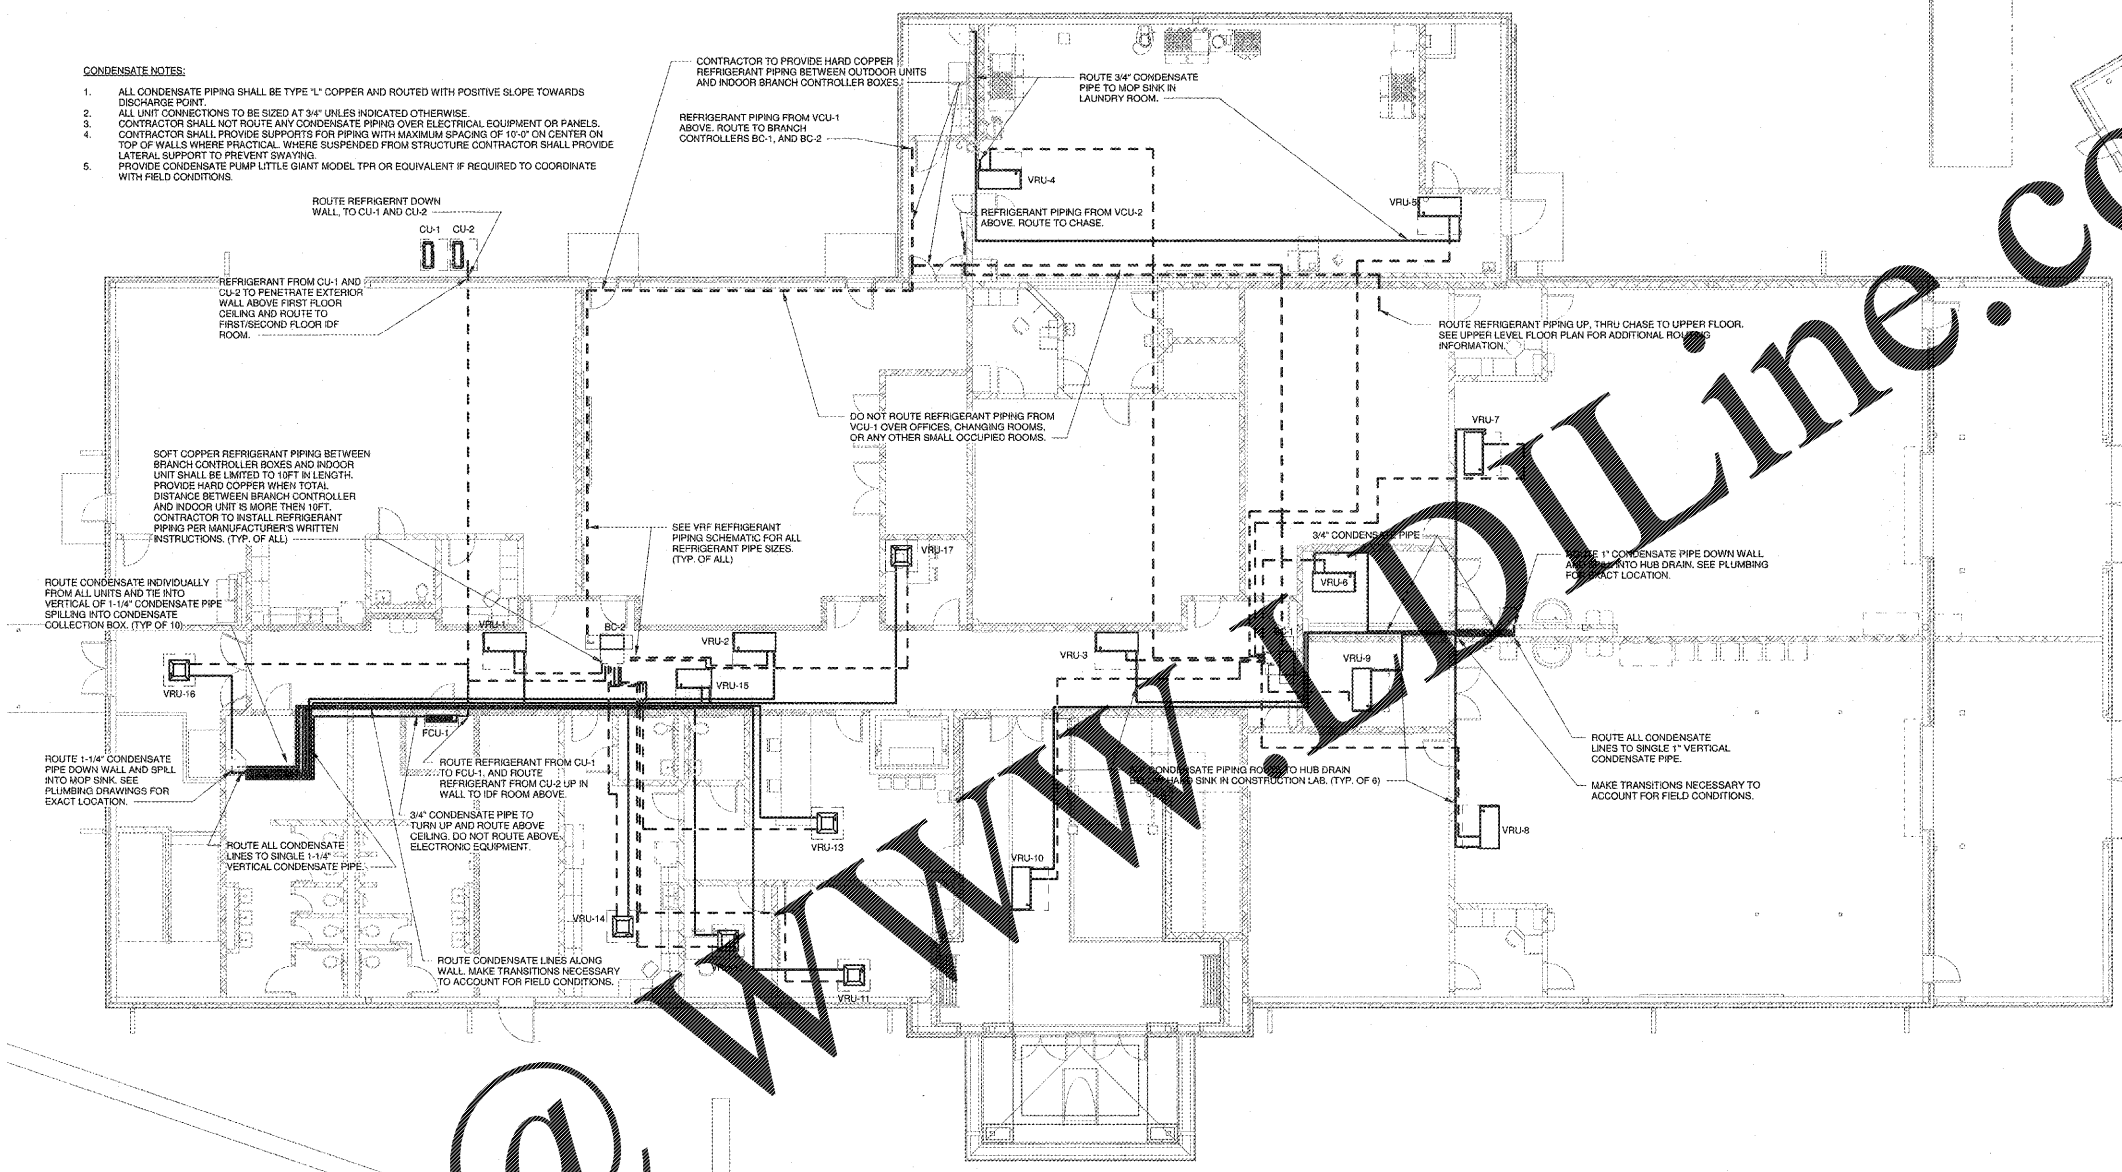

1 HVAC GROUND LEVEL REFRIGERANT AND CONDENSATE PIPING PLAN  
1/8" = 1'-0"

Order Plans @

**ROBERTSON INDIA ROOF ARCHITECTS ENGINEERS**  
3400 Preston Ridge Rd., Suite 275 - A, Marietta, GA, 30065  
770.474.2600 / www.rir.com



Facility No. 642-0108  
**Dawson County College and Career Academy**  
Dawsonville, Georgia  
**Dawson County Schools**  
Overall Squarefootage = 35,800 SF  
LTFE = 1025

REVISIONS

DATE	05-07-2018
PROJECT NUMBER	17-303
SHEET NUMBER	M2.1