


2 WATER HEATER RISER LOWER LEVEL

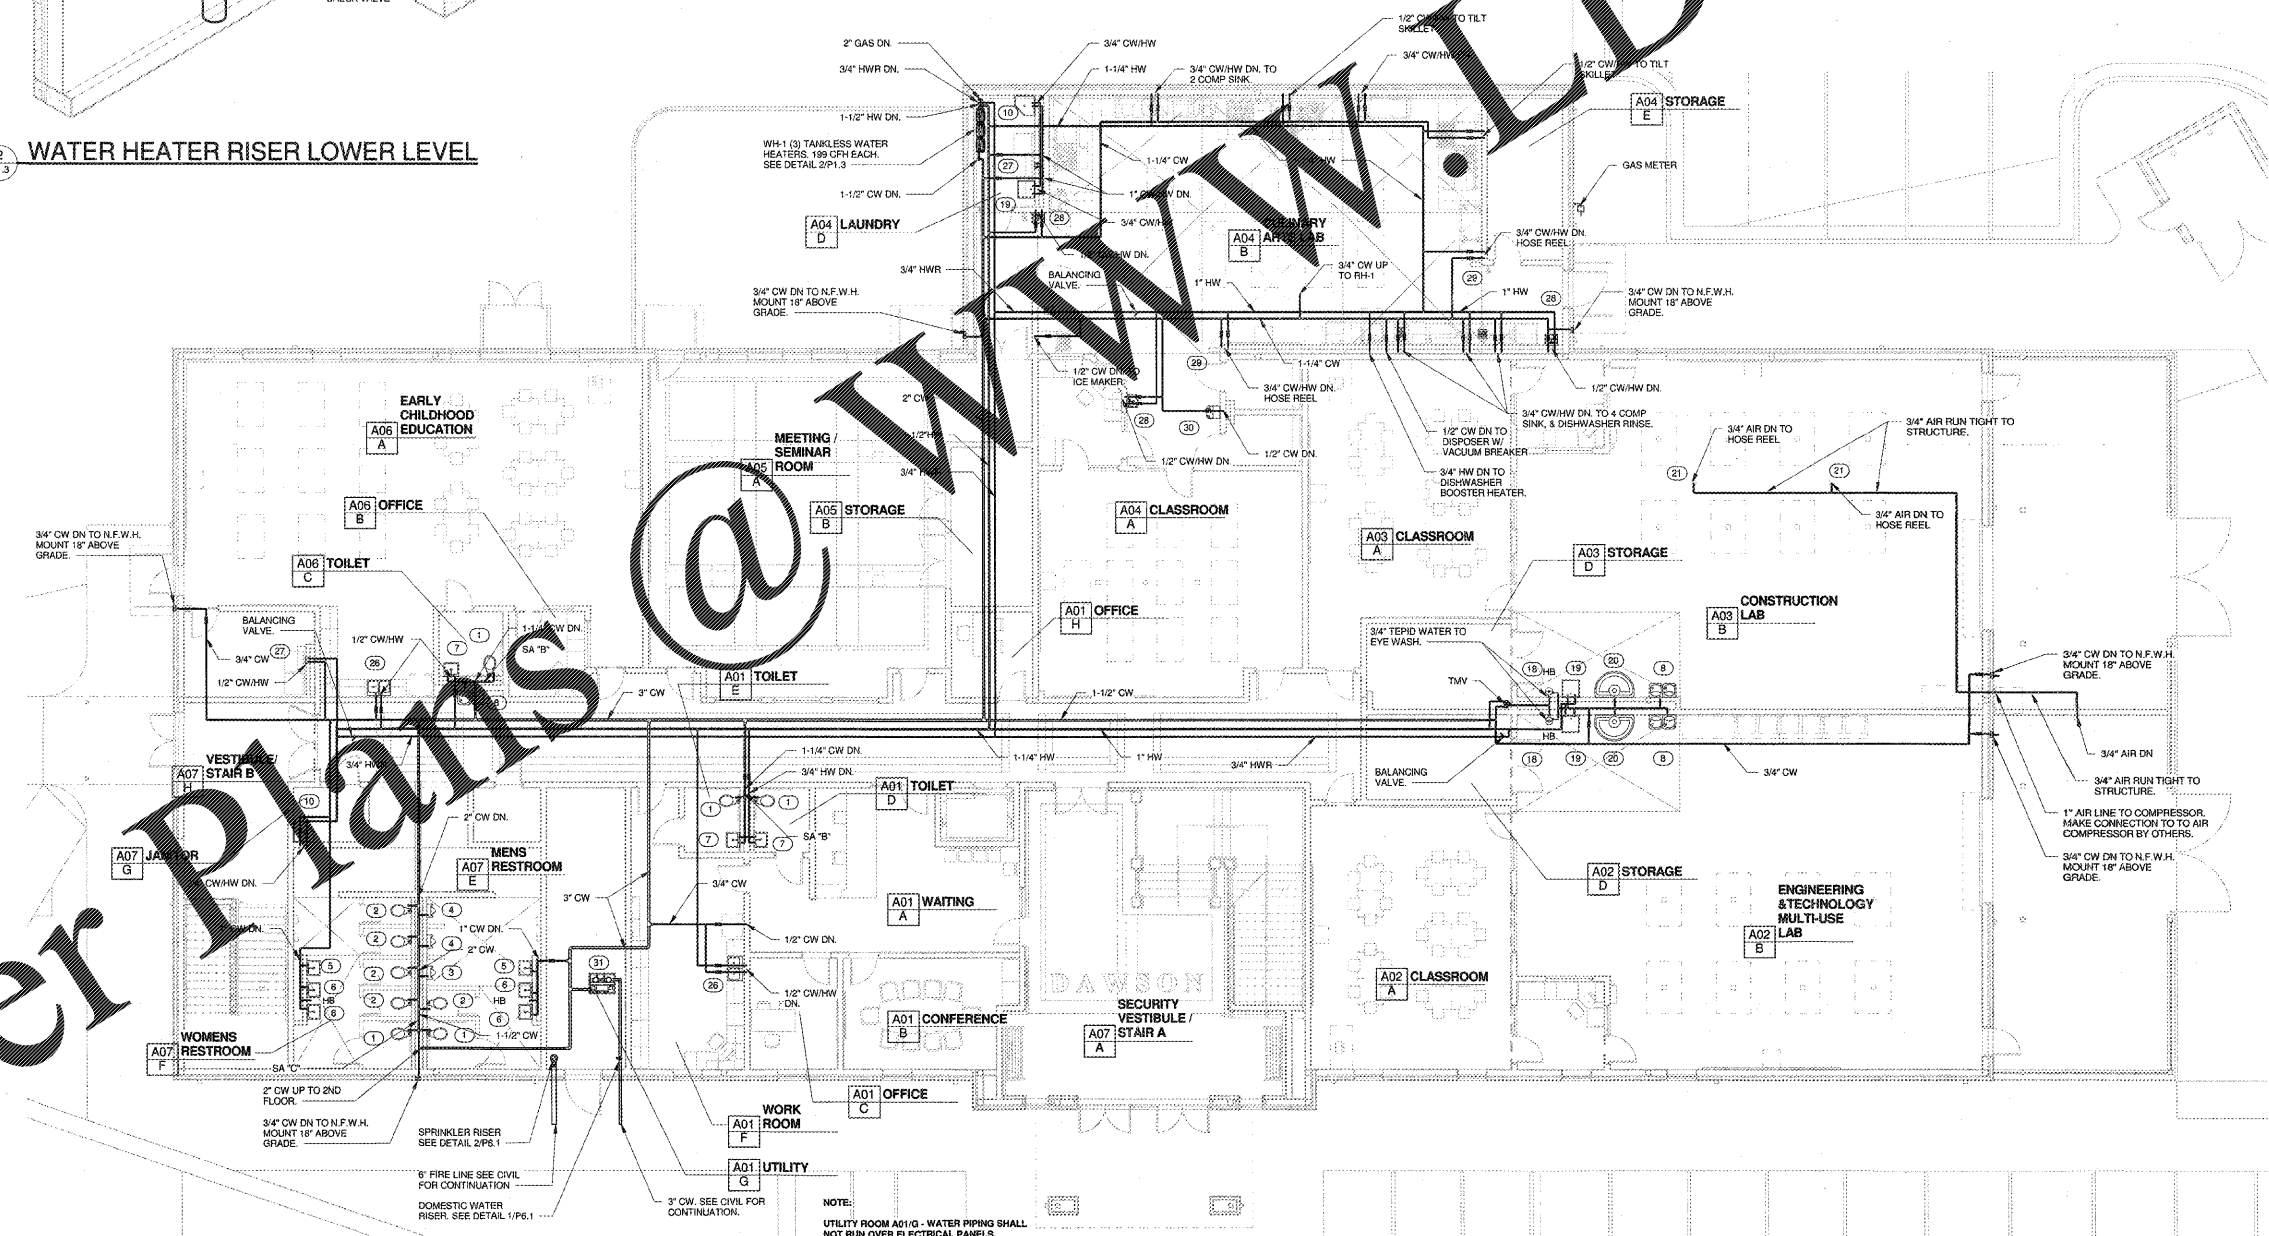

1 WATER FLOOR PLAN - LOWER LEVEL  
1/8" = 1'-0"

**SITE UTILITY NOTE:**  
PLUMBING CONTRACTOR SHALL COORDINATE THE LOCATION OF ALL PIPING FOR CONNECTION TO THE APPROPRIATE UTILITY AS SHOWN ON THE UTILITY PLAN. THIS CONTRACTOR SHALL MAKE FINAL CONNECTION TO THE RECEIVING UTILITY.

Order Plans @

**ROBERTSON DIA ROOF ARCHITECTS ENGINEERS**  
3460 Preston Ridge Road, Suite 275, Marietta, GA 30065  
770.674.2600 / www.rdia.com

**GEORGIA ARCHITECTS ENGINEERS**  
No. 35292  
Professional Seal  
MIR N. DEAN

(Facility No. 642-0198)

**Dawson County College and Career Academy**  
Dawsonville, Georgia  
FOR  
**Dawson County Schools**  
Overall Square Footage = 35,800 SF  
PLS = 102

REVISION

DATE: 05-07-2018  
PROJECT NUMBER: 17-303  
SHEET NUMBER: P1.3