

KITCHEN EQUIPMENT SCHEDULE										
EQUIPMENT MARK	DESCRIPTION	VOLTAGE	PHASES	HP	KW	AMPS	BRANCH CIRCUIT	CONNECTOR	AFF	NOTE
1	CONVECTION OVEN GAS	120	1			6	2#12-#120-3/4"	RECEPTACLE	4'-0"	
9	KETTLE ELECTRIC COUNTERTOP	208	1	12			2#4-#120-1/4"	100S/NFAX	4'-0"	
13	TILTING SKILLET BRASING PAN COUNTERTOP GAS	120	1			2	2#12-#120-3/4"	RECEPTACLE	4'-0"	
17	COMBI OVEN ELECTRIC	208	3	11.1			3#8-#120-3/4"	60S/NFAX	4'-0"	
18	DOUBLE REACH-IN REFRIGERATOR	120	1		9.6		2#12-#120-3/4"	RECEPTACLE	1'-6"	
19	SINGLE REACH-IN FREEZER	120	1		3.7		2#12-#120-3/4"	RECEPTACLE	1'-6"	
21	BEVERAGE STATION	120	1				2#12-#120-3/4"	RECEPTACLE	4'-4"	
K3	SINK HEATER	208	3			8	3#8-#120-3/4"	60S/NFAX	1'-6"	
K6	DISHMACHINE	208	3		24.9		3#10-#120-3/4"	30S/NFAX	1'-6"	
K6A	BOOSTER HEATER	208	3	30.0			3#1-#60-1 1/2"	200S/NFAX	1'-6"	
K13	DISPOSAL	208	3	2			2#12-#120-3/4"	30S/NFAX	1'-6"	
K25	RICE MACHINE	208	1		11.1		2#12-#120-3/4"	30S/NFAX	7'-0"	
R1	RELOCATED MIXER	208	3	1 1/2		6.6	2#12-#120-3/4"	30S/NFAX	4'-0"	
R2	RELOCATED FOOD PROCESSOR	208	3	5		7	2#12-#120-3/4"	30S/NFAX	4'-0"	
R3	RELOCATED PASS-THRU REFRIGERATOR	120	1				2#12-#120-3/4"	RECEPTACLE	4'-0"	
R4	RELOCATED COUNTERTOP FOOD PROCESSOR	120	1				2#12-#120-3/4"	RECEPTACLE	1	

KITCHEN EQUIPMENT SCHEDULE NOTES

1. MOUNT HORIZONTALLY WITH BOTTOM OF BOX (SINGLE-GANG PLASTER RING OPENING) AT 3'-10" AFF.



PROJECT SPECIAL NOTES

1. NO CONDUIT SHALL BE INSTALLED IN ANY FLOOR SLAB THAT IS NOT ON GRADE. NO EXCEPTIONS. CONDUIT SHALL BE INSTALLED OVER-HEAD OR ROUTED THROUGH THE SLAB AND INSTALLED ABOVE THE CEILING OF THE LEVEL BELOW.

POWER PLAN NOTES

1. CONTRACTOR SHALL BE RESPONSIBLE FOR DETERMINING NUMBER OF CONDUCTORS IN BRANCH CIRCUITS AND SWITCH LEGS.

2. SEE SHEET E2.01 FOR POWER PLAN KEYNOTES.

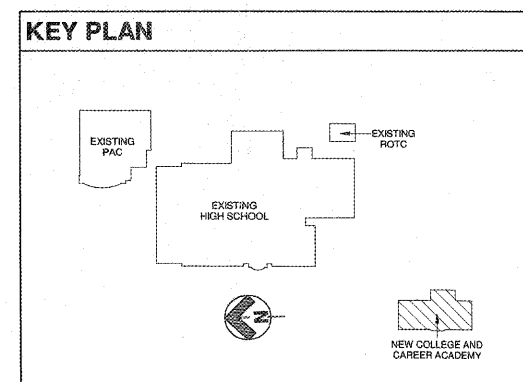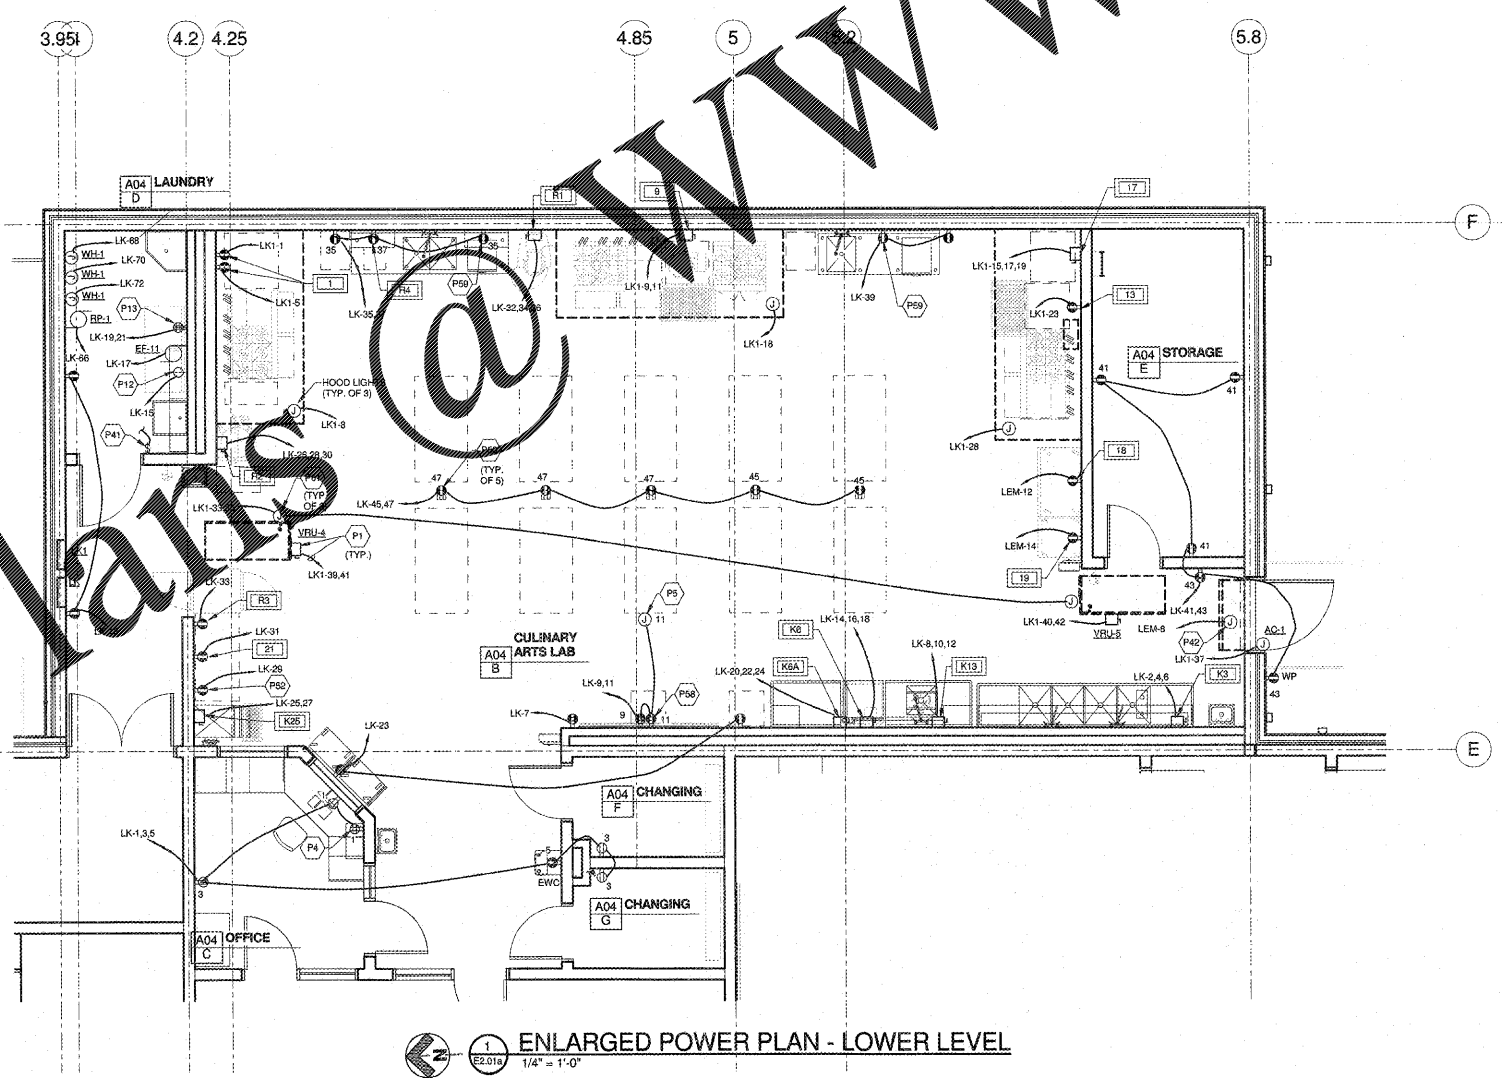

1
E2.01
1/4" = 1'-0"
ENLARGED POWER PLAN - LOWER LEVEL

ROBERTSON ROOF ARCHITECTS ENGINEERS
 3468 Preston Ridge
 Suite 275
 Marietta, GA 30005
 770.474.2800 / www.rre.com



(Facility No. 642-0198)
Dawson County College and Career Academy
 Dawsonville, Georgia
Dawson County Schools
 Overall Squarefootage = 35,800 SF
 FTE = 1625
 Us = 74 (Existing) + 11 (New) = 85 Us

REVISIONS

ENLARGED POWER PLAN - LOWER LEVEL
 DATE: 04-24-2018
 PROJECT NUMBER: 17-303
 SHEET NUMBER: E2.01a

Order Plans @ www.LDILine.com