



NOTE:
REFER TO OVERALL FLOOR PLAN FOR
RESTROOM ORIENTATION AND LAYOUT OF
ADJACENT WALLS.


1 ENLARGED PLAN
A4.1 SCALE: 1/4" = 1'-0"

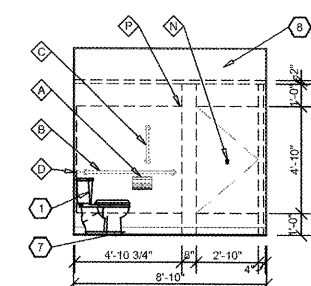


2 ELEVATION
A4.1 SCALE: 1/4" = 1'-0"

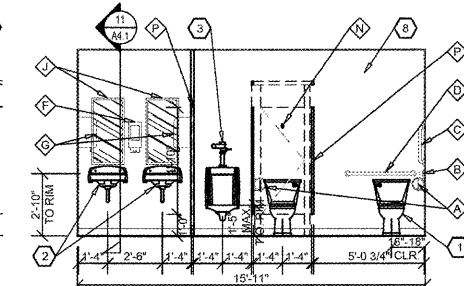


3 ELEVATION
A4.1 SCALE: 1/4" = 1'-0"

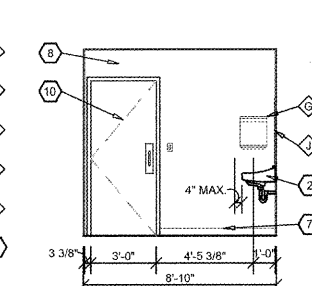


4 ELEVATION
A4.1 SCALE: 1/4" = 1'-0"

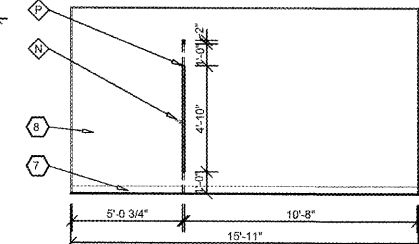


5 ELEVATION
A4.1 SCALE: 1/4" = 1'-0"

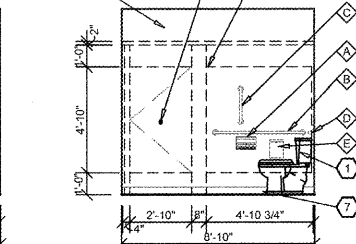


6 ELEVATION
A4.1 SCALE: 1/4" = 1'-0"

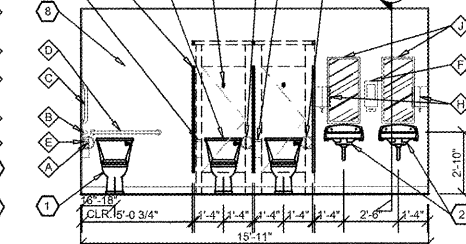


7 ELEVATION
A4.1 SCALE: 1/4" = 1'-0"

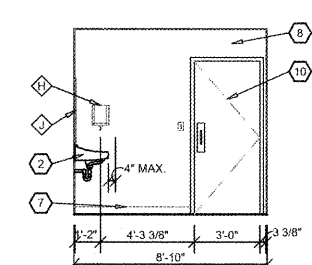


8 ELEVATION
A4.1 SCALE: 1/4" = 1'-0"

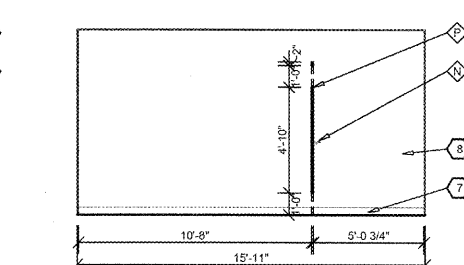


9 ELEVATION
A4.1 SCALE: 1/4" = 1'-0"

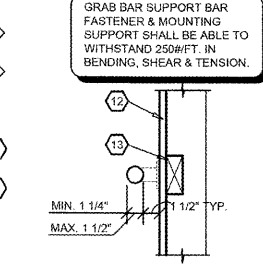


10 ELEVATION
A4.1 SCALE: 1/2" = 1'-0"

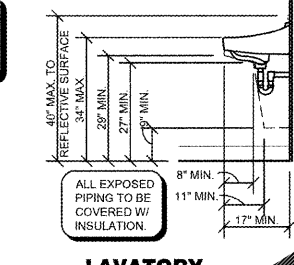


11 LAVATORY CLEARANCES
A4.1 SCALE: 1/2" = 1'-0"

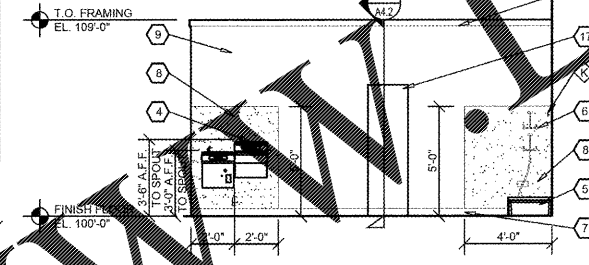


12 ELEVATION
A4.1 SCALE: 1/4"

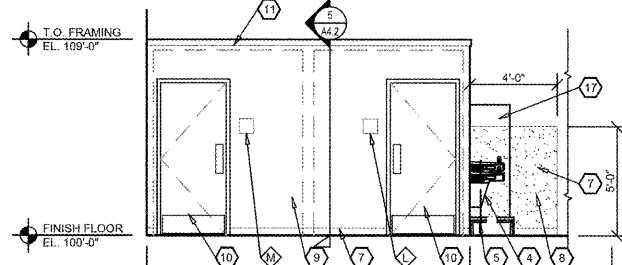

13 ELEVATION
A4.1 SCALE: 1/4" = 1'-0"

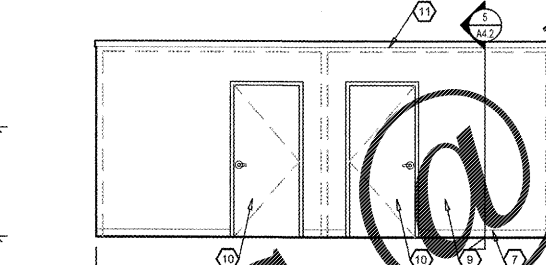

14 ELEVATION
A4.1 SCALE: 1/4" = 1'-0"

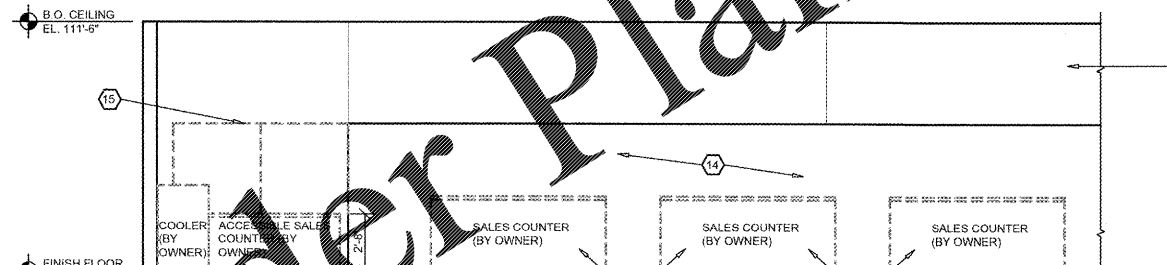

15 ELEVATION
A4.1 SCALE: 1/4"

GENERAL NOTES

- A REFER TO PROJECT MANUAL FOR ADDITIONAL REQUIREMENTS.
- B LAYOUT DIMENSIONS OF PLUMBING FIXTURES AND ACCESSORIES TO FACE OF GYPSUM BOARD OR CENTER LINE OF FIXTURE. LAYOUT DIMENSIONS OF WALLS AND CEILINGS TO ROUGH FACE OF FRAMING, MASONRY, OR CENTER LINE OF STRUCTURE. ALL GYPSUM BOARD 5/8" THICK UNLESS OTHERWISE INDICATED AND DIMENSIONS NOT SHOWN FOR CLARITY.
- C REFER TO PLUMBING DRAWINGS FOR FIXTURE TYPES AND ADDITIONAL REQUIREMENTS. PROVIDE ADDITIONAL COLD FORM METAL FRAMING OR FIRE RATED BLOCKING AS REQUIRED FOR PROPER SUPPORT.
- D REFER TO INTERIOR FINISH SCHEDULES FOR MATERIAL FINISH TYPES AND LOCATIONS.
- E ALL EXPOSED PIPING BELOW SINKS TO BE COVERED WITH INSULATION.
- F LAYOUT DIMENSIONS FOR WALL TOILET PARTITION BASED UPON 1" MINIMUM THICKNESS. DIMENSION NOT SHOWN FOR CLARITY. TOILET PARTITIONS SHOWN AS HIDDEN LINES IN ELEVATION FOR CLARITY OF COMPARTMENT ACCESSOR LOCATIONS. PROVIDE FLOOR TO CEILING 1" SQUARE TIE BEHIND PARTITION SUPPORT POST AT WALL PARTITION EXPOSED END.

KEY NOTES

- 3 WALL HUNG URINAL. MOUNT RIM 1'-5" MAXIMUM ABOVE FINISH FLOOR.
- 4 HIGH / LOW DRINKING FOUNTAIN WITH CANE GUARD.
- 5 FLOOR MOUNTED JANITOR SINK.
- 6 EYE WASH STATION. INSTALL WITH TOP AT ABOVE FINISH FLOOR.
- 7 BASE, REFER TO FINISH SCHEDULE.
- 8 SANITARY WALL PANEL SYSTEM. REFER TO FINISH SCHEDULE. PROVIDE AN ALUMINUM EDGE MOLDING AROUND PERIMETER OF EACH SUBSTRATE AS REQUIRED.
- 9 PAINT. REFER TO FINISH SCHEDULE.
- 10 DOOR. REFER TO FINISH SCHEDULES.
- 11 WOOD TRIM. PAINT.
- 12 WALL CONSTRUCTION. REFER TO FLOOR PLAN FOR TYPE.
- 13 WARE TREATED 2X WOOD BLOCKING.
- 14 WALL OPENING TO BEYOND. REFER TO FLOOR PLAN.
- 15 OWNER FURNISHED AND INSTALLED FURNISHING, SHELVING, OR FIXTURE. FOR REFERENCE ONLY (N.I.C.)
- 16 OWNER FURNISHED AND INSTALLED ACCESSIBLE CUSTOMER SERVICE COUNTER TO COMPLY WITH ACCESSIBILITY REQUIREMENTS. FOR REFERENCE ONLY (N.I.C.)
- 17 FLOOR MOUNTED WATER HEATER. REFER TO PLUMBING DRAWINGS.
- 18 EXISTING WALL CONSTRUCTION TO REMAIN.

KEY NOTES



- 1 WALL CLOSE ACCESSIBLE FIXTURE HEIGHT TO TOP OF PARTITION TO BE 17" MINIMUM AND 19" MAXIMUM A.F.F.. ACCESSIBLE FIXTURE FLUSH CONTROLS TO BE ON WIDE SIDE OF TOILET.
- 2 WALL HUNG LAVATORY.

ACCESSORY SCHEDULE

MK	DESCRIPTION	MANUFACTURER	SERIES / MODEL	MOUNTING LOCATION	ACCESSORY NOTES
A	TISSUE PAPER DISPENSER	GEORGIA PACIFIC	COMPACT 56783	REFER PLANS, ELEVATIONS, LEGEND	NOTE 2
B	GRAB BAR	BOBRICK	86806 x 48"	REFER PLANS, ELEVATIONS, LEGEND	
C	GRAB BAR	BOBRICK	86806 x 18"	REFER PLANS, ELEVATIONS, LEGEND	
D	GRAB BAR	BOBRICK	86806 x 36"	REFER PLANS, ELEVATIONS, LEGEND	
E	SANITARY NAPKIN RECEPTACLE	BOBRICK	B-270	REFER PLANS, ELEVATIONS, LEGEND	WOMEN'S RESTROOM ONLY
F	SOAP DISPENSER	GOJO	PRO 2000	REFER PLANS, ELEVATIONS, LEGEND	NOTE 2
G	PAPER TOWEL DISPENSER (MEN)	GEORGIA PACIFIC	59460	REFER PLANS, ELEVATIONS, LEGEND	NOTE 2
H	PAPER TOWEL DISPENSER (WOMEN)	GEORGIA PACIFIC	SOFPULL 52409	REFER PLANS, ELEVATIONS, LEGEND	NOTE 2
I	MIRROR	BOBRICK	B-165-1836 18" W X 36" H	REFER PLANS, ELEVATIONS, LEGEND	
J	MOP HANGER	REFER TO PLUMBING DRAWINGS	REFER TO PLUMBING DRAWINGS	60" A.F.F. TO CENTER	REFER TO PLUMBING DRAWINGS
K	DOOR SIGN (MEN)	ROCKWOOD	BF687	REFER PLANS, ELEVATIONS, LEGEND	WHITE TEXT ON BLACK BACKGROUND
L	DOOR SIGN (WOMEN)	ROCKWOOD	BF688	REFER PLANS, ELEVATIONS, LEGEND	WHITE TEXT ON BLACK BACKGROUND
M	ROB HOOK / WALL BUMPER	BOBRICK	B-212	40" A.F.F. TO HOOK AT ACCESSIBLE STALLS	80" A.F.F. TO HOOK AT NON ACCESS. STALLS
N	TOILET PARTITION SYSTEM	ACCURATE	FLOOR ANCHORED / OVERHEAD BRACED	REFER PLANS, ELEVATIONS	STAINLESS STEEL WITH #4 FINISH

ACCESSORY GENERAL NOTES:
1. CONTRACTOR TO PROVIDE FIRE TREATED WOOD BLOCKING FOR INSTALLATION OF TOILET ACCESSORIES, INCLUDING OWNER FURNISHED AND CONTRACTOR INSTALLED ACCESSORIES. COORDINATE REQUIREMENTS WITH OWNER.
2. ACCESSORY OWNER FURNISHED AND CONTRACTOR INSTALLED. REFER TO SCOPE OF WORK SCHEDULE FOR ADDITIONAL REQUIREMENTS.

ACCESSORY MOUNTING LEGEND

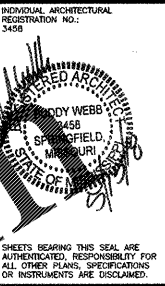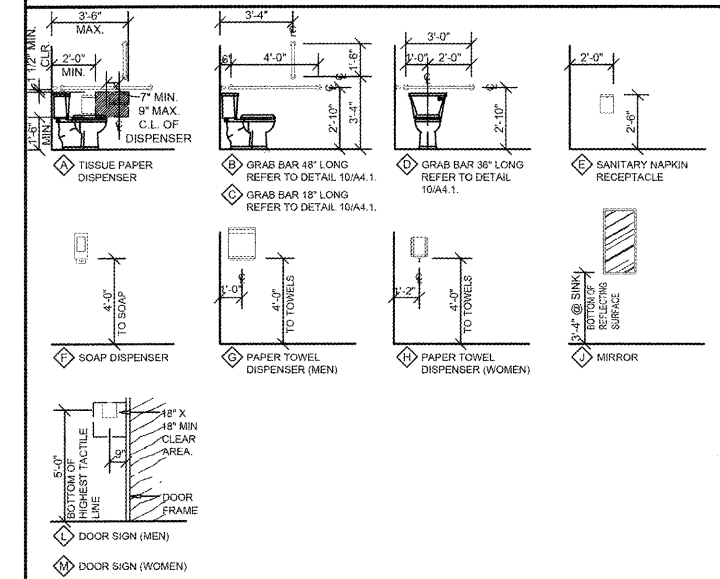

Buddy Webb, N. Carb, AIA
Architect - Consultant
3057 EAST CAIRO
SPRINGFIELD, MISSOURI 65802
(417) 877-1385 TELEPHONE
(417) 877-9736 FAX

PROJECT: (ADDITION)
O'REILLY AUTO PARTS STORE
2730 HIGHWAY 80 EAST
PEARL, MISSISSIPPI

Buddy Webb, N. Carb, AIA
Architect - Consultant
3057 EAST CAIRO
SPRINGFIELD, MISSOURI 65802
(417) 877-1385 TELEPHONE
(417) 877-9736 FAX

DRAWN BY: **EW** CHECKED BY: **RV**
DATE: **04/26/18**
REVISION:

PROJECT NUMBER:
PEA-0994

SHEET NUMBER
A4.1

Order Plans

WWW.DRAWINGDOCS.COM

INDIVIDUAL ARCHITECTURAL REGISTRATION NO. 3458
SHEETS BEARING THIS SEAL ARE AUTHORIZED. RESPONSIBILITY FOR ALL OTHER PLANS, SPECIFICATIONS OR INSTRUMENTS ARE DISCLAIMED.
REPRODUCTION PROHIBITED WITHOUT THE EXPRESSED WRITTEN CONSENT OF THE DESIGN PROFESSIONAL.
DESIGNS, DRAWINGS AND SPECIFICATIONS ARE INSTRUMENTS OF SERVICE AND ARE THE PROPERTY OF THE DESIGN PROFESSIONAL.