


Order Plans @ WWW.EDLine.com

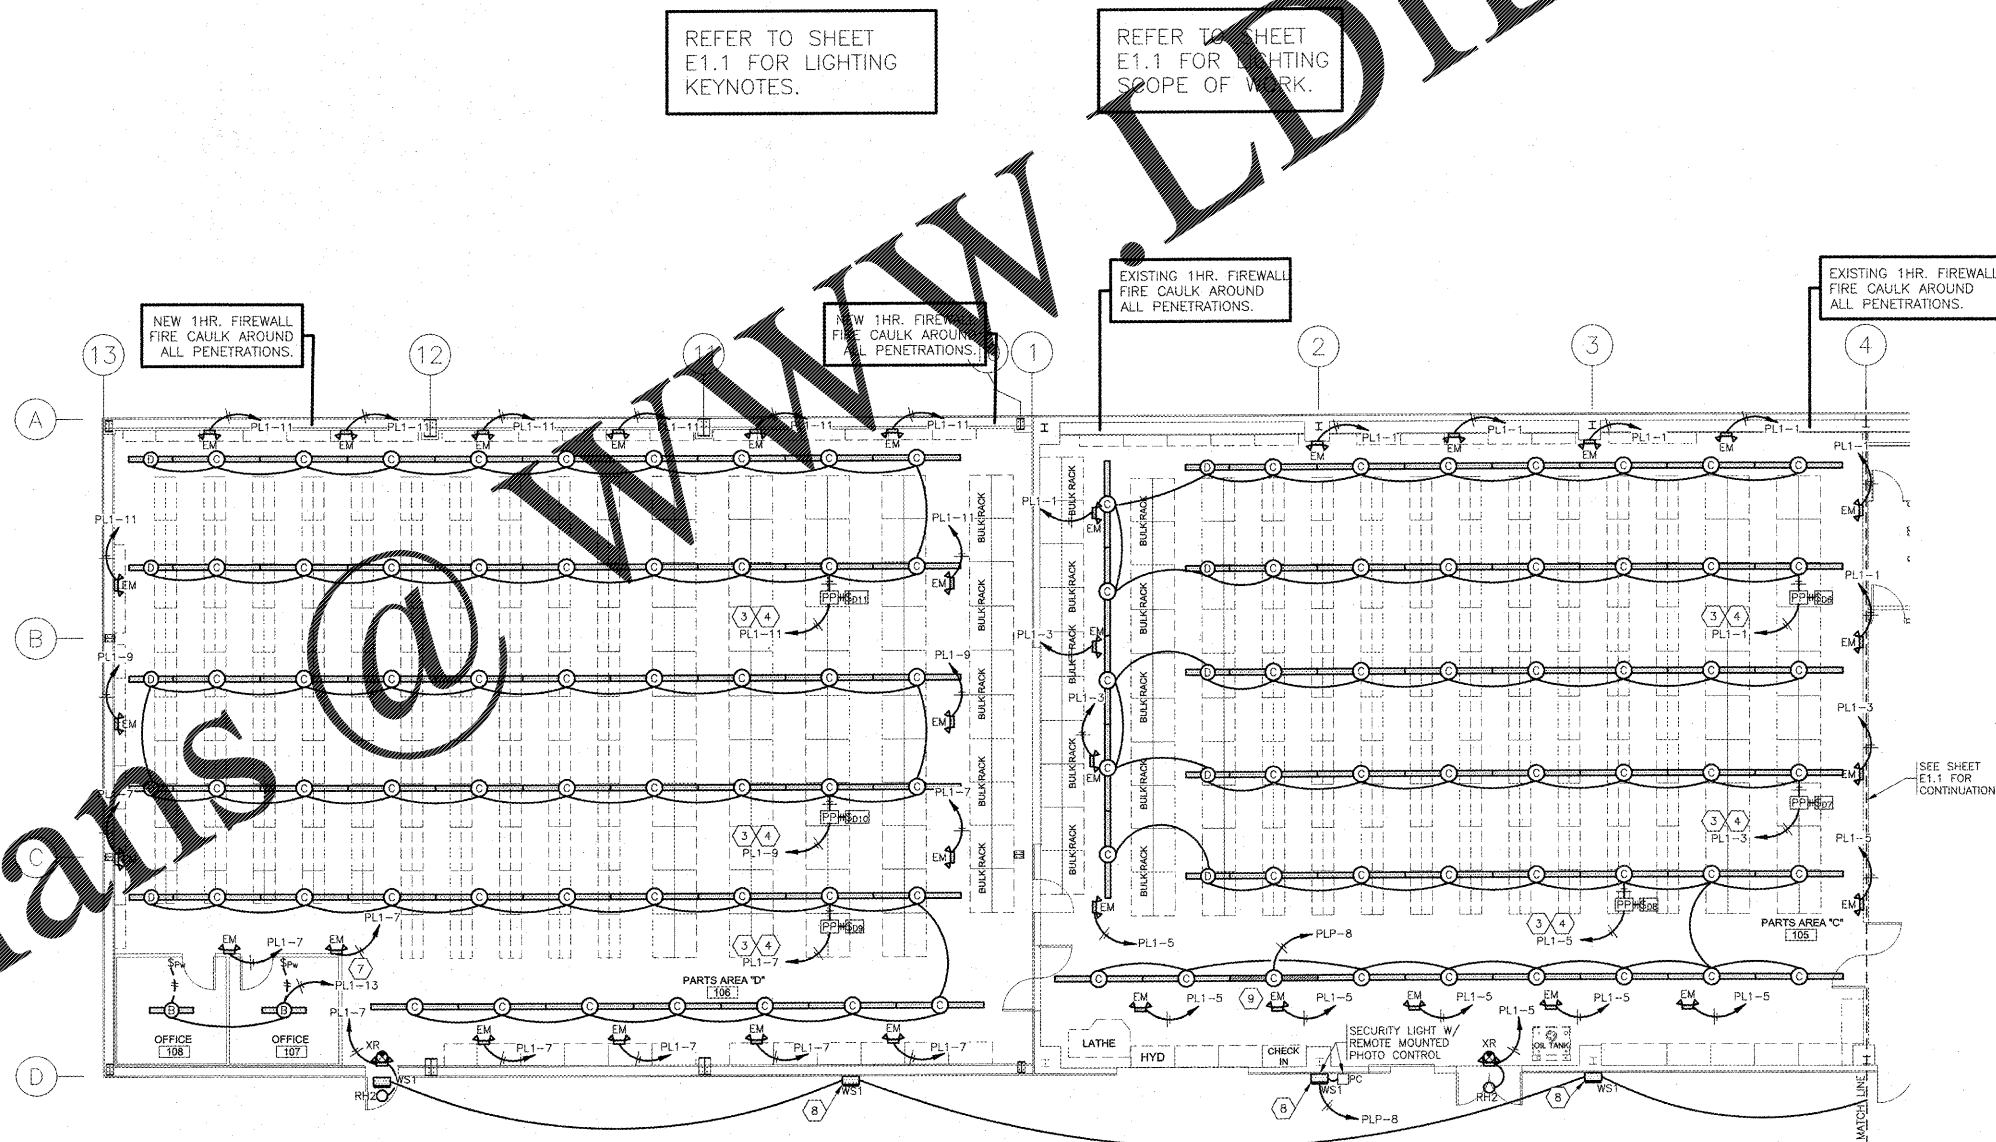

**PARTIAL LIGHTING PLAN**

SCALE: 1/8" = 1'-0"



ALL SHEETS BEARING THIS SEAL ARE AUTHENTICATED. RESPONSIBILITY FOR ALL OTHER PLANS, SPECIFICATIONS OR INSTRUMENTS ARE DISCLAIMED.

**O'Reilly AUTO PARTS**  
 CORPORATE OFFICES  
 233 SOUTH PATTERSON  
 SPRINGFIELD, MISSOURI 65802  
 (417) 862-2874 TELEPHONE

**PROJECT:** NEW O'REILLY AUTO PARTS STORE  
 2730 HIGHWAY 80 EAST  
 PEARL, MISSISSIPPI  
**LIGHTING PLAN**

3885 S. JEFFERSON AVE.  
 SPRINGFIELD, MO 65807  
 P: 417-882-2200  
 WWW.SGEEENGINEERS.COM



DRAWN BY: RM  
 CHECKED BY: NEG  
 DATE: 05/11/18  
 REVISION:

PROJECT NUMBER:  
**PEA-0994**

SHEET NUMBER  
**E1.2**

© COPYRIGHT 2018-2019 - DESIGNS, DRAWINGS AND SPECIFICATIONS ARE INSTRUMENTS OF SERVICE AND ARE THE PROPERTY OF THE DESIGN PROFESSIONAL. REPRODUCTION PROHIBITED WITHOUT THE EXPRESSED WRITTEN CONSENT OF THE DESIGN PROFESSIONAL.