


Pascal Aughtry & Associates, PC

405.463.3494  
Fax: 405.463.3493  
937 East Britton Road  
Oklahoma City, OK 73114  
pascalarc.com



A NEW TRAVEL STOP  
STORE NO. 735  
CALHOUN, GA

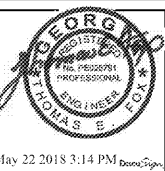

Revisions:	
No.	Date

Project No.: LVS - 18735  
Date: 05-22-18  
Sheet No.:

YP1.1


OF:

**PLUMBING GENERAL NOTES:**

1. ALL PLUMBING WORK SHALL BE PERFORMED IN STRICT ACCORDANCE WITH THE BASE BUILDING SPECIFICATION AND WITH THE LATEST EDITION OF THE PREVAILING STATE MECHANICAL PLUMBING AND BUILDING CODES AS WELL AS ALL REGULATIONS THAT MAY APPLY. IN CASE OF CONFLICT BETWEEN THE CONTRACT DOCUMENTS AND A GOVERNING CODE OR ORDINANCE THE MORE STRINGENT STANDARD SHALL APPLY.
2. INSTALL ALL REQUIRED CLEANOUTS TO CLEAR EQUIPMENT AND FIXTURES.
3. SANITARY AND VENT PIPING SHALL BE SCHEDULE 40 PVC WITH INSTALLATION IN ACCORDANCE WITH ASTM D-232.1; ALL FITTINGS SHALL BE APPROVED SANITARY TYPE.
4. SANITARY AND VENT PIPING IN THE OFFICE RETURN TO PLENUM SHALL BE HUBLESS CAST IRON.
5. ALL FIXTURES ARE PROVIDED WITH STANDARD TRAP AND CLEANOUT (SHOWN).
6. ALL WORK SHALL BE PROPERLY TESTED, BALANCED, CLEANED AND DISINFECTED. PROVIDE A ONE YEAR WARRANTY FROM DATE OF FINAL INSPECTION ON ALL PARTS AND LABOR.
7. ALL WASTE PIPING SMALLER THAN 3" SHALL BE SLOPED @ 1/4 PER FT. PIPING LARGER THAN 3" SHALL BE SLOPED @ 1/8 PER FT.
8. REFER PLUMBING FIXTURE SCHEDULE ON SHEET YP4.1 FOR FIXTURE SPECIFICATIONS.
9. UNDERFLOOR PLUMBING IS SHOWN SCHEMATICALLY FOR VIEWING PURPOSES ONLY. DURING INSTALLATION FIELD MODIFICATIONS TO FITTING MAY BE REQUIRED.
10. TERMINATE PLUMBING VENTS AT A MINIMUM OF 10' FROM ALL AIR HANDLING EQUIPMENT INTAKE VENTS.
11. CONDENSATE PIPING SHALL BE TYPE "L" HARD DRAWN SEAMLESS COPPER TUBE.
12. PROVIDE ASSE 1072 BARRIER-TYPE TRAP SEAL PROTECTION FOR ALL FLOOR DRAINS AND FLOOR SINKS EQUIVALENT TO SURE SEAL.

**⊗ SHEET KEYNOTES**

1. PLUMBER TO INSTALL PVC AIR DUCT IN ACCORDANCE WITH IMC 603.8; COORDINATE WITH MECHANICAL CONTRACTOR.

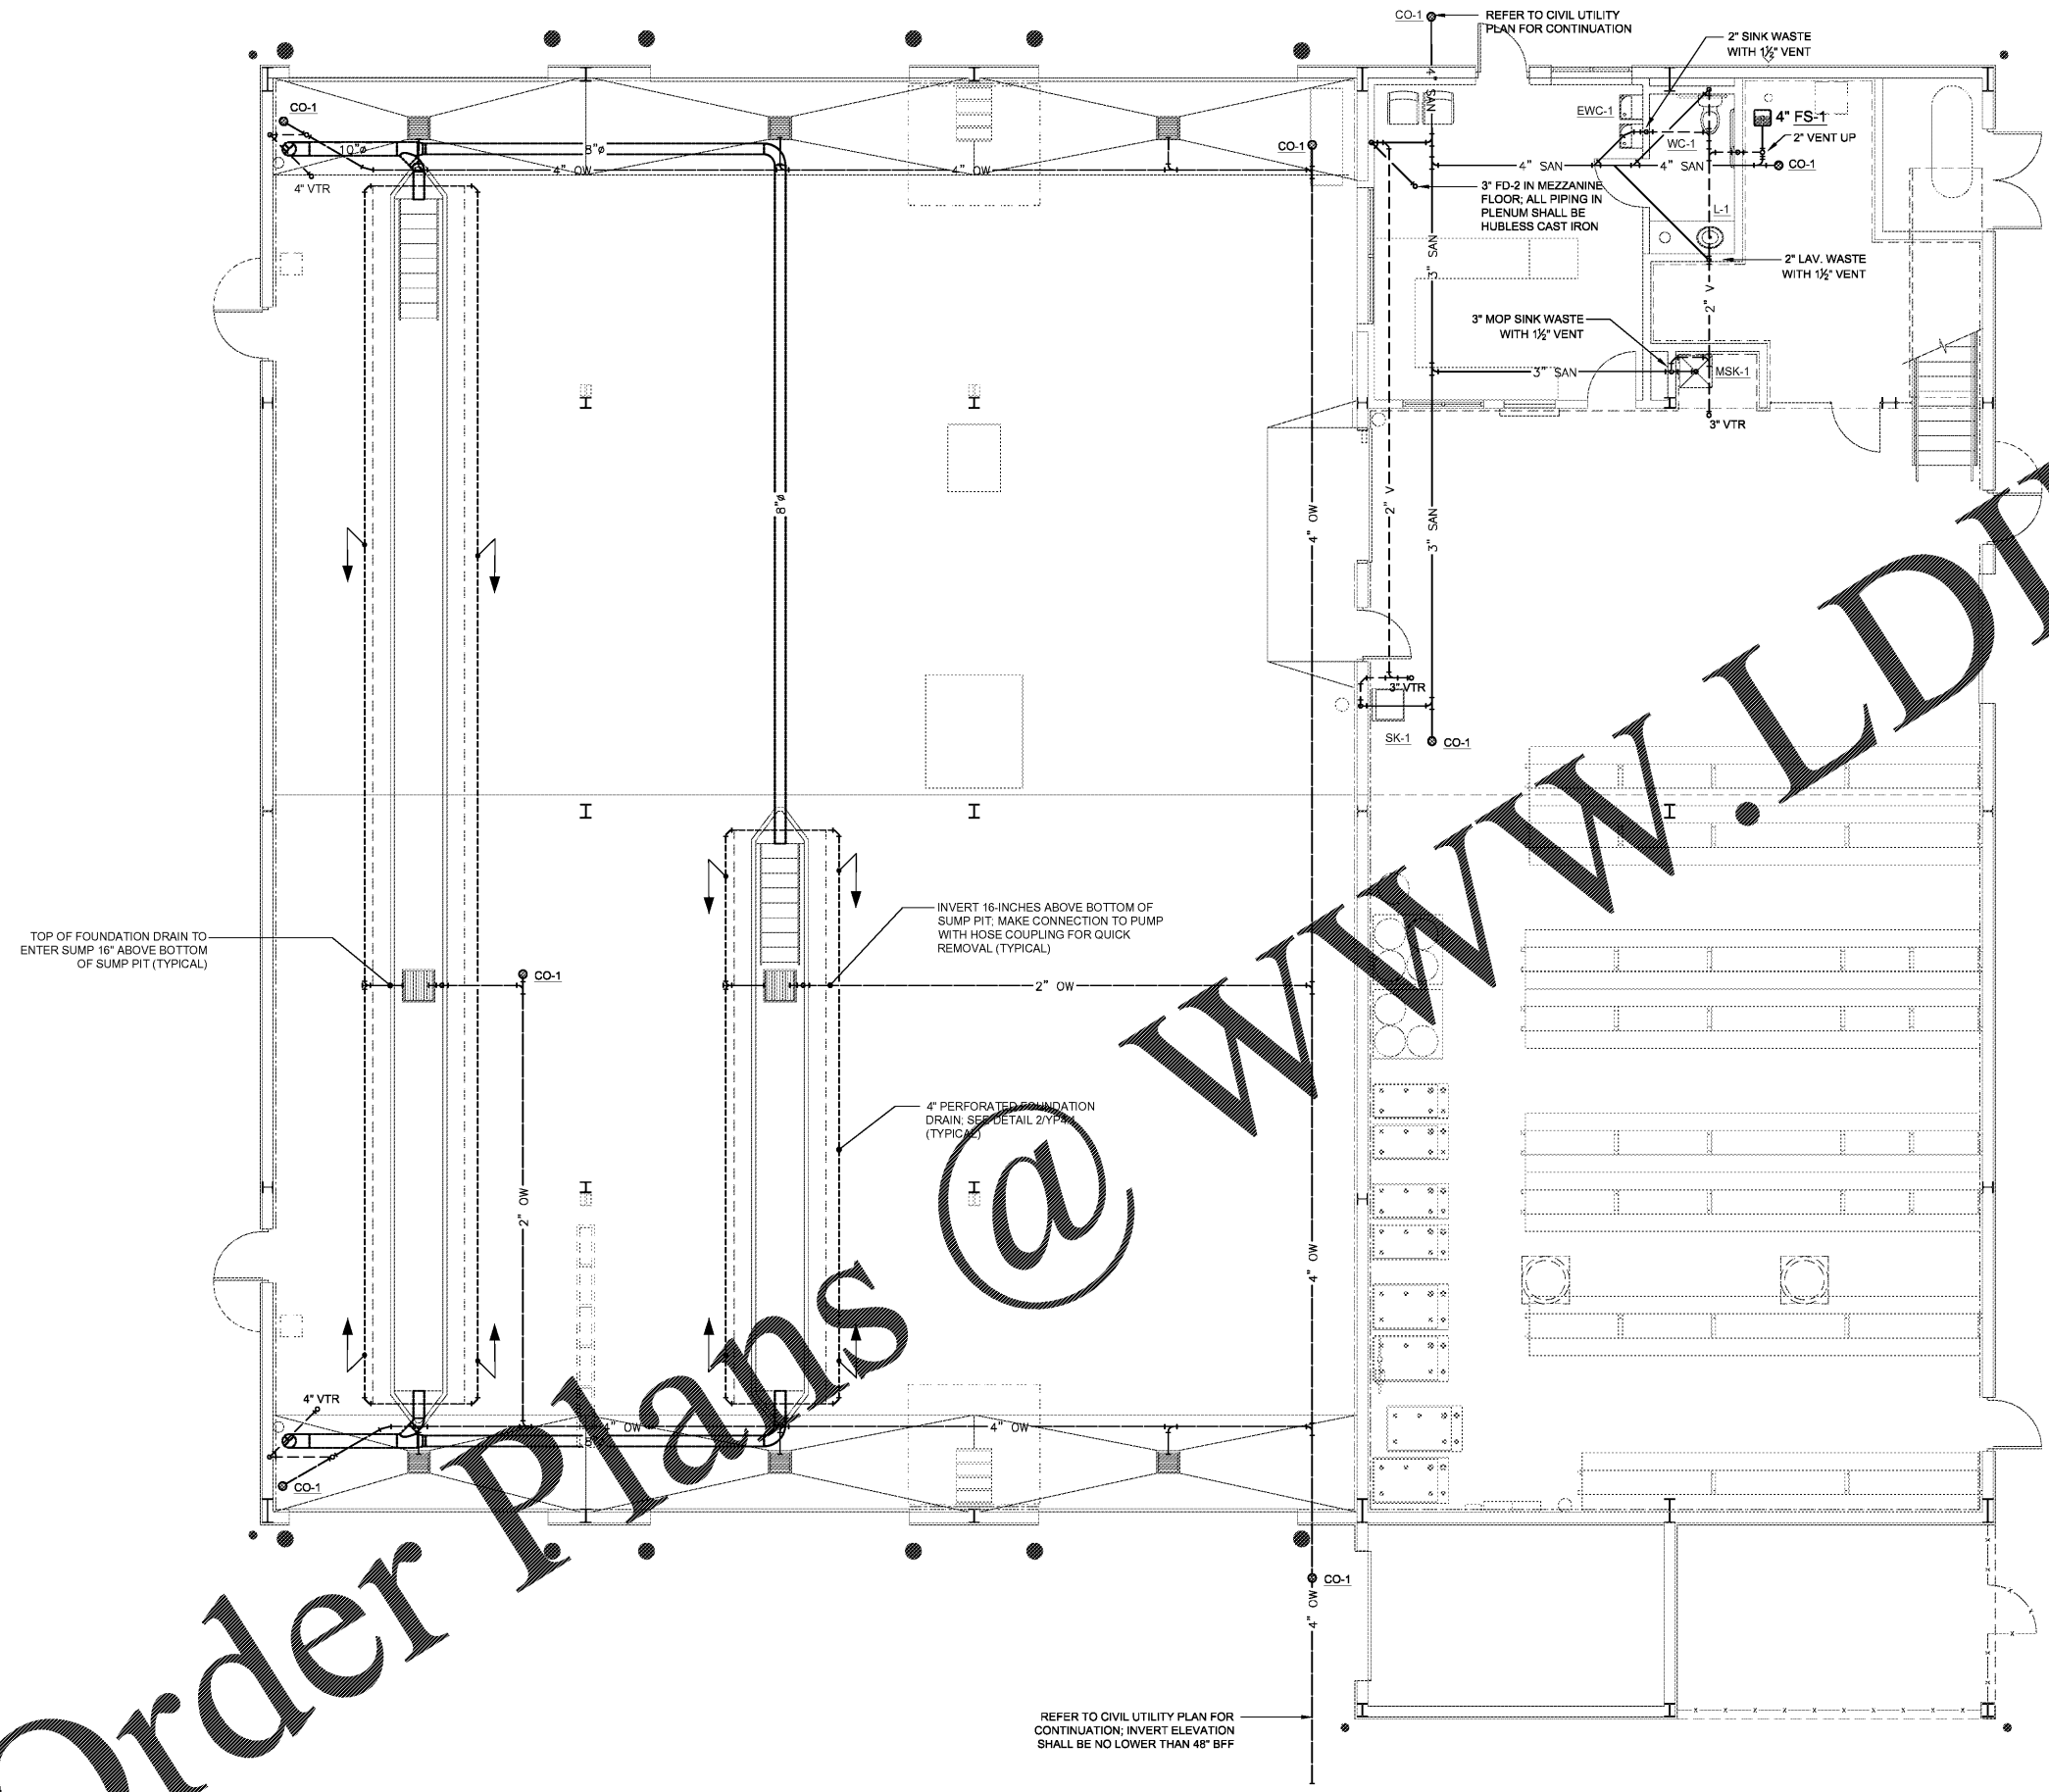

Order Plans @ WWW.LDILLINE.COM

