


ELECTRICAL GENERAL NOTES

1. E.C. SHALL KEEP ALL CONDUIT AND J-BOXES FOR BRANCH CIRCUIT RUNS BELOW 24" AFF WHERE POSSIBLE.
2. EMERGENCY BATTERY LIGHTING UNITS AND EXIT SIGNS SHALL BE CONNECTED TO THE UN-SWITCHED HOT LEG OF THE BRANCH CIRCUIT.

(X) SHEET KEYNOTES

1. INSTALL RIGID CONDUIT TO FIXTURES AS FAR BACK IN NICHE AS POSSIBLE AND ENTER FIXTURES IN KNOCKOUTS ON ENDS. USE SLEEVES THROUGH CONCRETE SUPPORTS FOR CONDUIT BETWEEN FIXTURES.
2. INSTALL SEALOFF ON SURFACE CONDUIT BEFORE IT ENTERS THE CONCRETE SLAB. ALSO INSTALL SEALOFF WHERE CONDUIT EMERGES FROM SLAB AT BUILDING WALL.
3. 4-POLE LIGHTING CONTACTOR IN NEMA 1 BOX MOUNTED WITH BOTTOM AT 8'-0" AFF. CONTROL THE CONTACTOR WITH THE THREE-WAY SWITCH SHOWN. CONTACTOR SHALL CONTROL THE SWITCH LEGS TO ALL TYPE LIGHT FIXTURES.
4. CONNECTION TO EXTERIOR SIGNAGE - SEE ARCHITECTURAL ELEVATIONS FOR LOCATION AND QUANTITY OF SIGNS.

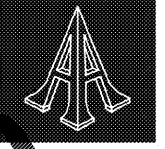

405.463.3434
 Fax 405.463.3493
 937 East Brilton Road
 Oklahoma City, OK 73114
 pascalarch.com

Pascal Aughtry & Associates, PC



A NEW TRAVEL STOP
 STORE NO. 735
 CALHOUN, GA




Revisions:

No.	Date

Project No.: LVS - 18735
 Date: 05-22-18
 Sheet No.:

YE-2.1

OF:

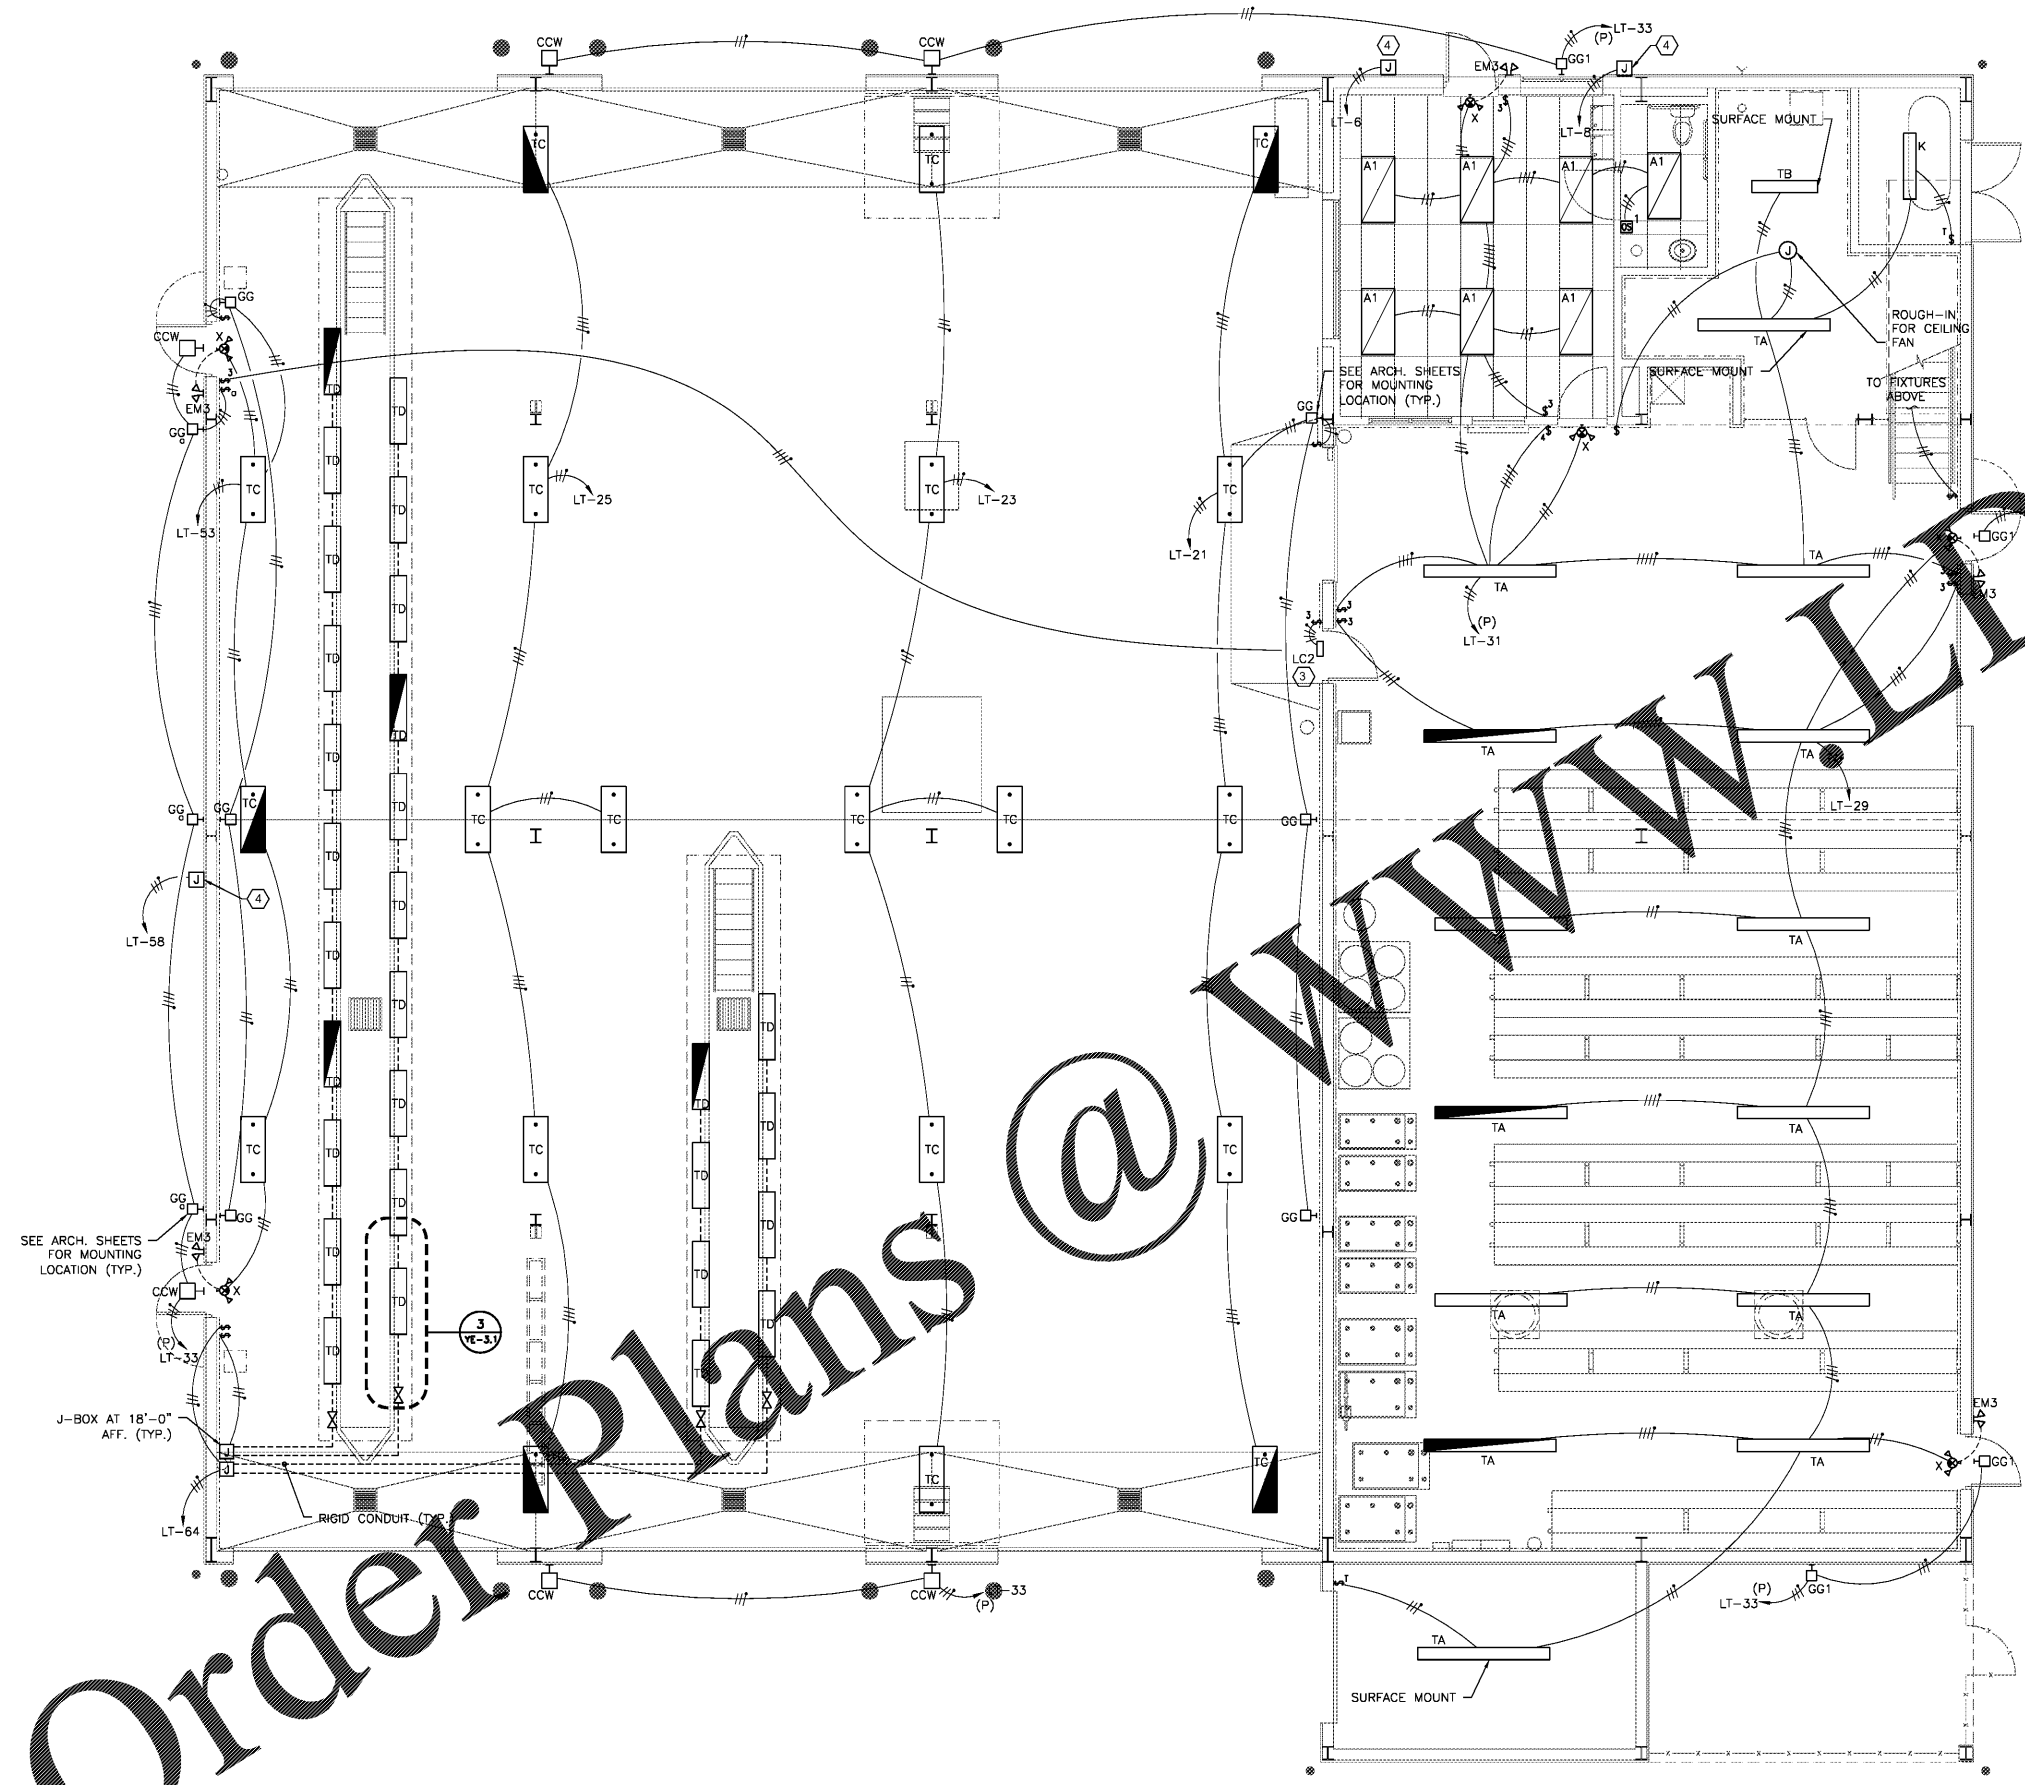

1 FLOOR PLAN - TIRE SHOP - LIGHTING
 3/16" = 1'-0"

Order Plans @

AWWAVELEDLine.com

ELECTRICAL LEGEND	
SYMBOL	DENOTES
	STRIP FIXTURE
	WALL MOUNT FIXTURE - HID
	SINGLE POLE SWITCH AT 4" AFF
	NEMA 5-20R DUPLEX RECEPTACLE
	JUNCTION BOX
	NON-FUSIBLE SAFETY SWITCH (FRAME SIZE / # POLES)
	CIRCUIT HOMERUN - HOT, NEUTRAL & GROUND #12 THHN IN 1/2" EMT CONDUIT UNLESS OTHERWISE NOTED
	TELEPHONE OUTLET

FIRE SYSTEM LEGEND	
SYMBOL	DENOTES
	SPRINKLER ALARM PANEL
	FIRE ALARM CONTROL PANEL

FIRE ALARM SYSTEM DESIGN SHALL BE DONE AS A DESIGN-BUILD SERVICE BY THE CONTRACTOR PER SPEC. SECTION 28 3100