


ELECTRICAL GENERAL NOTES

1. E.C. SHALL KEEP ALL CONDUIT AND J-BOXES FOR BRANCH CIRCUIT RUNS BELOW 24" AFF WHERE POSSIBLE.

(X) SHEET KEYNOTES

1. VERIFY LOCATION OF RECEPTACLE FOR WATER COOLER WITH MECH. CONTRACTOR.
2. LABEL WALL SWITCH WITH "MEZZANINE FAN" ON WALL PLATE. LOCATE NEXT TO EXISTING SWITCHES.
3. (2) 2" INCOMING PHONE & DATA CONDUITS. PROVIDE (9) CAT5 CABLES IN CONDUIT WITH 25' OF SLACK ON EACH END. PROVIDE A PULLSTRING IN THE OTHER CONDUIT. SEE SITE PLAN FOR ROUTING.
4. PROVIDE A SPST TIMING RELAY ABOVE CEILING FOR CONTROL OF EXHAUST FAN. POWER THE RELAY FROM THE SWITCH LEG OF RESTROOM LIGHTS SO THAT LIGHTS WHEN LIGHTS ARE ON AND SHUTS DOWN 15 MINUTES AFTER THE LIGHTS ARE TURNED OFF.
5. PROVIDE A FIRE ALARM SYSTEM FOR THE BUILDING PER SPECIFICATION SECTION 28 3100. AT A MINIMUM, FIRE DETECTION SHALL BE PROVIDED FOR AREAS WITH TIRE STORAGE RACKS.
6. VERIFY LOCATION OF RECEPTACLE FOR WATER COOLER WITH MECH. CONTRACTOR.
7. INSTALL AN EXPLOSION PROOF OF 20A 120V RECEPTACLE WITH TOP AT 16" ABOVE BOTTOM OF PIT. REPLACE PUMP ON SUMP PUMP CONDUIT WITH MATCHING EXPLOSION PROOF CONDUIT. INSTALL SEAL ON CONDUIT.
8. INSTALL SWITCHES ON OTHER DEVICES AS REQUIRED FOR A COMPLETE DOOR OPENER INSTALLATION. MOUNT SWITCH BOX AT 54" AFF WITH CONDUIT TO 10'-0" AFF.
9. INSTALL RECEPTACLE AND TV OUTLET AT 6'-4" AFF (TO TOP OF BOX).
10. COORDINATE FAN CONTROL REQUIREMENTS WITH FAN SUPPLIER.
11. CONNECT TO POWER OPERATED ROLL DOWN FIRE DOOR. DOOR SHALL INTERLOCK WITH FIRE ALARM SYSTEM. COORDINATE REQUIREMENTS WITH DOOR SUPPLIER AND FIRE ALARM INSTALLER.
12. RECEPTACLE RECESSED IN WALL FOR PAPER TOWEL DISPENSER. USE A ARLINGTON INDUSTRIES RECESSED ELECTRICAL BOX (DVFRIW) TO MOUNT STANDARD RECEPTACLE AND WALLPLATE AT HEIGHT INDICATED. BOX SHALL BE CENTERED ON PAPER TOWEL DISPENSER. SEE A-18/A FOR HORIZONTAL ROUGH-IN DIMENSIONS.

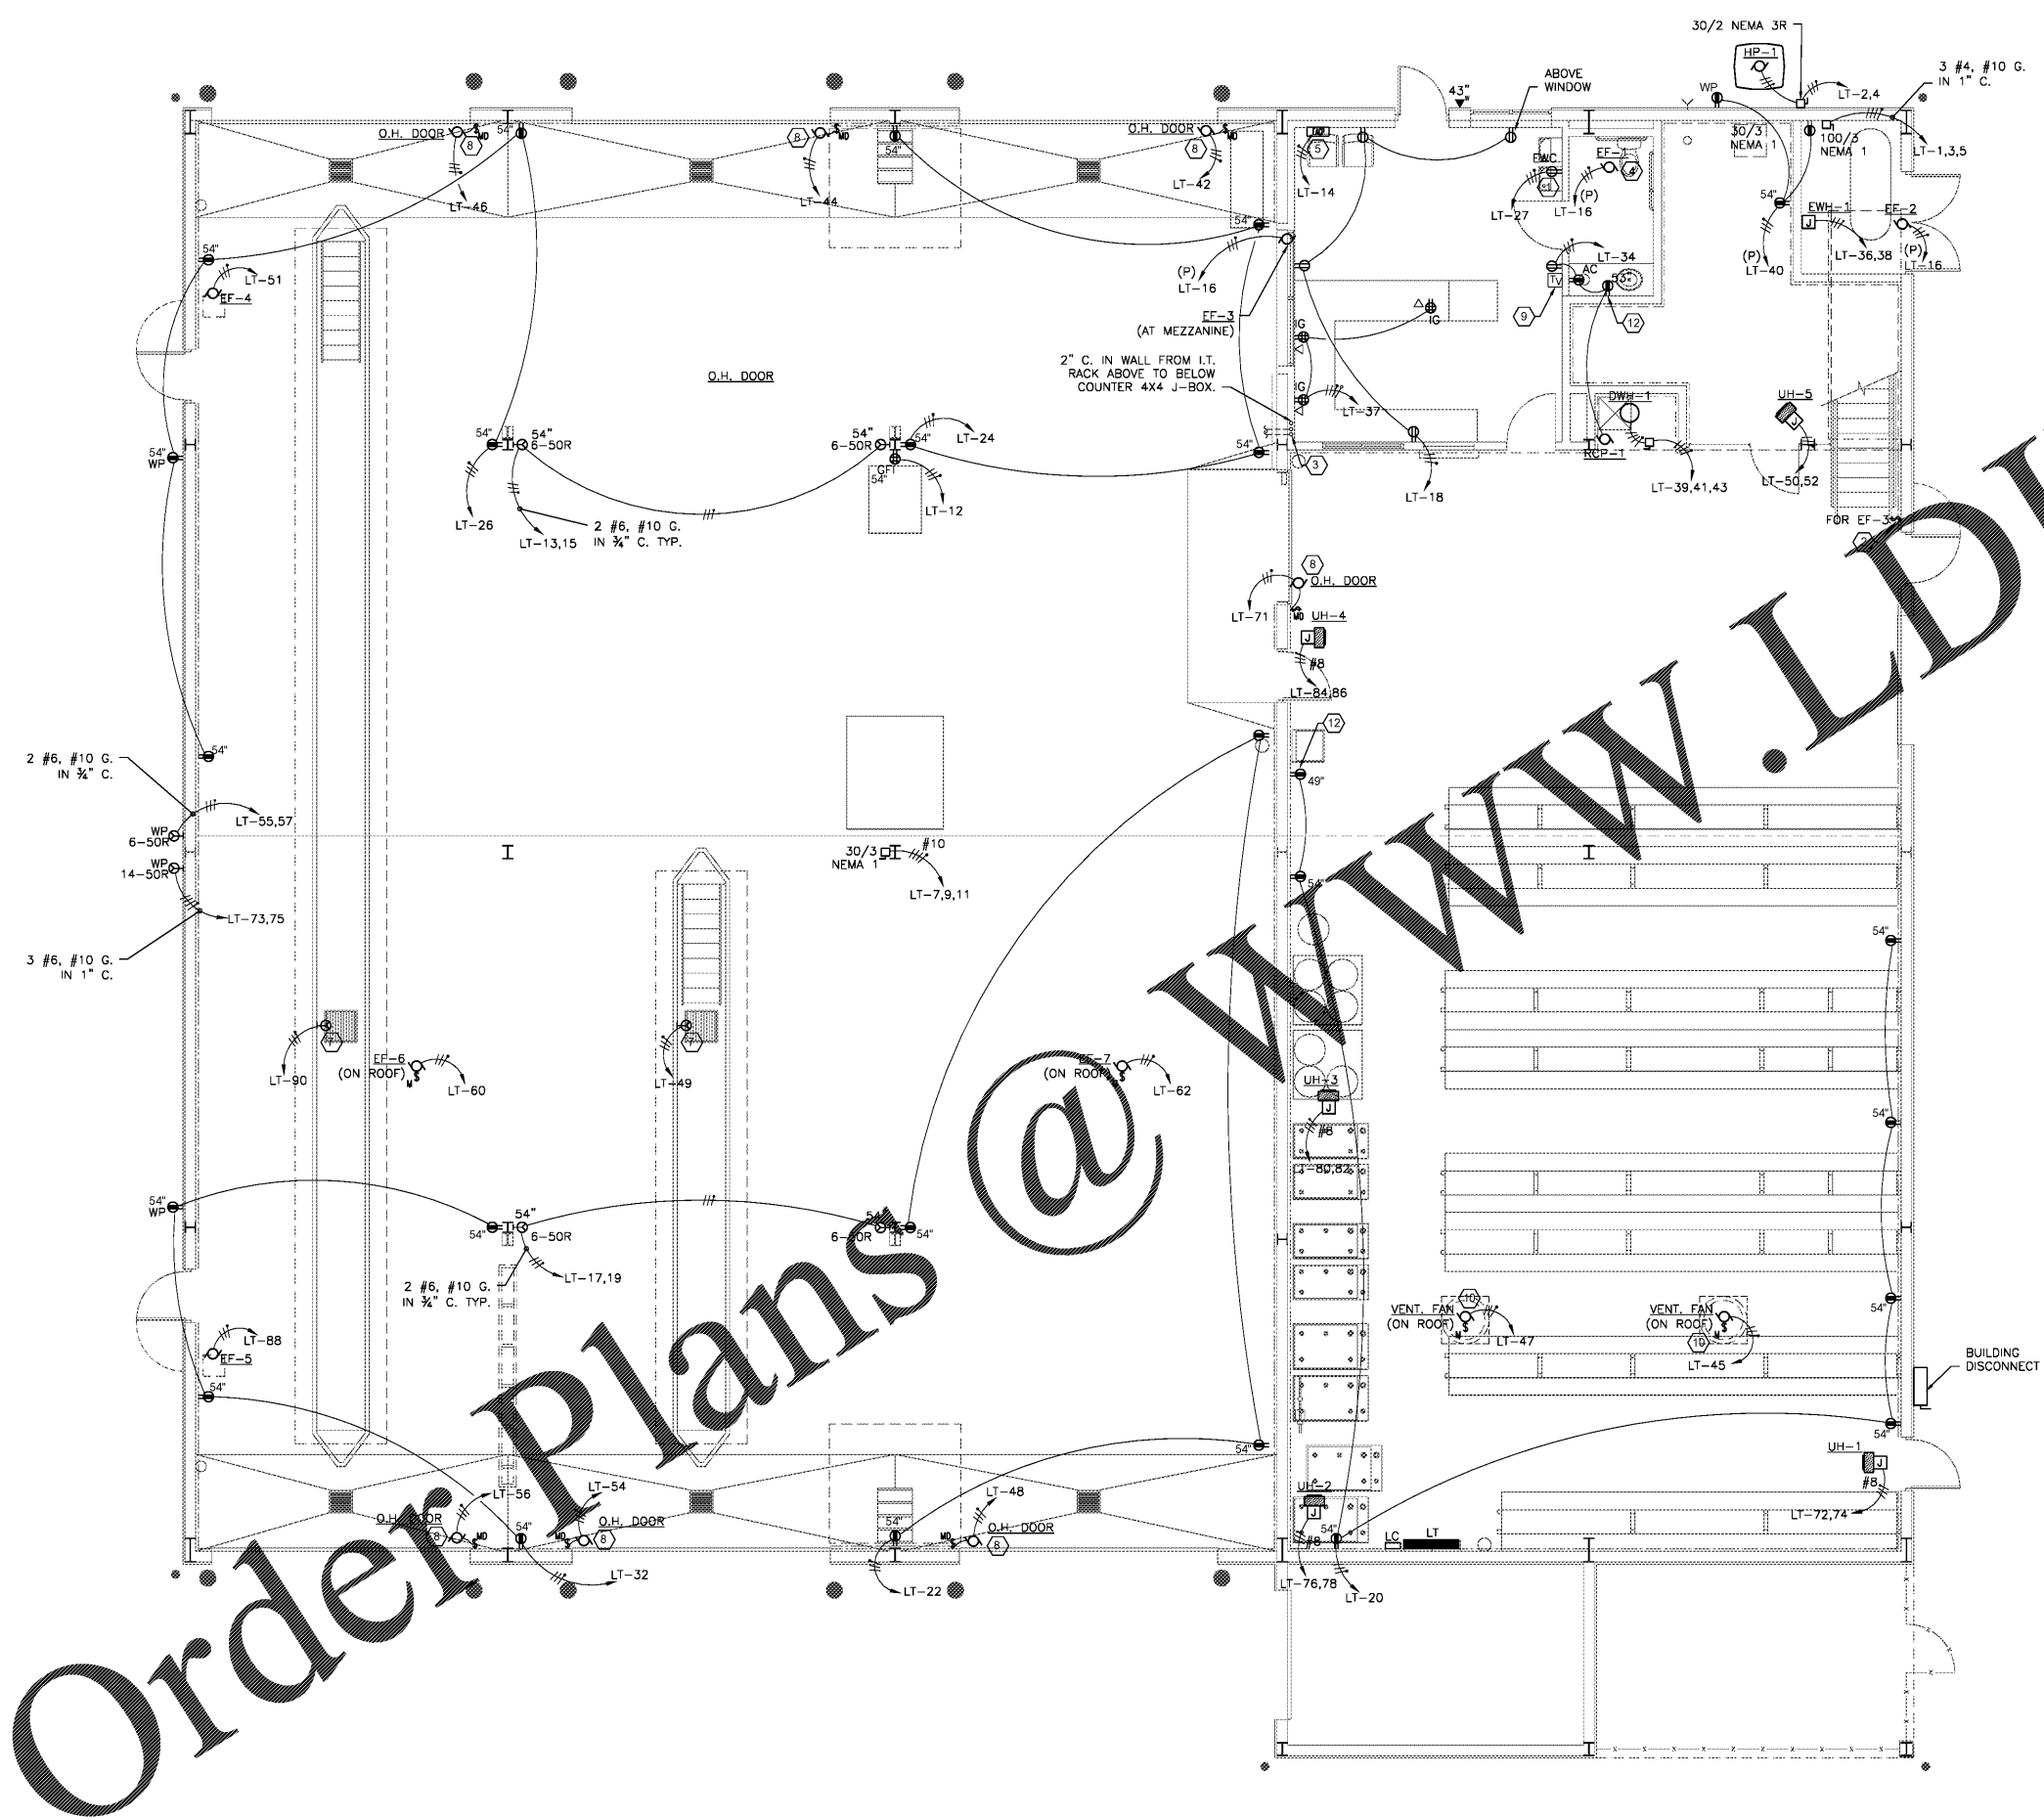


1 FLOOR PLAN - TIRE SHOP - POWER & DATA
3/18 = 1'-0"



Order Plans

WWW.LDILLING.COM

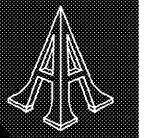

Pascal Aughtry & Associates, PC

405.463.3434
Fax: 405.463.3493
937 East Brilton Road
Oklahoma City, OK 73114
pascsearch.com



Love's
Travel Stops
A NEW TRAVEL STOP
STORE NO. 735
CALHOUN, GA



| Revisions: | |
|------------|------|
| No. | Date |
| | |
| | |
| | |

Project No.: LVS - 18735
Date: 05-22-18
Sheet No.:

YE-3.1

OF: