



1 FLOOR PLAN  
TEMPERATURE CONTROL ZONES  
SCALE: NONE

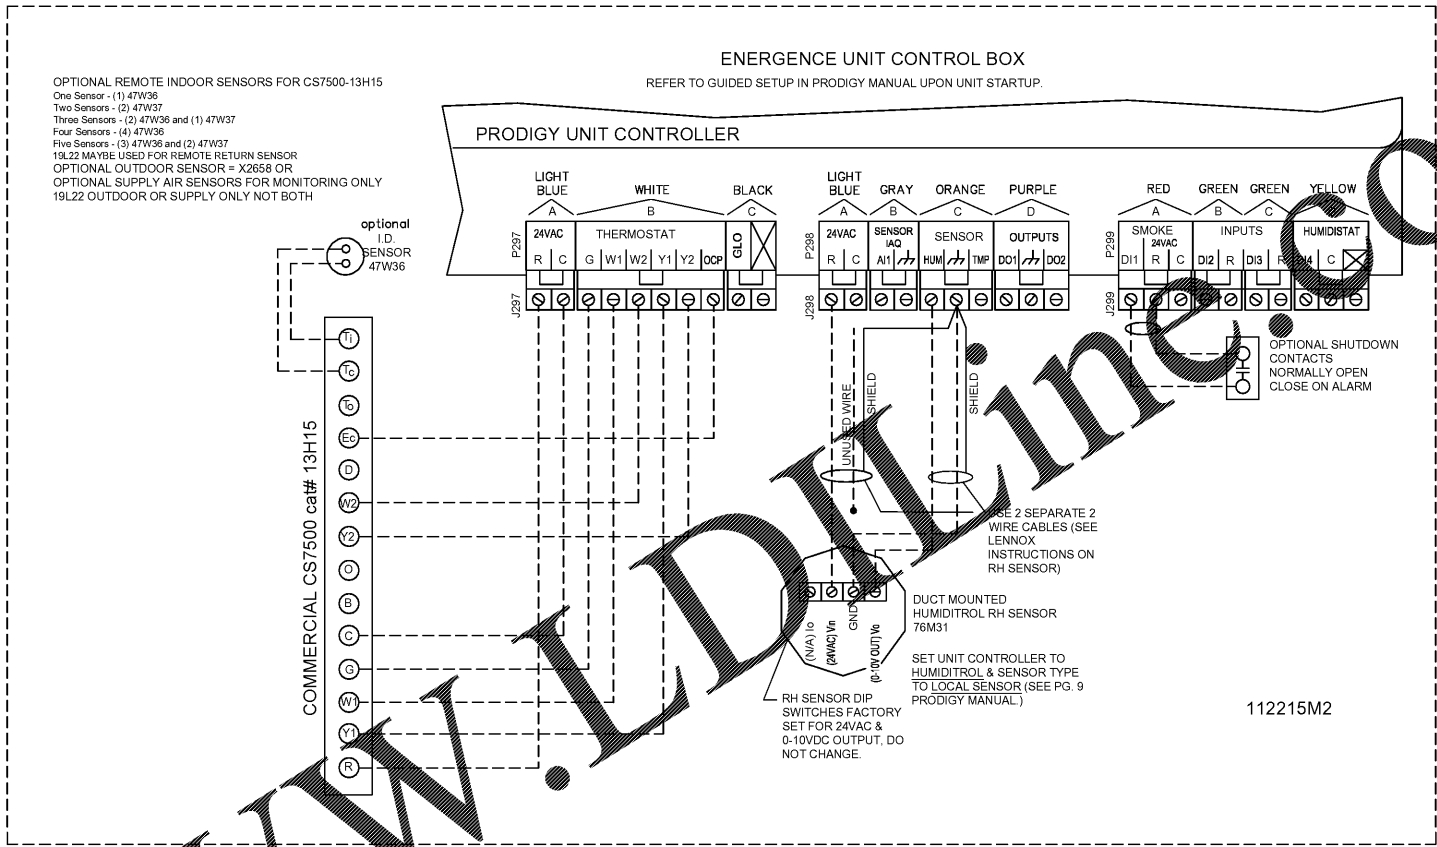


2 LENNIX  
TEMPERATURE CONTROL WIRING DIAGRAM  
SCALE: NONE

Order Plans @ [www.LDOnline.com](http://www.LDOnline.com)

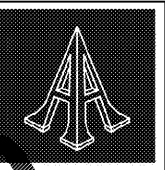

Pascal Aughtry & Associates, PC  
405.463.3494  
Fax: 405.463.3493  
937 East Britton Road  
Oklahoma City, OK 73114  
pascalarch.com

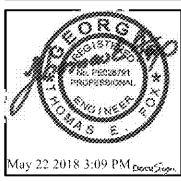

A NEW TRAVEL STOP  
STORE NO. 735  
CALHOUN, GA



Revisions:	
No.	Date

Project No.: LVS - 18735  
Date: 05-22-18  
Sheet No.:

M3.2

OF: