

Pascal Aughtry & Associates, PC

405.463.3434  
Fax: 405.463.3493  
937 East Burton Road  
Oklahoma City, OK 73114  
pascaarch.com



A NEW TRAVEL STOP  
STORE NO. 735  
CALHOUN, GA



Revisions:	
No.	Date

Project No.: LVS - 16735  
Date: 05-22-18  
Sheet No.:

**E-1.3**

OF:


### LIGHTING FIXTURE SCHEDULE (FIXTURES BY OWNER)

ID	MANUF.	MODEL #	VOLT	LAMPS		MOUNT.	MOUNT. HEIGHT	REMARKS
				#	TYPE			
AA	LSI	CRU SC LED HO CW UE WHT	208	--	LED (140W)	CANOPY	--	NOTE 2
AAB	LSI	CRU SC LED HO CW UE BRZ	208	--	LED (140W)	CANOPY	--	NOTE 2
BB	MCGRAW EDISON	GLEON AF 06 LED E1 SL3 BZ	208	--	LED (333W)	POLE	33'	POLE: RTS8A30SFN1 (NOTE 1)
CC	MCGRAW EDISON	GLEON AF 06 LED E1 SL4 BZ	208	--	LED (333W)	POLE	33'	POLE: RTS8A30SFN1 (NOTE 1)
2CC	MCGRAW EDISON	(2)GLEON AF 06 LED E1 SL4 BZ	208	--	LED (333W)	POLE	33'	POLE: RTS8A30SFN2 (NOTE 1)
DD	MCGRAW EDISON	GLEON AF 08 LED E1 SL3 BZ	208	--	LED (445W)	POLE	42'	POLE: RTS8A30SFN1 (NOTE 1)
EE	MCGRAW EDISON	GLEON AF 08 LED E1 SL4 BZ	208	--	LED (445W)	POLE	42'	POLE: RTS8A30SFN1 (NOTE 1)

LIGHT FIXTURE NOTES:  
 1. REFER TO SHEET SP-8 FOR POLE MOUNTED FIXTURE BASE DETAILS. STANDARD BASE IS 36" TALL.  
 2. CANOPY FIXTURES SHALL BE INSTALLED BY CANOPY CONTRACTOR. WIRING BY E.C.

### GENERAL NOTES

1. ALL SITE FIXTURES SHALL BE MINIMUM #10 AWG (UNLESS OTHERWISE NOTED).  
 2. ALL ILLUMINANCE CALCULATIONS SHOWN ARE IN FOOTCANDLES (FC) AND ARE AT 30" ABOVE THE FIXTURE. PHOTOMETRIC FILES USED ARE PROVIDED BY THE MANUFACTURER.

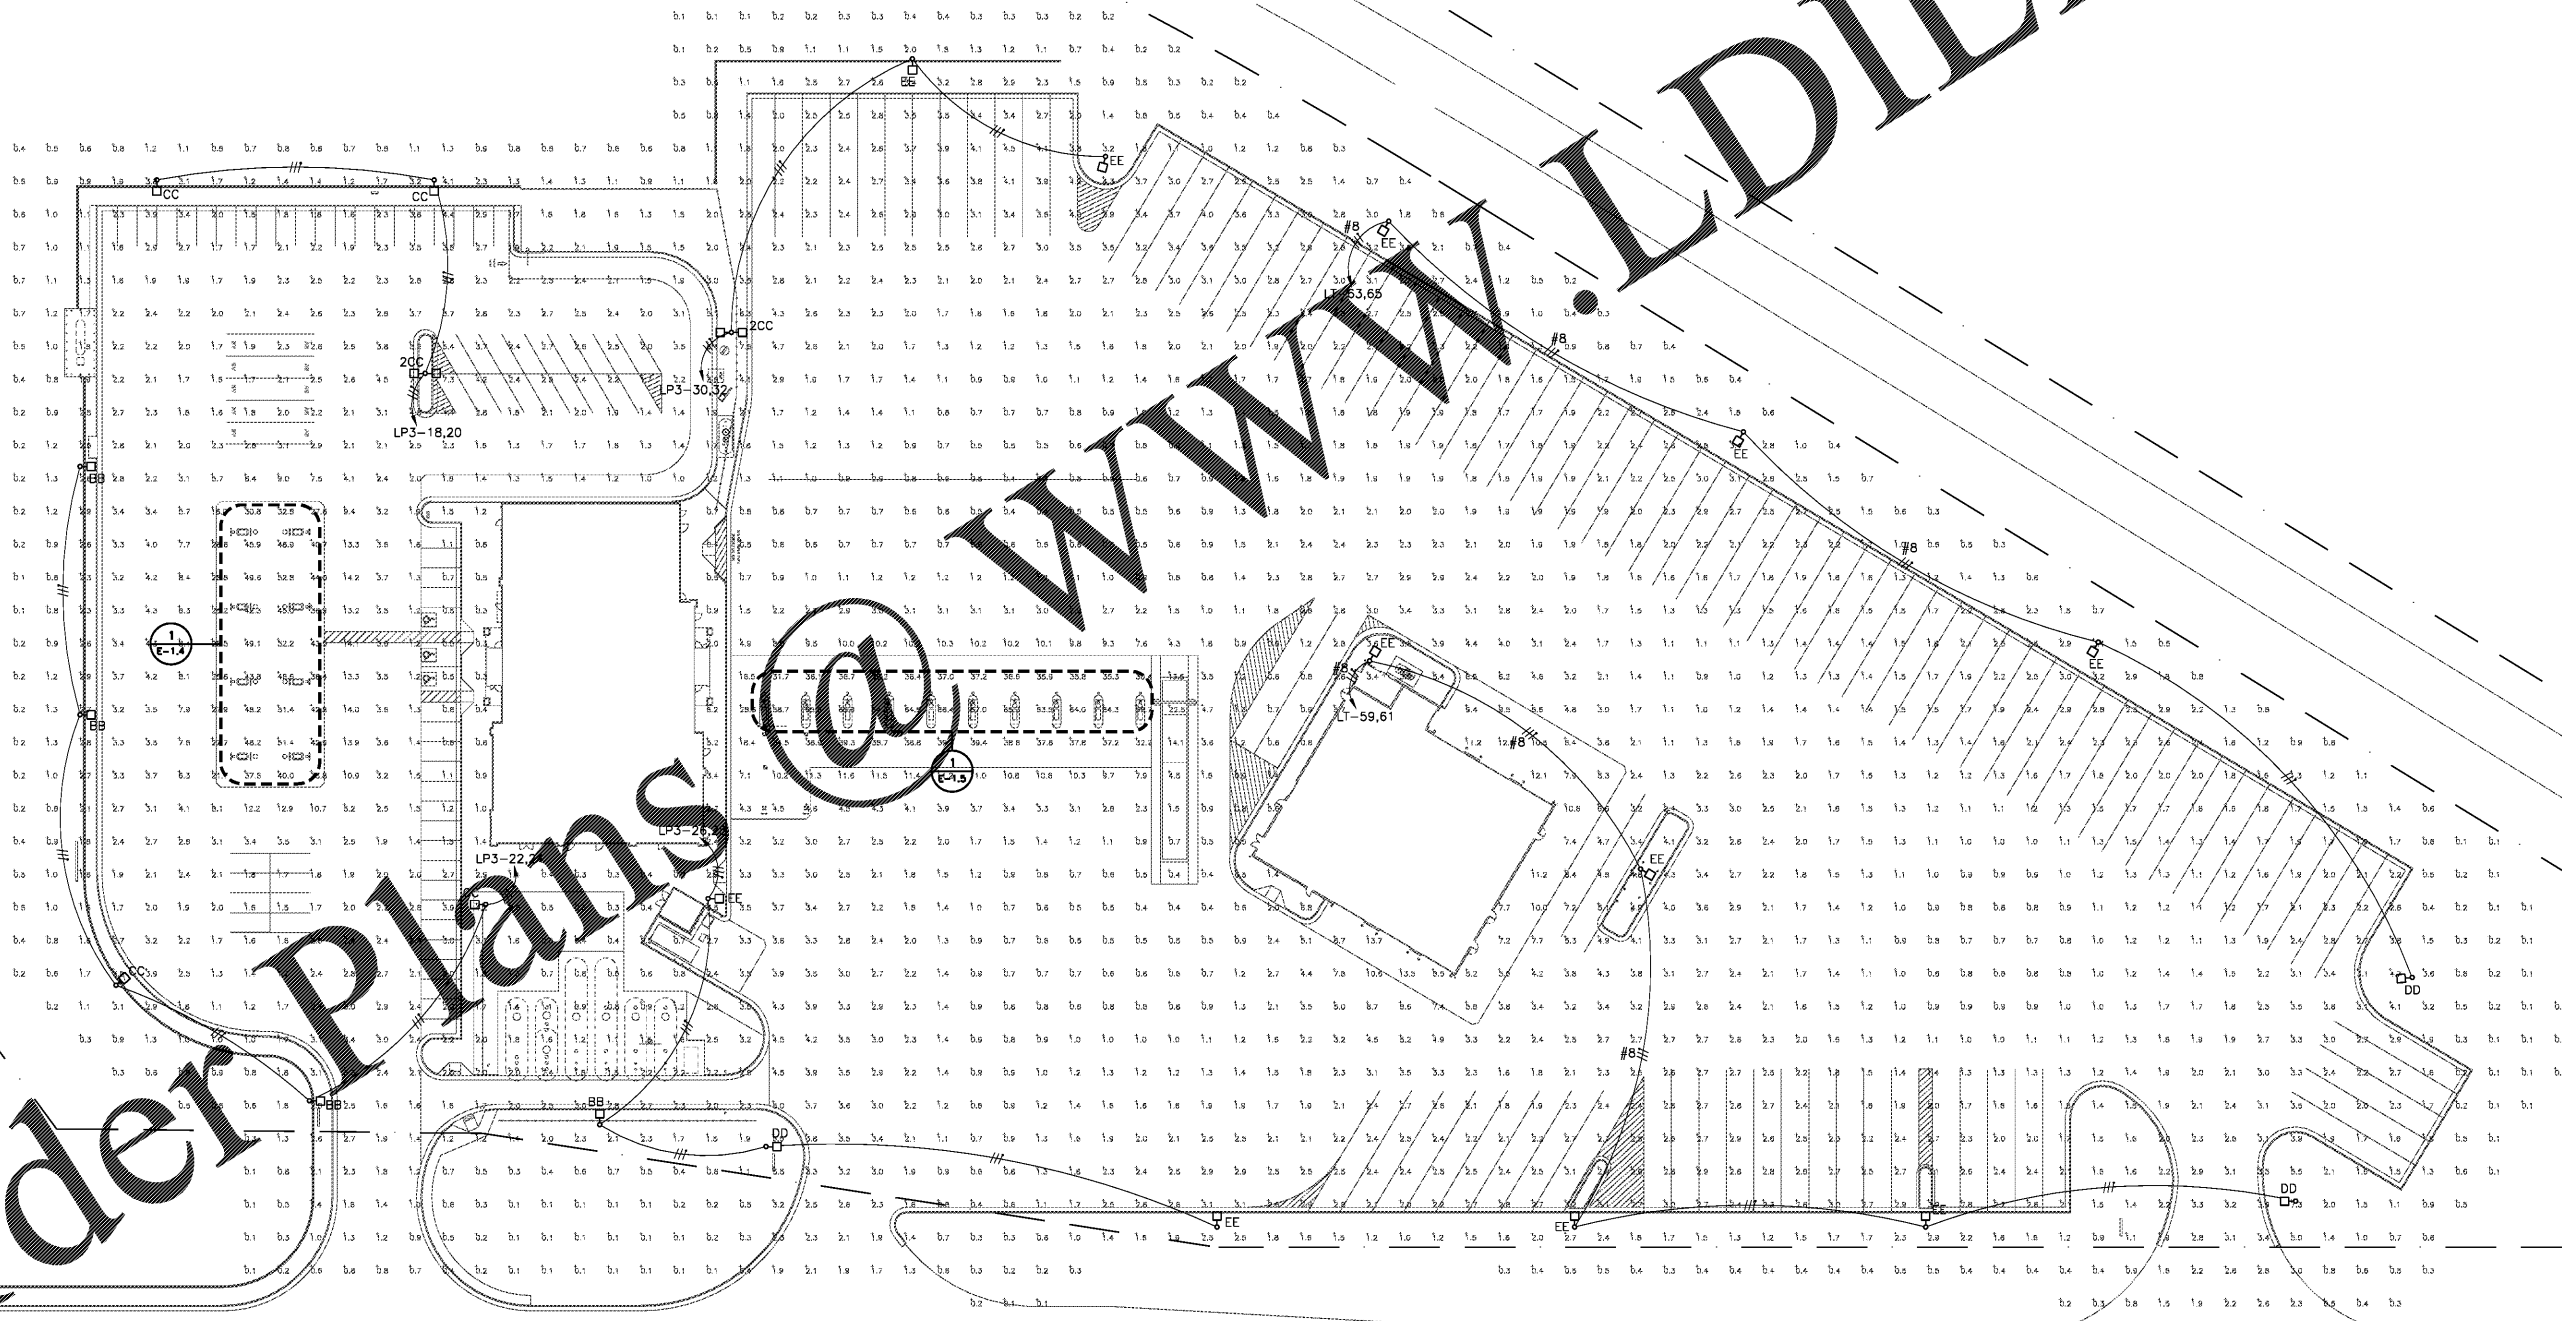

Order Plans @ WWW.LDILINE.COM

1 SITE PLAN - LIGHTING  
 1" = 40'-0"